
 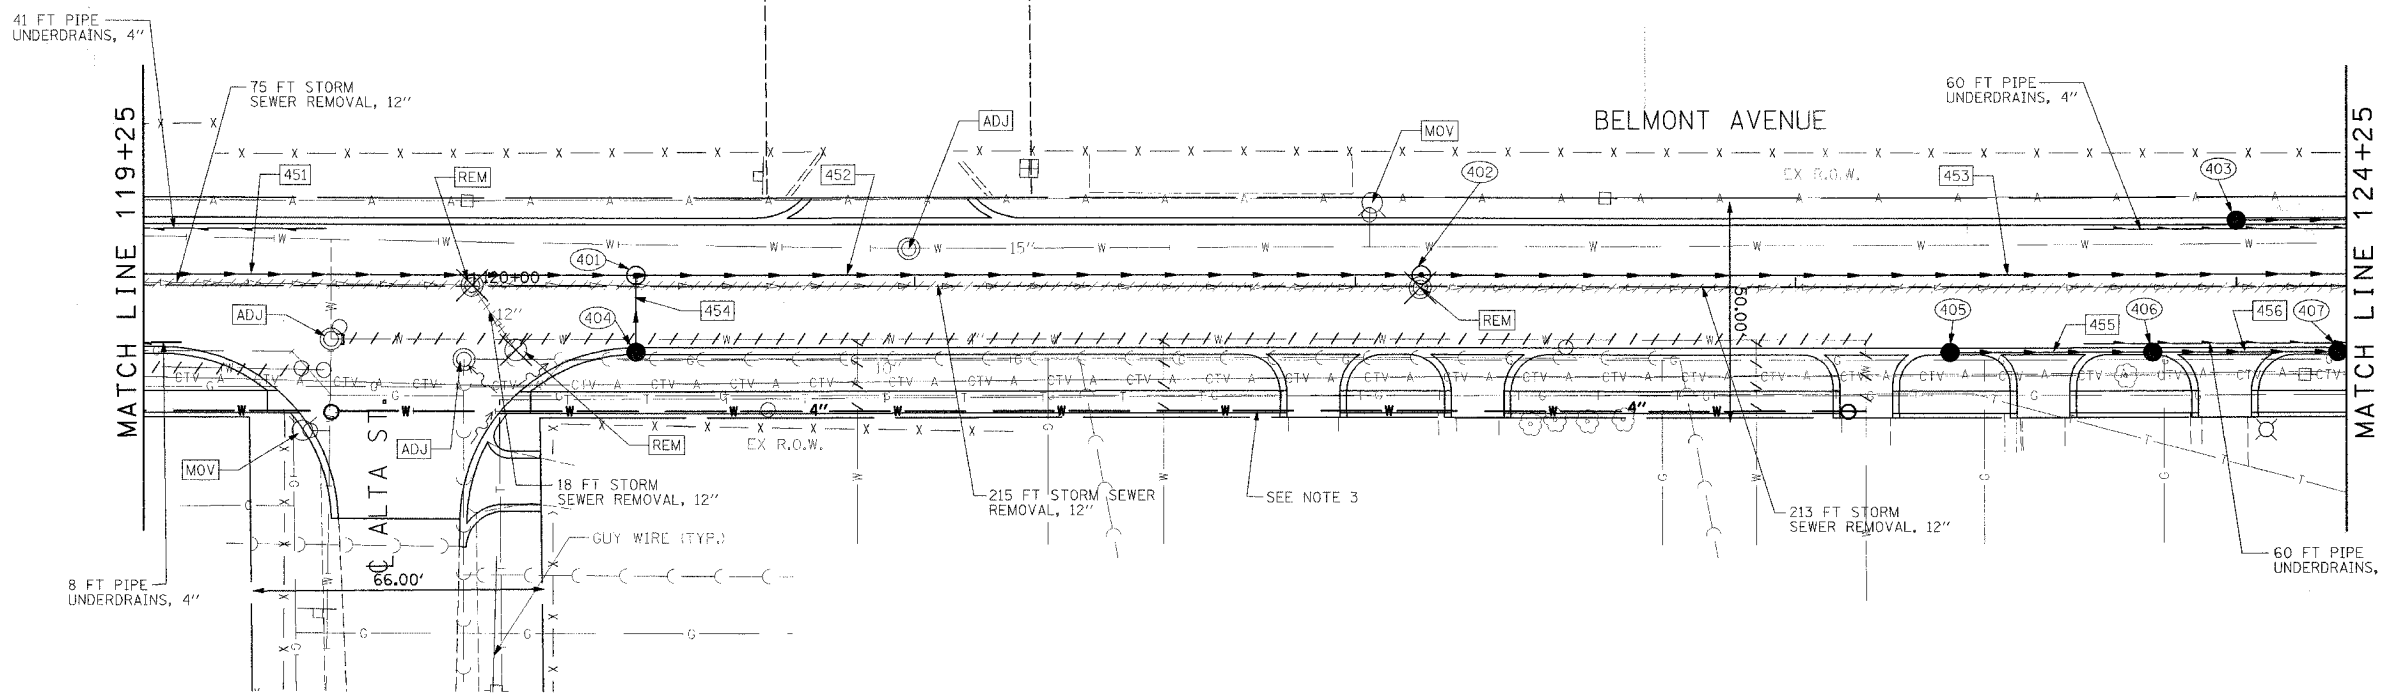




F.A. RTE.	SECTION	COUNTY	TOTAL SHEETS	SHEET NO.
1373	00-00058-00-RS	COOK	113	37
STA. 119+25		TO STA. 124+25		
FED. ROAD DIST. NO. ILLINOIS FED. AID PROJECT				
CONTRACT No. 83861				



- NOTE
- SEE SHEET 34 FOR DRAINAGE LEGEND.
  - CONTRACTOR TO CONNECT PIPE UNDERDRAINS TO CATCH BASINS AND GROUT IN PLACE. THIS WORK SHALL BE INCLUDED IN THE CONTRACT UNIT PRICE PER FOOT OF PIPE UNDERDRAINS, 4".
  - SEE "LEYDEN TOWNSHIP UTILITY RELOCATION PLAN AND PROFILE" FOR DETAILED INFORMATION ON THE SANITARY SEWER AND WATER MAIN RELOCATIONS AND SANITARY AND WATER SERVICE ADJUSTMENTS.

**PLAN**

 SCALE: 1"=20'

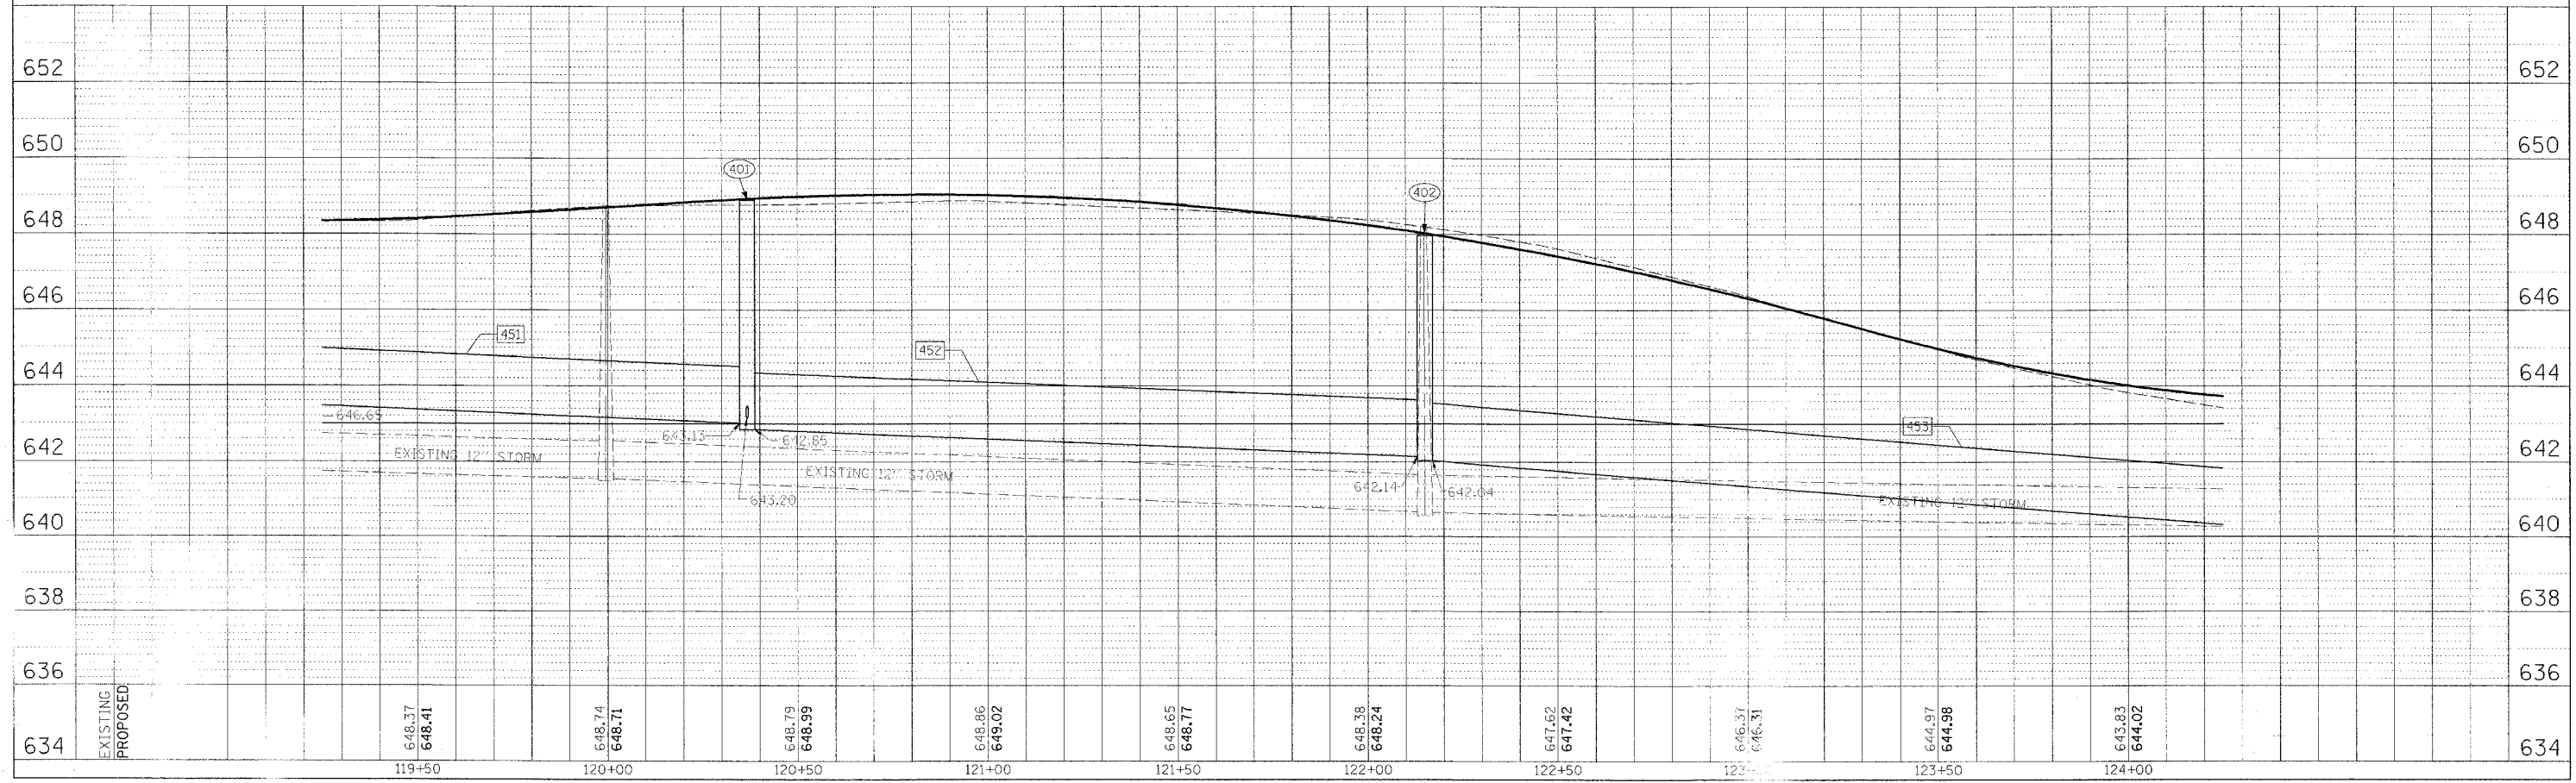

**DRAINAGE PLAN AND PROFILE STA. 119+25 TO STA. 124+25**

DATE	BY	REVISION

DATE	BY	REVISION

p:\projects\119\119\119\119.dwg  
 11/17/05  
 11/17/05