



F.A. R.T.E.	SECTION	COUNTY	TOTAL SHEETS	SHEET NO.
1373	00-00058-00-RS	COOK	113	40
STA. 134+75		TO STA. 139+75		
FED. ROAD DIST. NO.		ILLINOIS FED. AID PROJECT		
CONTRACT No: 83861				

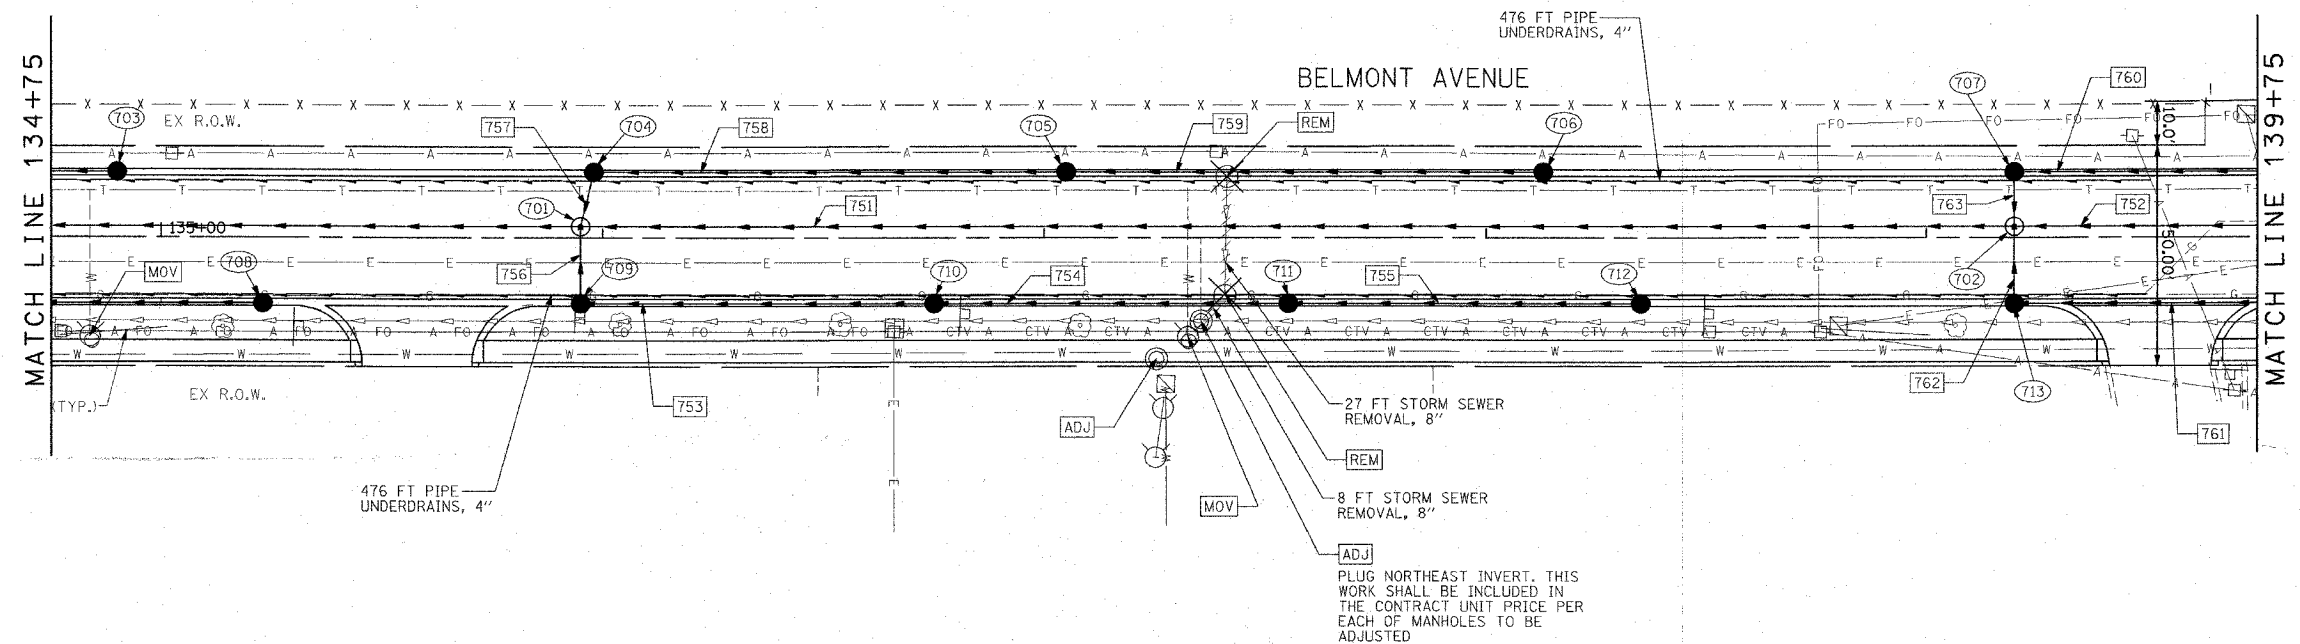

- NOTE
- SEE SHEET 34 FOR DRAINAGE LEGEND.
 - CONTRACTOR TO CONNECT PIPE UNDERDRAINS TO CATCH BASINS AND GROUT IN PLACE. THIS WORK SHALL BE INCLUDED IN THE CONTRACT UNIT PRICE PER FOOT OF PIPE UNDERDRAINS, 4".
 - SEE "LEYDEN TOWNSHIP UTILITY RELOCATION PLAN AND PROFILE" FOR DETAILED INFORMATION ON THE SANITARY SEWER AND WATER MAIN RELOCATIONS AND SANITARY AND WATER SERVICE ADJUSTMENTS.


PLAN

 SCALE: 1"=20'



DATE	BY

DATE	BY

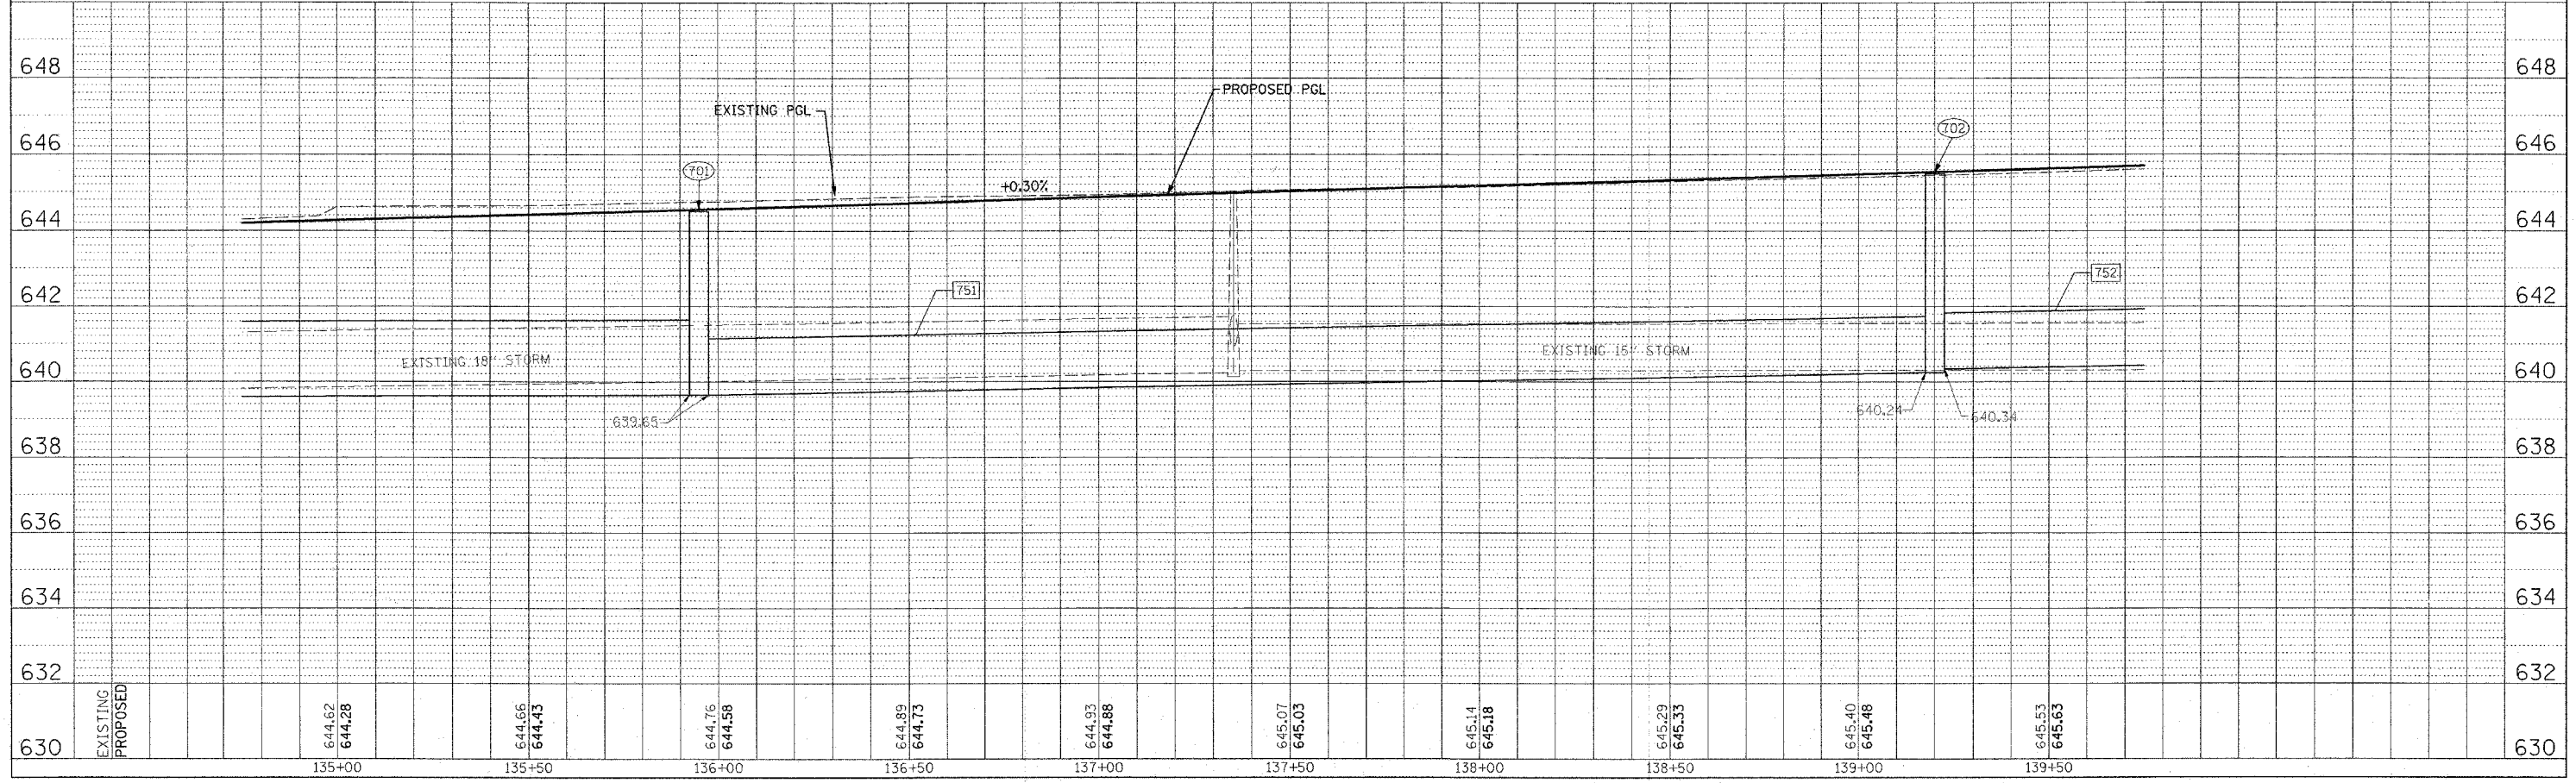

DRAINAGE PLAN AND PROFILE STA. 134+75 TO STA. 139+75

e:\14200\plans\sheets\14300\drpl\0108.dgn
 5/24/2006
 6:30:45 PM