
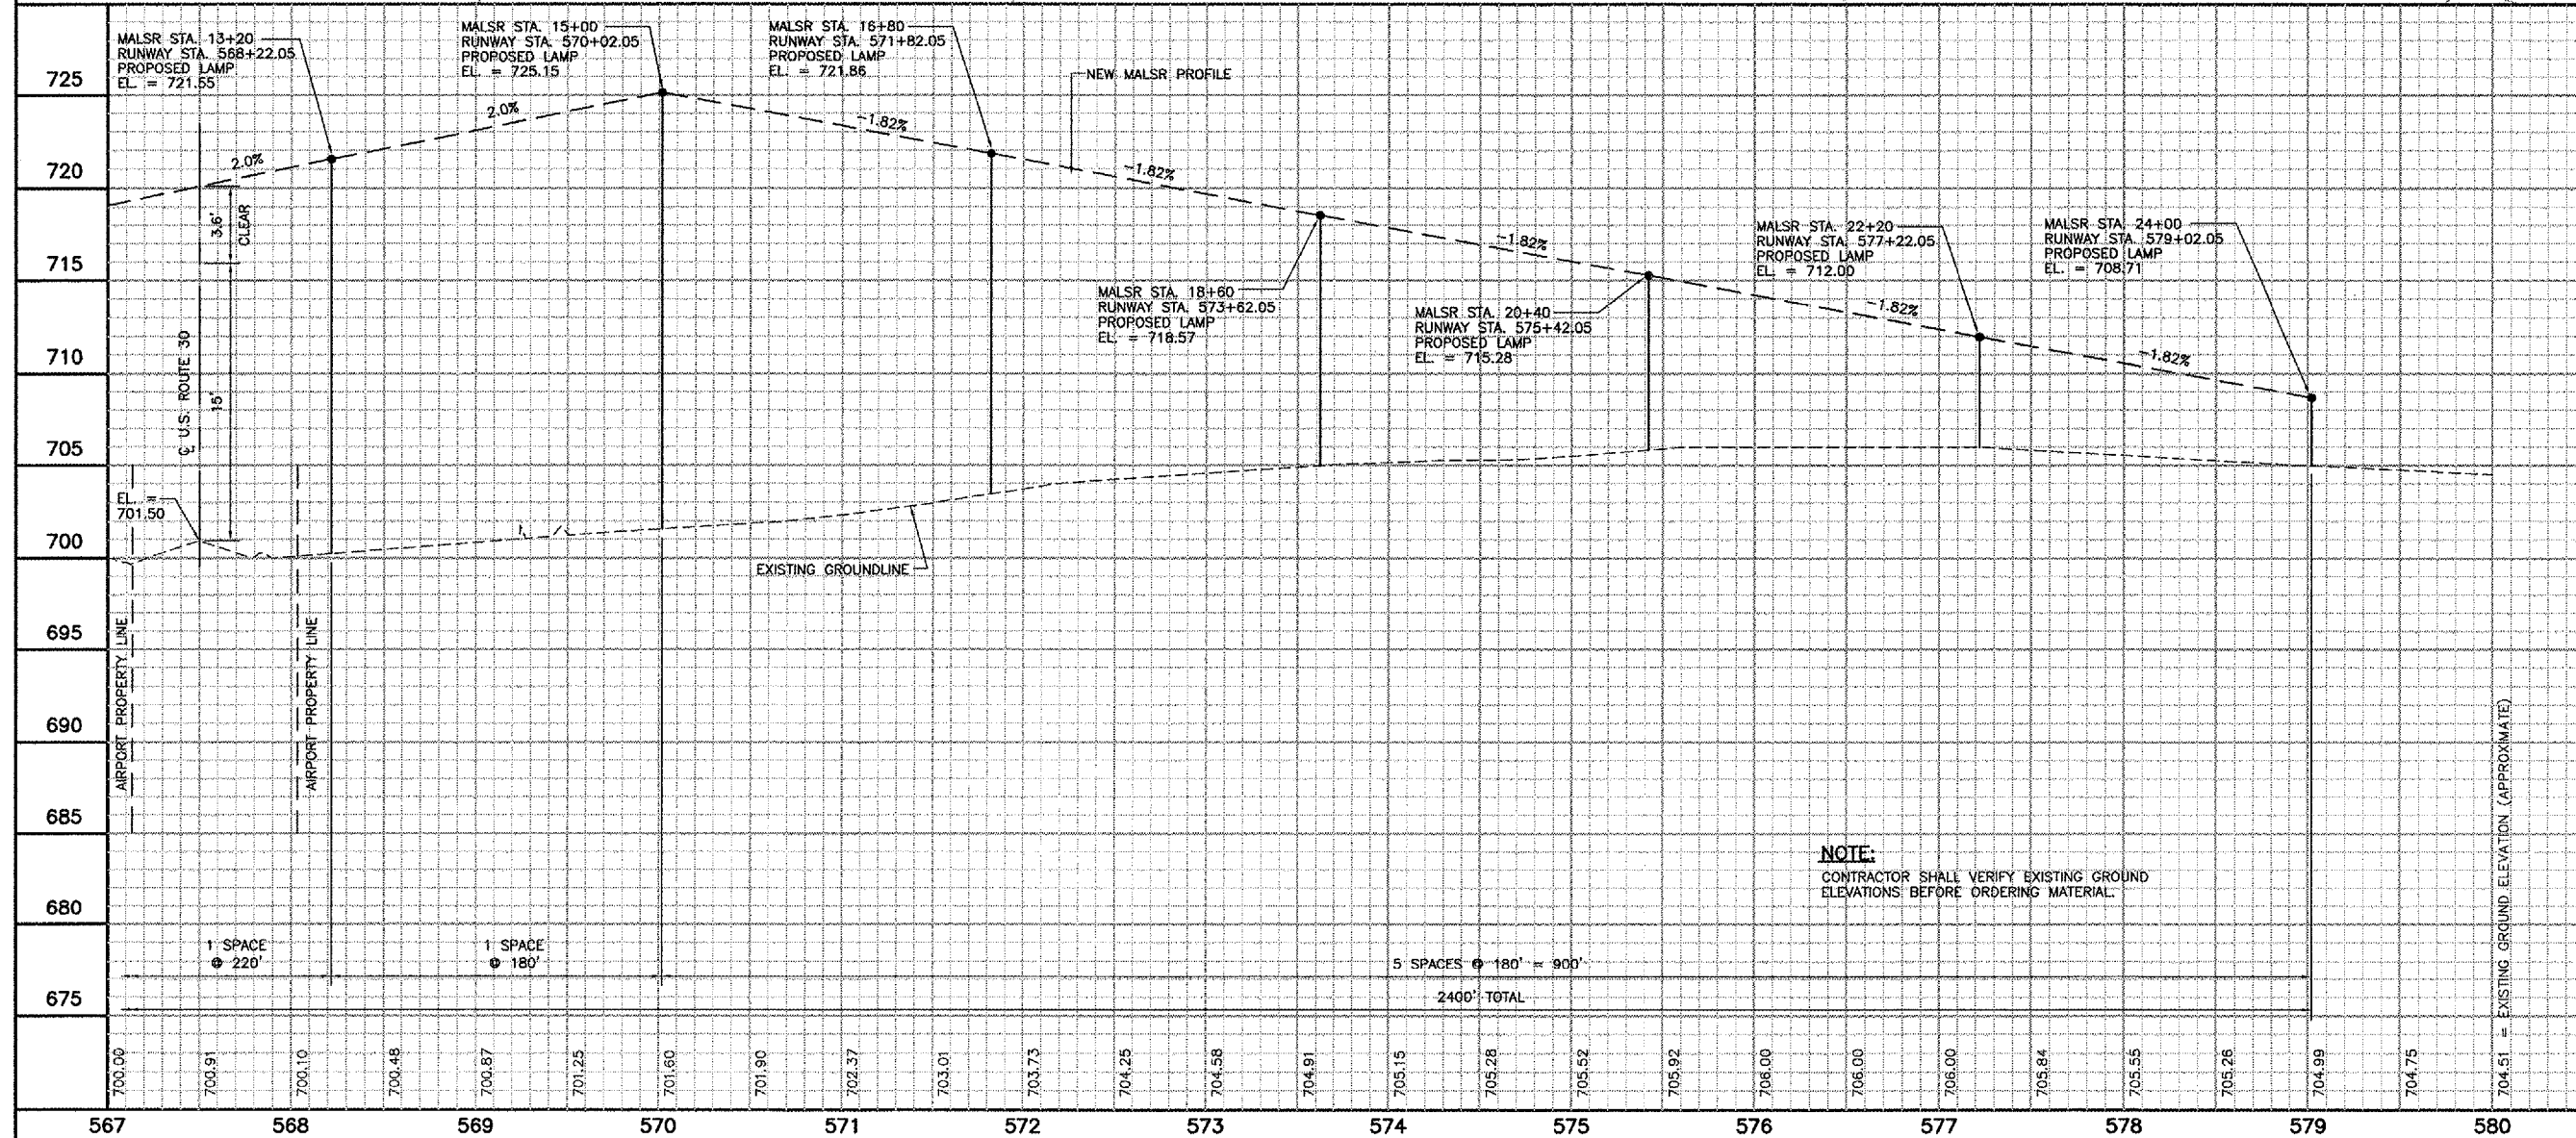
 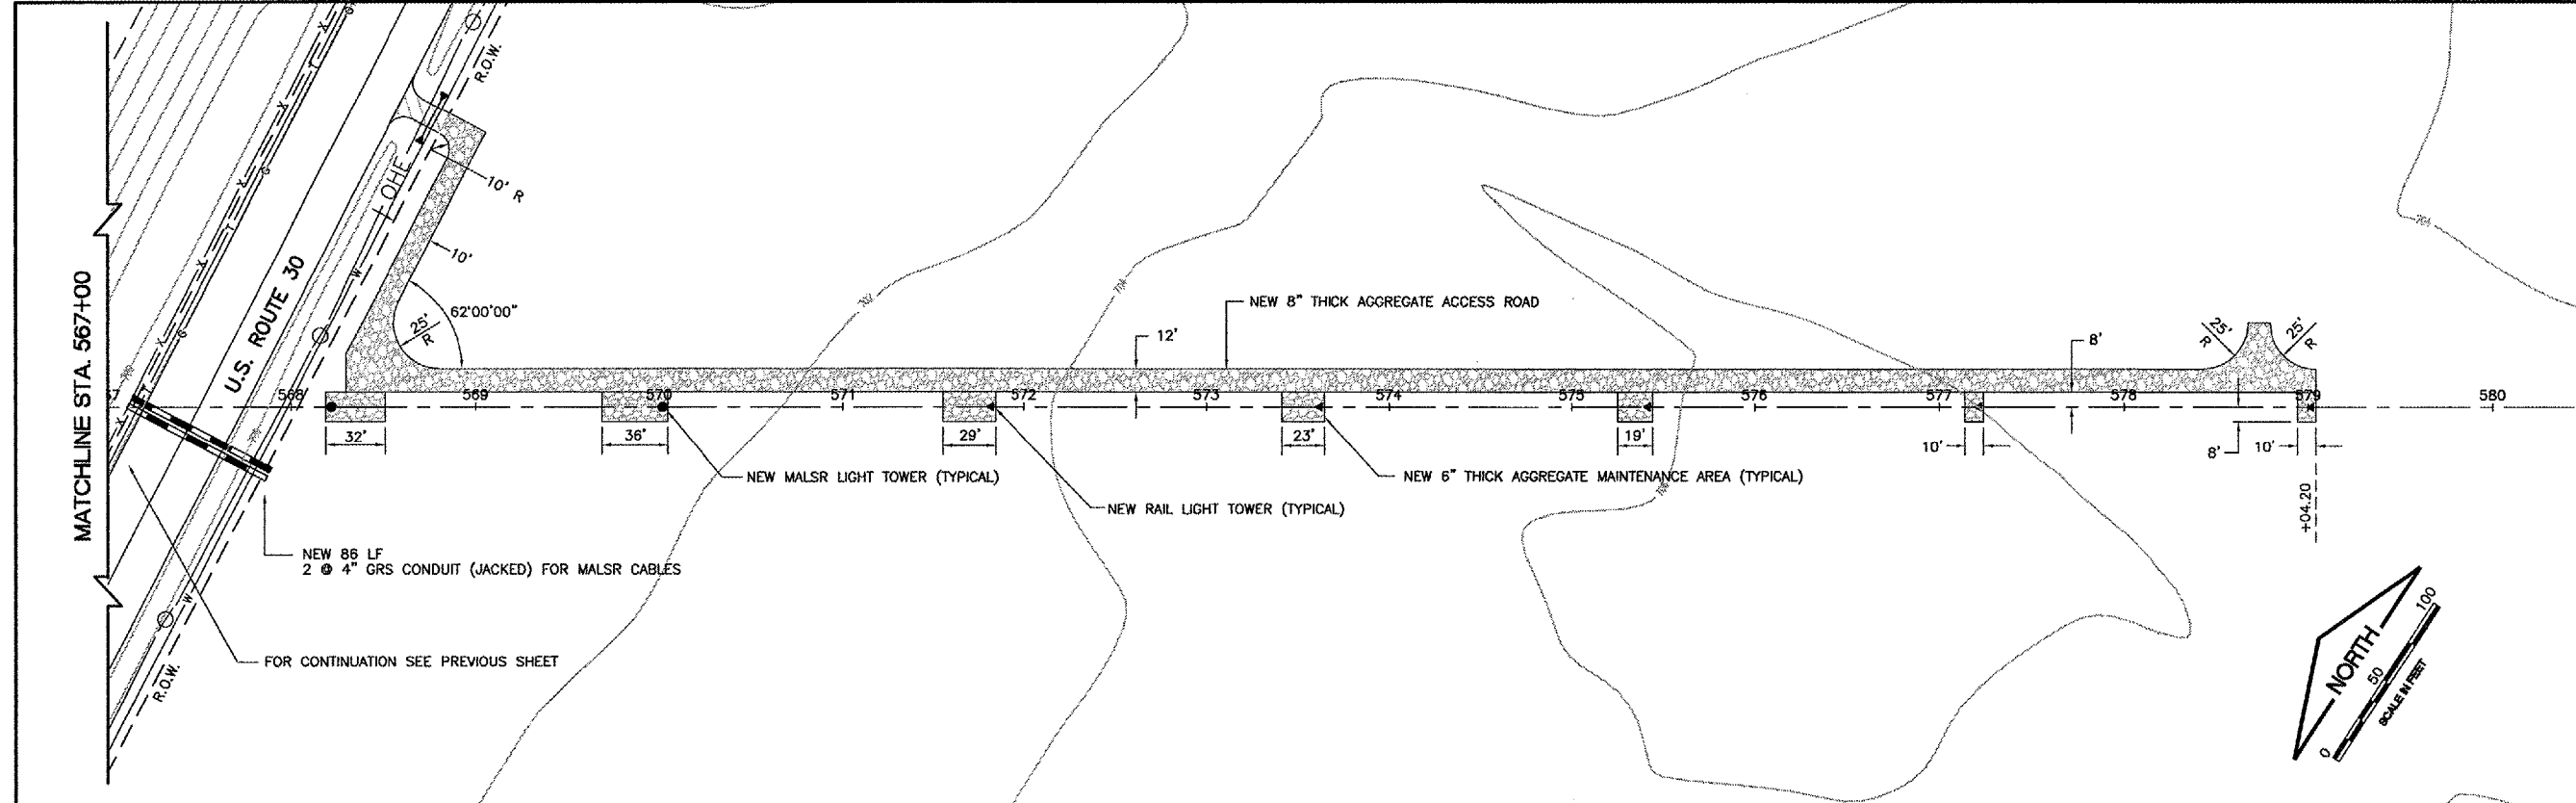


REVISIONS		
NUMBER	BY	DATE



**AURORA MUNICIPAL AIRPORT
 AURORA, ILLINOIS
 CONSTRUCT RUNWAY 33 ILS,
 RELOCATE RUNWAY 9 LOCALIZER
 RUNWAY 33 MALSR PLAN AND PROFILE
 MALSR STATIONS 13+20 - 24+00
 ARR-D-MALSR33-C02**

© Copyright CMT, Inc.
CMT
 CRAWFORD, MURPHY & TILLY, INC.
 CONSULTING ENGINEERS
 License No. 184-000618

DESIGN BY:	CAL
DRAWN BY:	JRO
CHECKED BY:	CAL
APPROVED BY:	
DATE:	05/12/06
JOB No:	04285-04

ILLINOIS PROJECT: ARR-3468
 A.I.P. PROJECT: 3-17-0003-B31
FINAL SUBMITTAL