

901 SEEDING NOTES

THE PROPOSED SEEDING SHALL BE ACCOMPLISHED IN ACCORDANCE WITH ITEM 901 "SEEDING" AS STATED IN THE SPECIAL PROVISIONS.

A WORK AREA WIDTH OF 4' HAS BEEN SET ASIDE FOR THE CONTRACTOR TO INSTALL THE PROPOSED UNDERDRAIN PIPE AND THIS WORK AREA WILL BE SEEDDED IN ACCORDANCE WITH THE ABOVE NOTED SPECIFICATION. ALL AREAS OUTSIDE THE DESIGNATED WORK AREA LIMITS WILL ALSO BE SEEDDED BUT AT THE CONTRACTOR'S OWN EXPENSE.

ALL MATERIALS AND/OR DEBRIS RESULTING FROM THE SEEDING OPERATIONS WILL BE REMOVED FROM THE PAVEMENTS AND MISCELLANEOUS STRUCTURES PRIOR TO OPENING THE RUNWAY.

NO LIME WILL BE REQUIRED.

ANY COMMERCIALY AVAILABLE 12-12-12 FERTILIZER MIXTURE WILL BE APPLIED AT A RATE OF 0.14 POUNDS PER SQUARE YARD.

AN IDOT CLASS 2 ROADSIDE SEED MIXTURE WILL BE PLACED AT A RATE OF 0.04 POUNDS PER SQUARE YARD.

901-3.4 MAINTENANCE OF SEEDDED AREAS. DELETE THE SECOND PARAGRAPH OF THIS SECTION AND ADD THE FOLLOWING:

"THE CONTRACTOR WILL BE REQUIRED TO ESTABLISH A GOOD STAND OF GRASS OF UNIFORM COLOR AND DENSITY TO THE SATISFACTION OF THE RESIDENT ENGINEER. IF AT THE TIME WHEN THE CONTRACT HAS BEEN OTHERWISE COMPLETED, IT IS NOT POSSIBLE TO MAKE AN ADEQUATE DETERMINATION OF COLOR, DENSITY, AND UNIFORMITY OF SUCH STAND OF GRASS, THE ITEM OF WORK WILL BE REVIEWED AT A LATER DATE DETERMINED BY THE ILLINOIS DIVISION OF AERONAUTICS."

DATE SEEDING COMPLETED _____

 




 





THE PROPOSED SEEDING WILL BE PAID FOR UNDER ITEMS: AR901530 STRIP SEEDING _____ 3,056 S.Y.

 
EXCELSIOR BLANKET NOTES

AN EROSION CONTROL MATERIAL (EXCELSIOR BLANKET) WILL BE INSTALLED OVER THE DESIGNATED WORK AREA AND IN ACCORDANCE WITH THE SPECIAL PROVISIONS.



THIS ITEM OF WORK SHALL BE PAID FOR UNDER ITEM AR908520 "EXCELSIOR BLANKET" _____ 3,056 S.Y.

LEGEND


-  EXISTING PAVEMENT
-  EXISTING STORM SEWER
-  PROPOSED UNDERDRAIN
-  PROPOSED INSPECTION HOLE
-  EXISTING ELECTRICAL DUCT
-  EXISTING UNDERDRAIN
-  EXISTING BASE MOUNT RUNWAY LIGHT
-  EXISTING STAKE MOUNT RUNWAY LIGHT
-  EXISTING STAKE MOUNT TAXIWAY LIGHT
-  EXISTING STAKE MOUNT THRESHOLD LIGHT
-  EXISTING TAXI GUIDANCE SIGN



SCALES:
1" = 50' HOR
1" = 2' VER

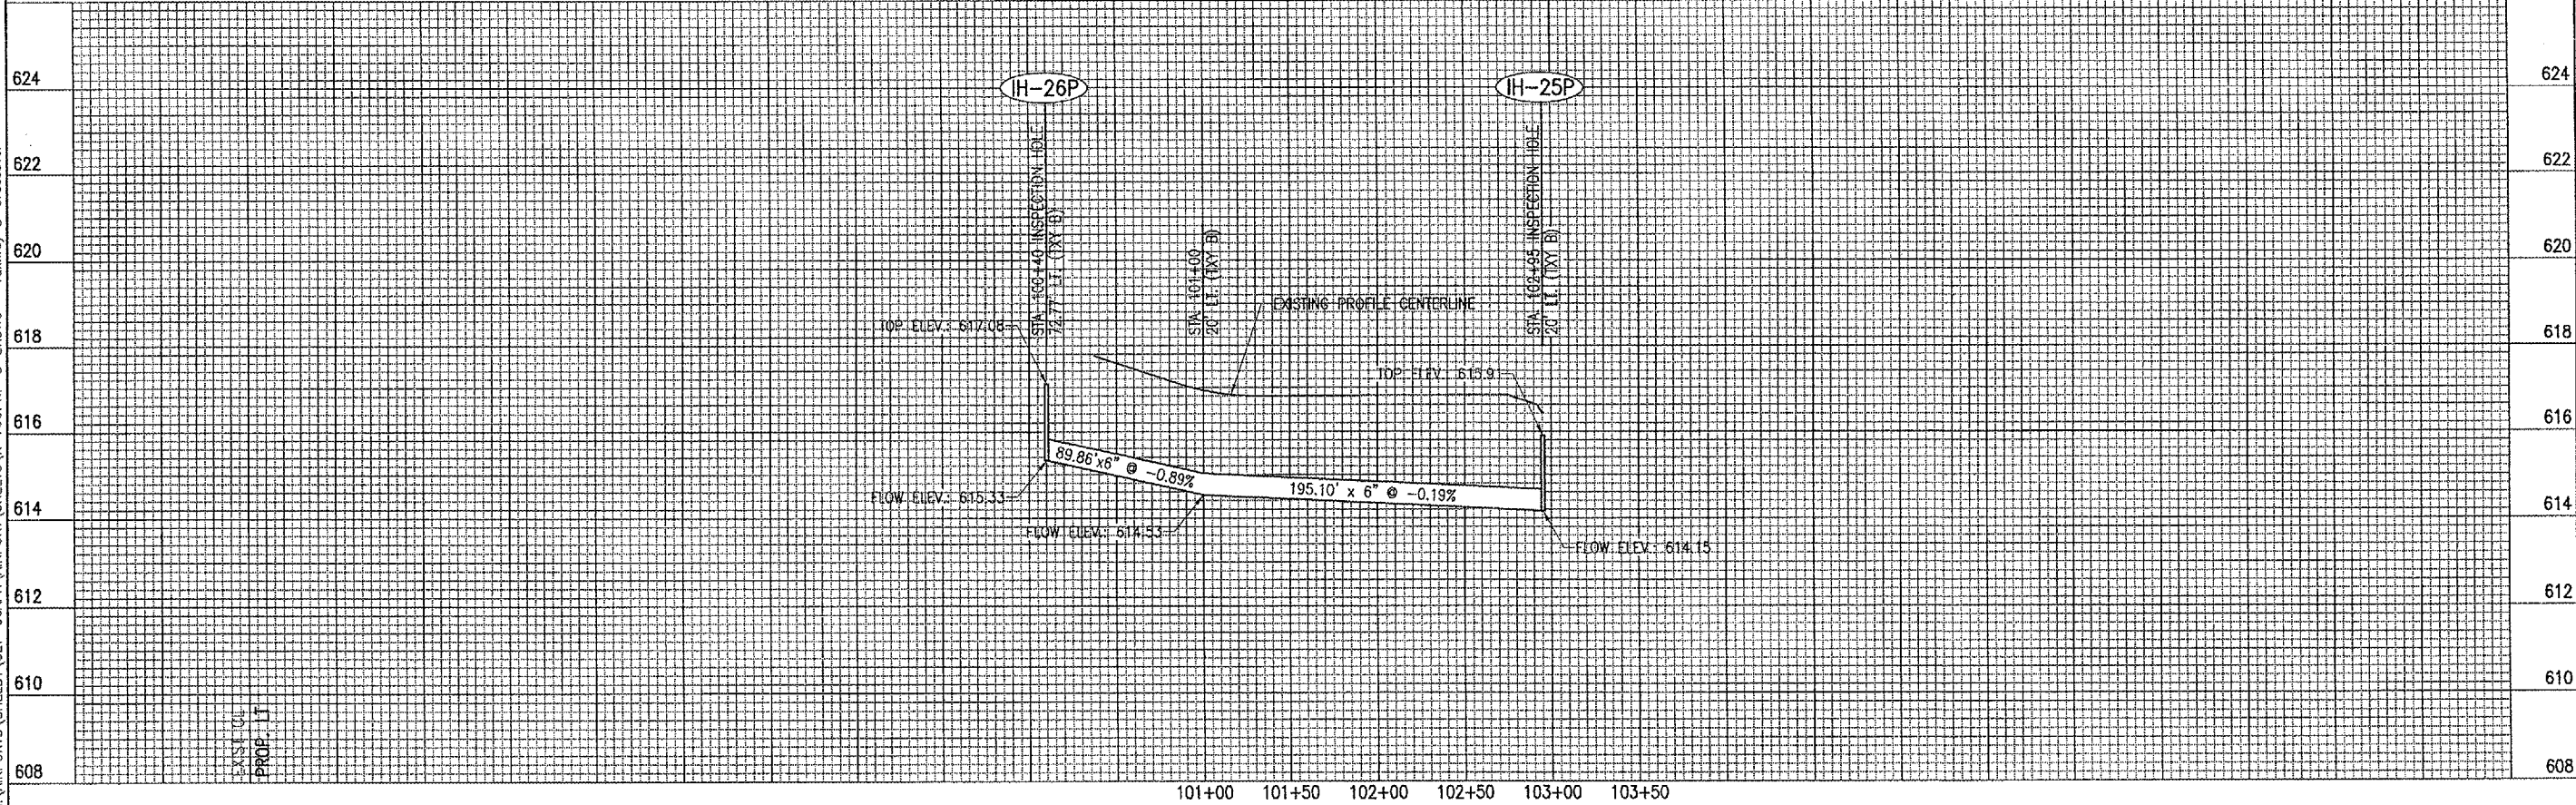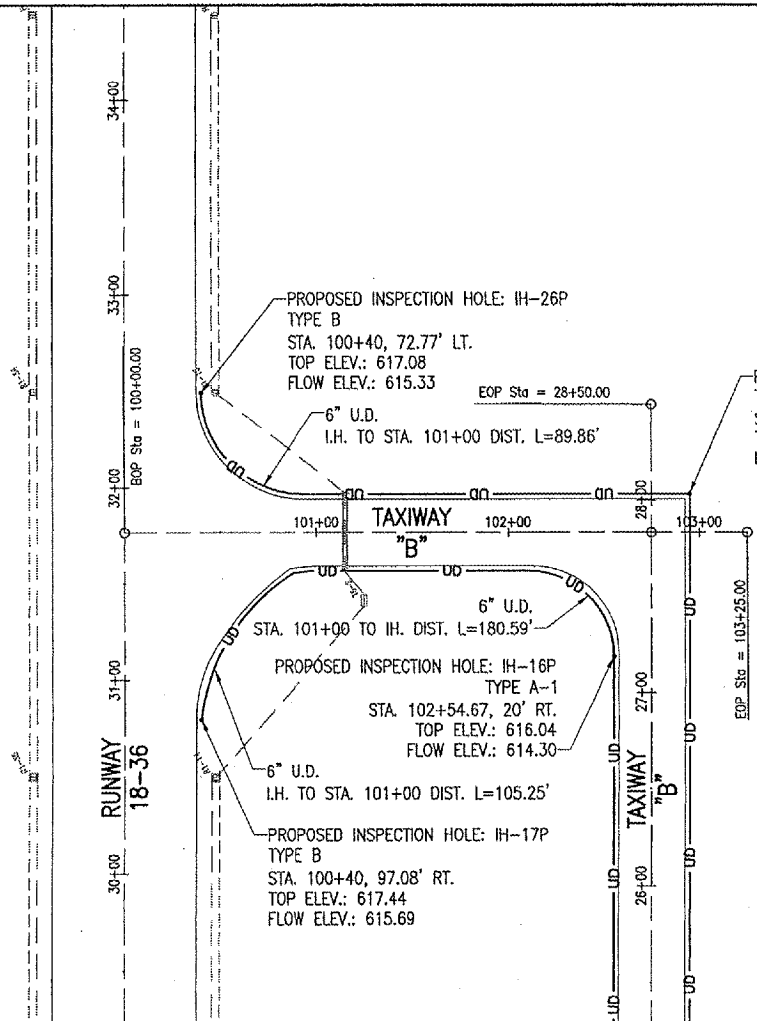

JUL 05, 2006 9:01 PM RAW I:\AIRPORTS\SHELBY\827-06APN\AIRPORT SHEETS\R-705PNP-B-LT.DWG - Taxiway B-Crossover

DATE		REVISION		BY	
<p>SHELBY COUNTY AIRPORT SHELBYVILLE, ILLINOIS</p>					
<p>IL PROJ.: 2HQ-3615 A.I.P. PROJ.: 3-17-0083-B7</p>					
HEP No. 827-06APN	Plan No. R-705PNP-B-LT.DWG	Scale 1"=50' H., 1"=2' V.	Date 05/01/06	LAYOUT	CCC 05/01/06
				DRAWN	CCC 05/01/06
				REVIEWED	RAW 05/31/06
 <p>HANSON Hanson Professional Services Inc. 1525 South Sixth Street Springfield, Illinois 62705-2886 Chicago, Illinois</p>					
<p>OVERLAY RWY. & APN. INSTALL UNDERDRAINS</p> <p>PROPOSED TAXIWAY "B" LEFT UNDERDRAIN P&P STA. 100+00 TO STA. 103+25</p>					
<p>32</p> <p>32 of 33 sheets</p>					