

INDEX OF SHEETS

SHEET NO.	DESCRIPTION
1.	TITLE SHEET
2.	SUMMARY OF QUANTITIES OAKTON STREET FROM RIVER DRIVE TO GROSS POINT ROAD
3., 4., 5. & 6.	STANDARD TRAFFIC SIGNAL DESIGN DETAILS
7.	TRAFFIC SIGNAL MODIFICATION PLAN OAKTON STREET AT RIVER DRIVE
8.	CABLE PLAN, PHASE DESIGNATION DIAGRAM, EMERGENCY VEHICLE PREEMPTION SEQUENCE AND SCHEDULE OF QUANTITIES OAKTON STREET AT RIVER DRIVE
9.	TRAFFIC SIGNAL MODIFICATION PLAN OAKTON STREET AT LEHIGH AVENUE
10.	CABLE PLAN AND SCHEDULE OF QUANTITIES OAKTON STREET AT LEHIGH AVENUE
11.	SEQUENCE OF OPERATION, RAILROAD PREEMPTION SEQUENCE OF OPERATION AND EMERGENCY VEHICLE PREEMPTION SEQUENCE OAKTON STREET AT LEHIGH AVENUE
12.	TRAFFIC SIGNAL MODIFICATION AND REMOVAL PLAN OAKTON STREET AT AUSTIN AVENUE
13.	CABLE PLAN, PHASE DESIGNATION DIAGRAM AND SCHEDULE OF QUANTITIES OAKTON STREET AT AUSTIN AVENUE
14.	TRAFFIC SIGNAL MODIFICATION AND REMOVAL PLAN OAKTON STREET AT MENARD AVENUE
15.	CABLE PLAN, PHASE DESIGNATION DIAGRAM AND SCHEDULE OF QUANTITIES OAKTON STREET AT MENARD AVENUE
16.	TRAFFIC SIGNAL MODIFICATION AND REMOVAL PLAN OAKTON STREET AT GROSS POINT ROAD
17.	CABLE PLAN AND SCHEDULE OF QUANTITIES OAKTON STREET AT GROSS POINT ROAD
18. & 19.	INTERCONNECT PLAN OAKTON STREET FROM RIVER DRIVE TO GROSS POINT ROAD
20.	INTERCONNECT SCHEMATIC OAKTON STREET FROM RIVER DRIVE TO GROSS POINT ROAD

STATE OF ILLINOIS
DEPARTMENT OF TRANSPORTATION
DIVISION OF HIGHWAYS


PLANS FOR PROPOSED
FEDERAL AID HIGHWAY

SCALES { PLAN 1" = 20' AND 1" = 50'
 PROFILE HORIZ. N.A.
 PROFILE VERT. N.A.
 CROSS SECTION N.A.

DISTRICT 1
CONGESTION MITIGATION AIR QUALITY
FIBER OPTIC COMMUNICATIONS NETWORK
OAKTON STREET
FROM RIVER DRIVE TO GROSS POINT ROAD
F.A.U. ROUTE 1332
SECTION 2004-022TS
C-91-175-04

F.A.U. RTE.	SECTION	COUNTY	TOTAL SHEETS	SHEET NO.
1332	2004-022TS	COOK	20	1

STA. TO STA.
FED. ROAD DIST. NO. ILLINOIS FED. AID PROJECT
D-91-175-04

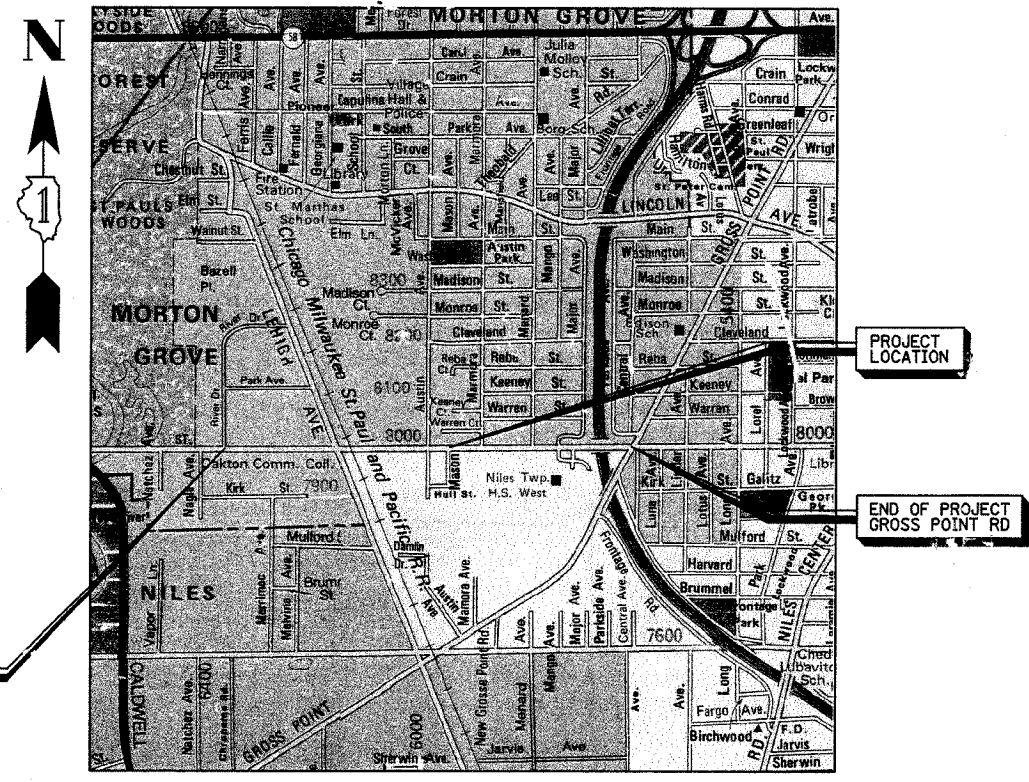

STANDARD DRAWINGS

701006 ⁰²	701011 ⁰¹	701101 ⁰¹	701301 ⁰²	702001 ⁰⁵
424001 ⁰⁴	720001 ⁰²	813001	814001	814006
857001	877001 ⁰²	877006	877011	878001 ⁰³
880001	880006	886001	805001	
701201	701316 ⁰⁴	701321 ⁰⁴	701406 ⁰⁴	701501
701502	701606 ⁰⁴	701601 ⁰⁴	701701 ⁰⁴	701801

NOTE: STANDARD DRAWINGS REQUIRED (CIRCLED).

CONTRACT NO. 62741


PREPARED BY: Terry Rammacher 3/14/05
 TRAFFIC ENGINEER DATE

STATE OF ILLINOIS
DEPARTMENT OF TRANSPORTATION
DIVISION OF HIGHWAYS

SUBMITTED March 14 20 05
Debra M. O'Keefe
 DEPUTY DIRECTOR OF HIGHWAYS, REGION ENGINEER

May 13, 20 05
Mike Hine
 ENGINEER OF DESIGN AND ENVIRONMENT

May 13, 20 05
Victor Mader
 DIRECTOR OF HIGHWAYS, CHIEF ENGINEER

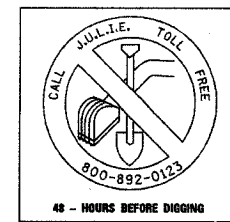

PRINTED BY THE AUTHORITY
OF THE STATE OF ILLINOIS

BUREAU OF TRAFFIC: TERRY RAMMACHER / DARYLE DREW 847-705-4420