


PRJ #	SECTION	COUNTY	TOTAL SHEETS	SHEET NO
CH	A47	LAKE	176	113
STA.	18+00	TO STA.	23+00	
03-00088-00-FP	LINKS	SURFACE TRANSPORTATION FUNDING		
CONTRACT NUMBER 83807				

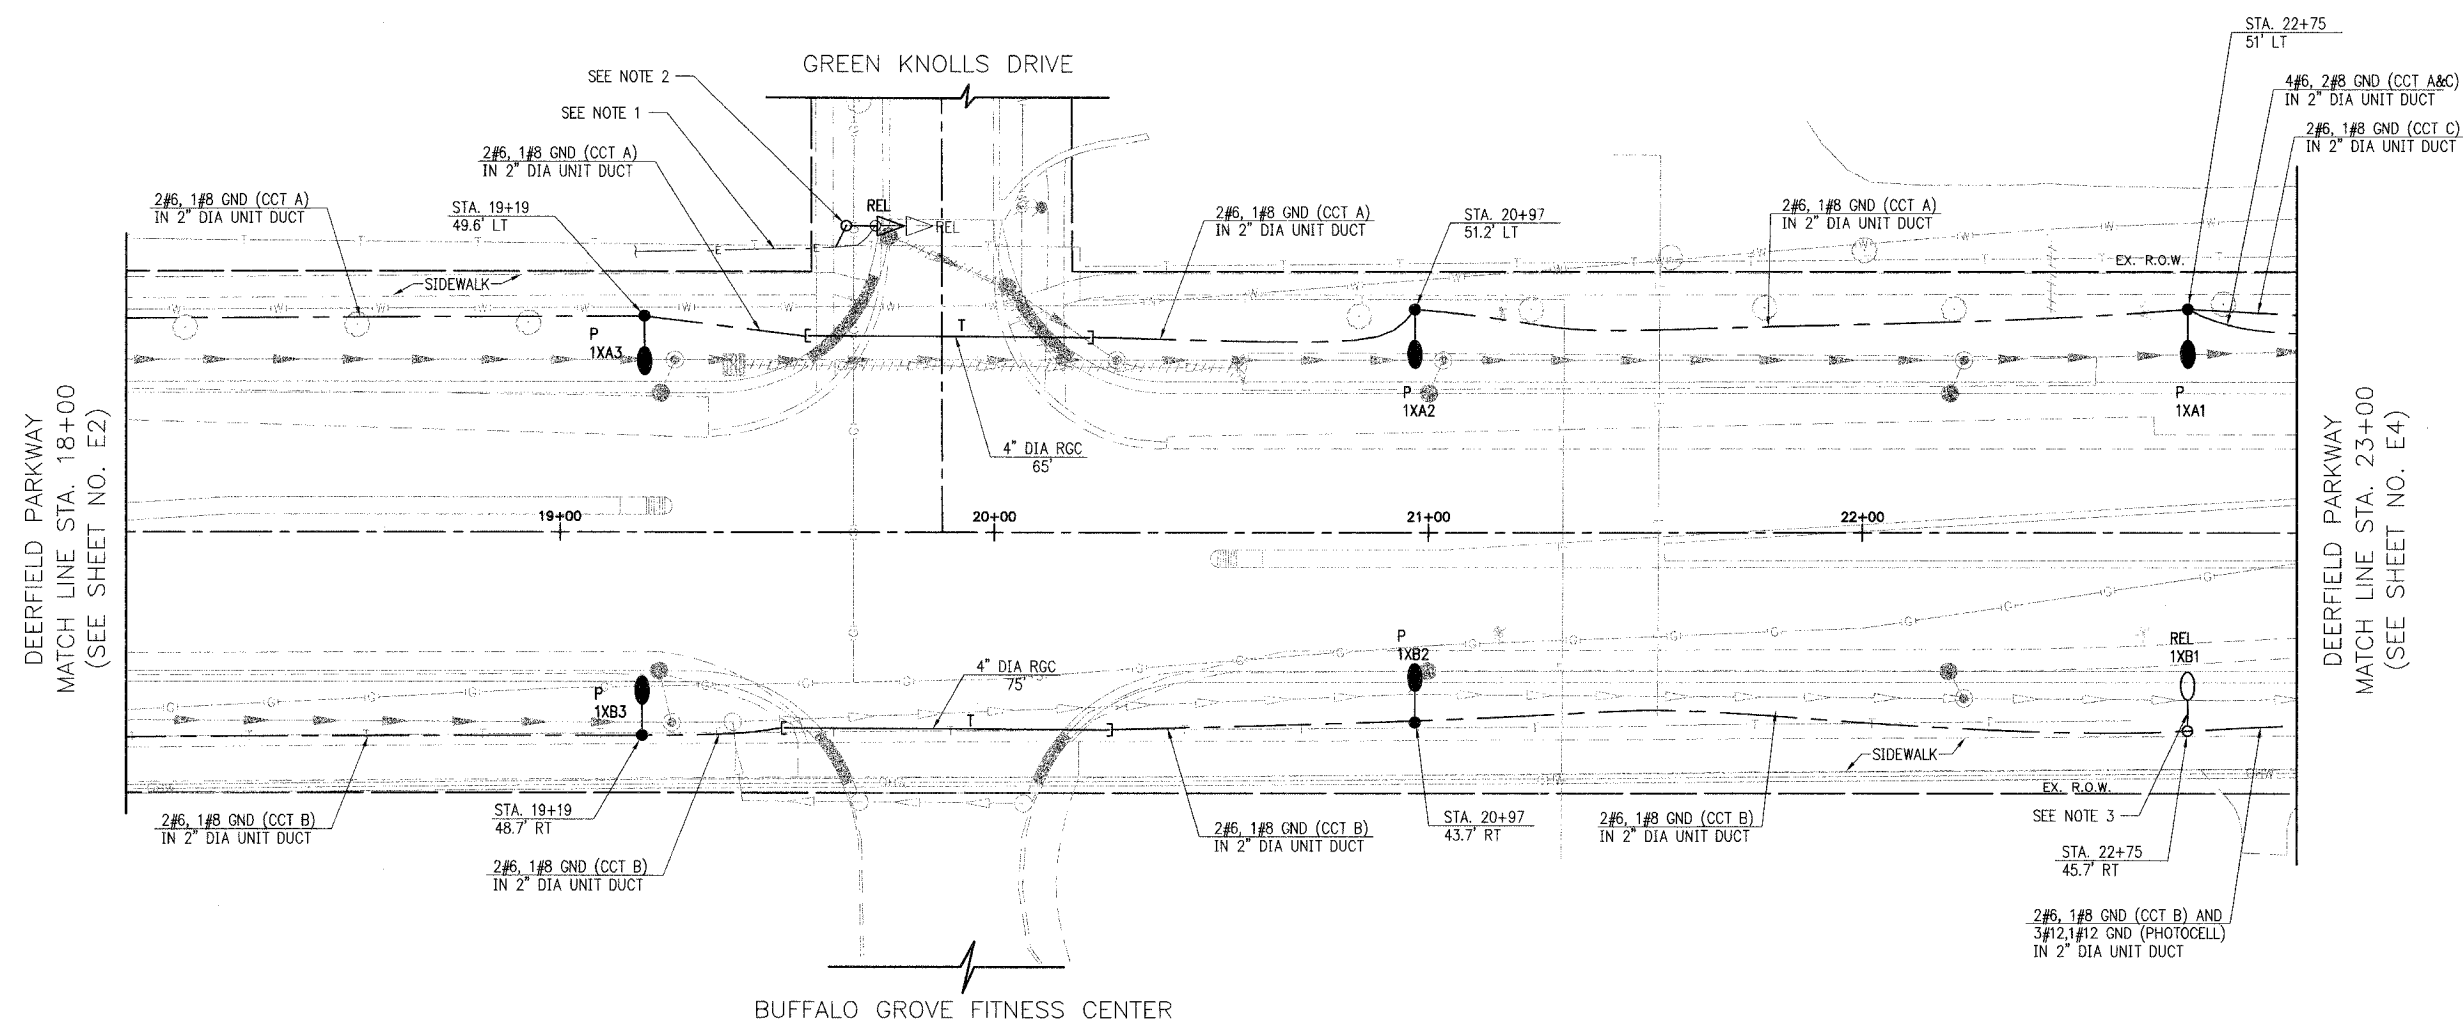

- NOTES:**
1. LOCATION OF EXISTING WIRING IS APPROXIMATE. EXACT LOCATION AND SOURCE SHALL BE FIELD DETERMINED.
 2. CONTRACTOR SHALL RELOCATE POLE AND EXTEND EXISTING WIRING TO RELOCATED POLE.
 3. RELOCATED POLE ALREADY HAS PHOTOCELL. CONTRACTOR SHALL WIRE PHOTOCELL TO 3#12, 1#12 GND FROM LIGHTING CONTROL CABINET.

E3 OF E22



REVISIONS	
NAME	DATE

VILLAGE OF BUFFALO GROVE

LIGHTING PLANS

DEERFIELD PARKWAY IMPROVEMENT

STA. 18+00 TO 23+00

SCALE IN FEET

DATE: 6/2/2005
DESIGNED BY: CMW
TECHNICIAN: LRS
CHECKED BY: MAR