


FILE #	SECTION	COUNTY	TOTAL SHEETS	SHEET NO
CH	A47	LAKE	176	115
STA. 27+50	TO STA. 33+00			
03-00088-00-FP	ILLINOIS	SURFACE TRANSPORTATION PLANNING		
CONTRACT NUMBER 83807				

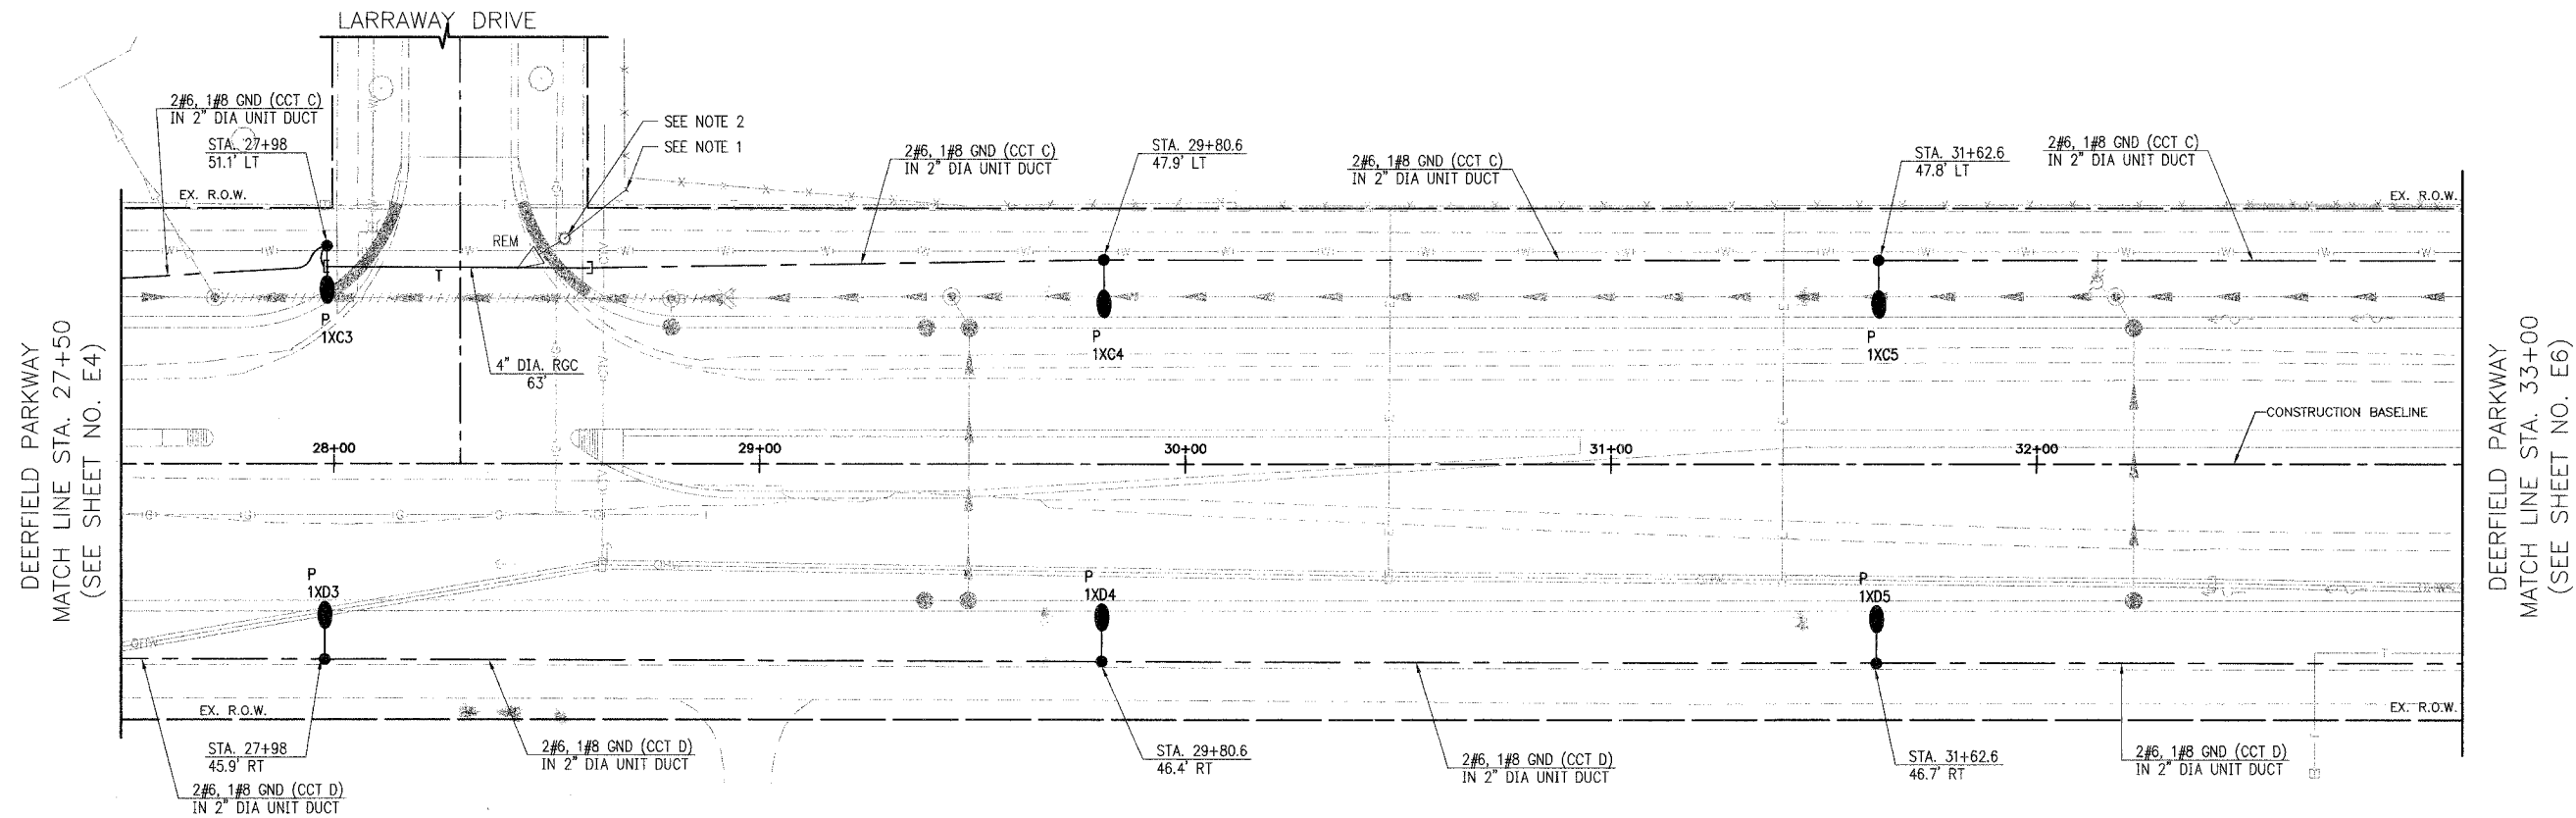

- NOTES:**
1. LOCATION OF EXISTING WIRING IS APPROXIMATE. EXACT LOCATION AND SOURCE SHALL BE FIELD DETERMINED. CONTRACTOR SHALL DISCONNECT EXISTING WIRING AT THE SOURCE AND ABANDON IN PLACE.
  2. CONTRACTOR SHALL REMOVE EXISTING LIGHTING UNIT AND RETURN UNIT TO THE VILLAGE.

E5 OF E22

VILLAGE OF BUFFALO GROVE

**LIGHTING PLANS**

DEERFIELD PARKWAY IMPROVEMENT

STA. 27+50 TO 33+00

DATE: 6/2/2005  
DESIGNED BY: CMW  
TECHNICIAN: LRS  
CHECKED BY: MAR

SCALE IN FEET



REVISIONS	
NAME	DATE