


REV. #	SECTION	COUNTY	TOTAL SHEETS	SHEET NO.
CH	A47	LAKE	176	117
STA. 38+00		TO STA. 43+00		
03-00088-00-PP		SURFACE TRANSPORTATION FUNDING		
CONTRACT NUMBER 83807				

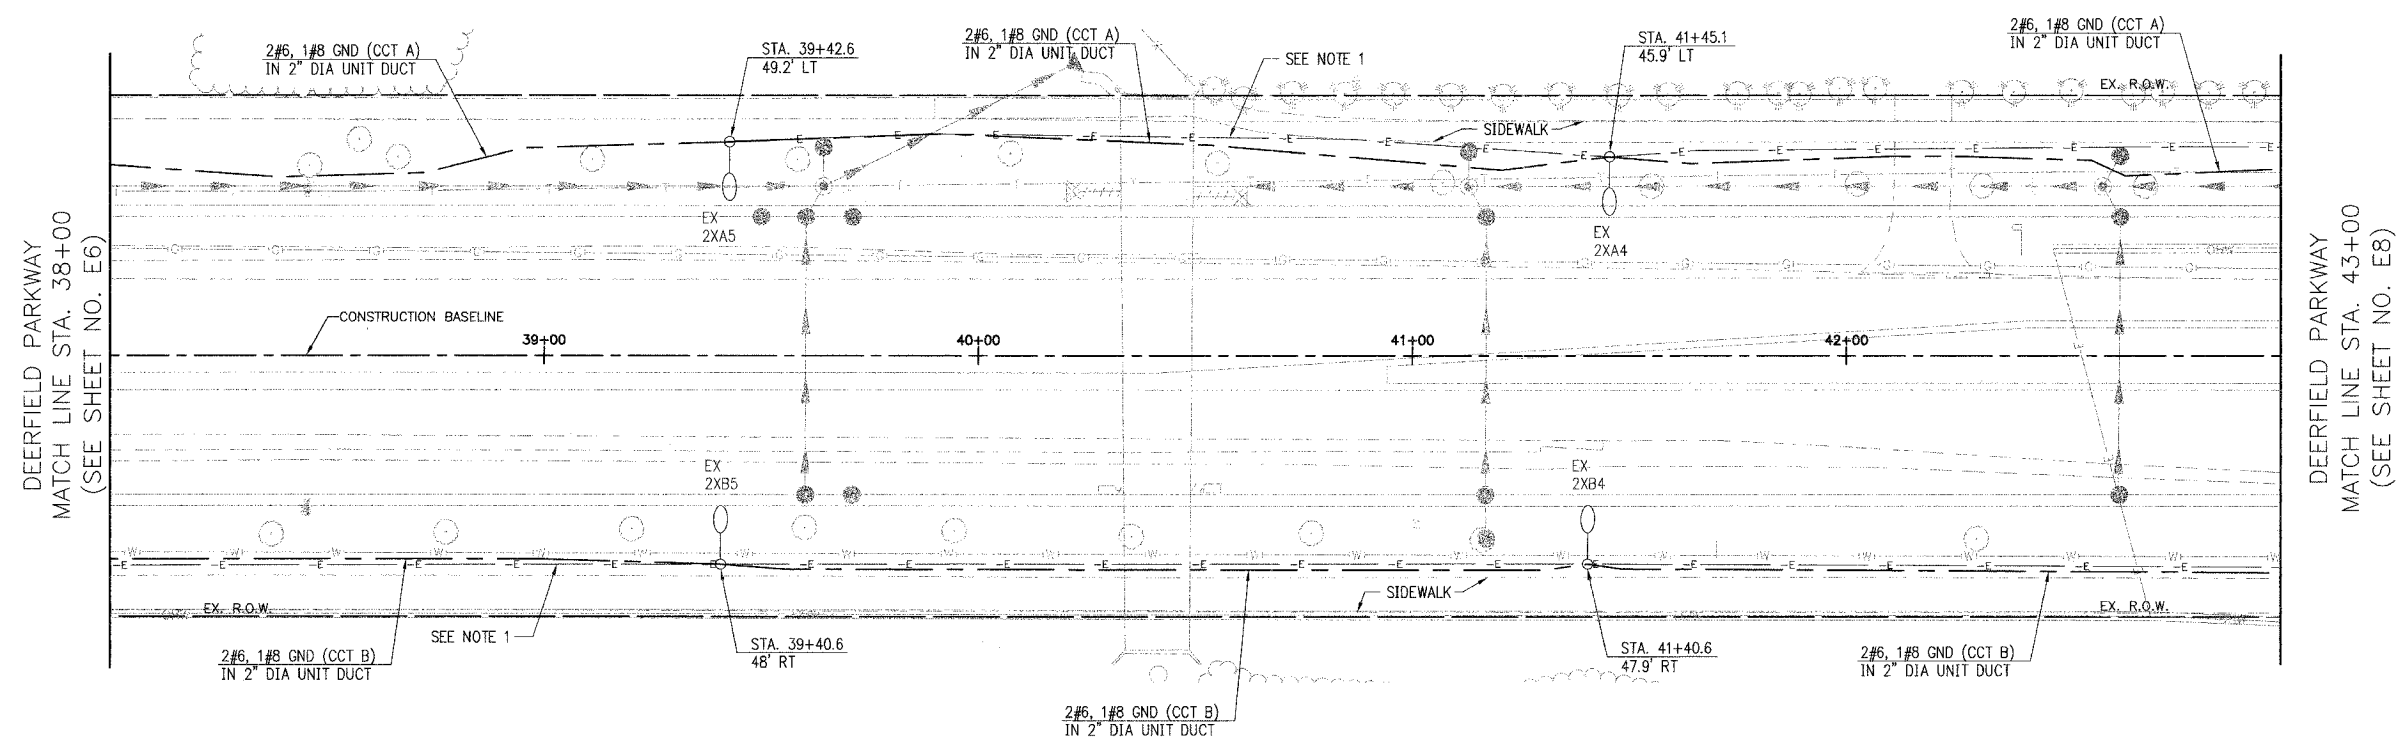

NOTES:
 1. LOCATION OF EXISTING WIRING IS APPROXIMATE. EXACT LOCATION AND SOURCE SHALL BE FIELD DETERMINED. CONTRACTOR SHALL DISCONNECT EXISTING WIRING AT THE SOURCE AND ABANDON IN PLACE.

E7 OF E22

VILLAGE OF BUFFALO GROVE
LIGHTING PLANS
 DEERFIELD PARKWAY IMPROVEMENT
 STA. 38+00 TO 43+00

DATE: 6/2/2005
 DESIGNED BY: CMW
 TECHNICIAN: LRS
 CHECKED BY: MAR

SCALE IN FEET



REVISIONS	
NAME	DATE