


ITEM #	SECTION	COUNTY	TOTAL SHEETS	SHEET NO.
CH	A47	LAKE	176	119
STA. 48+00		TO STA. 53+00		
03-0088-00-PP		LIROS	SURFACE TRANSPORTATION FUNDING	
CONTRACT NUMBER 53807				

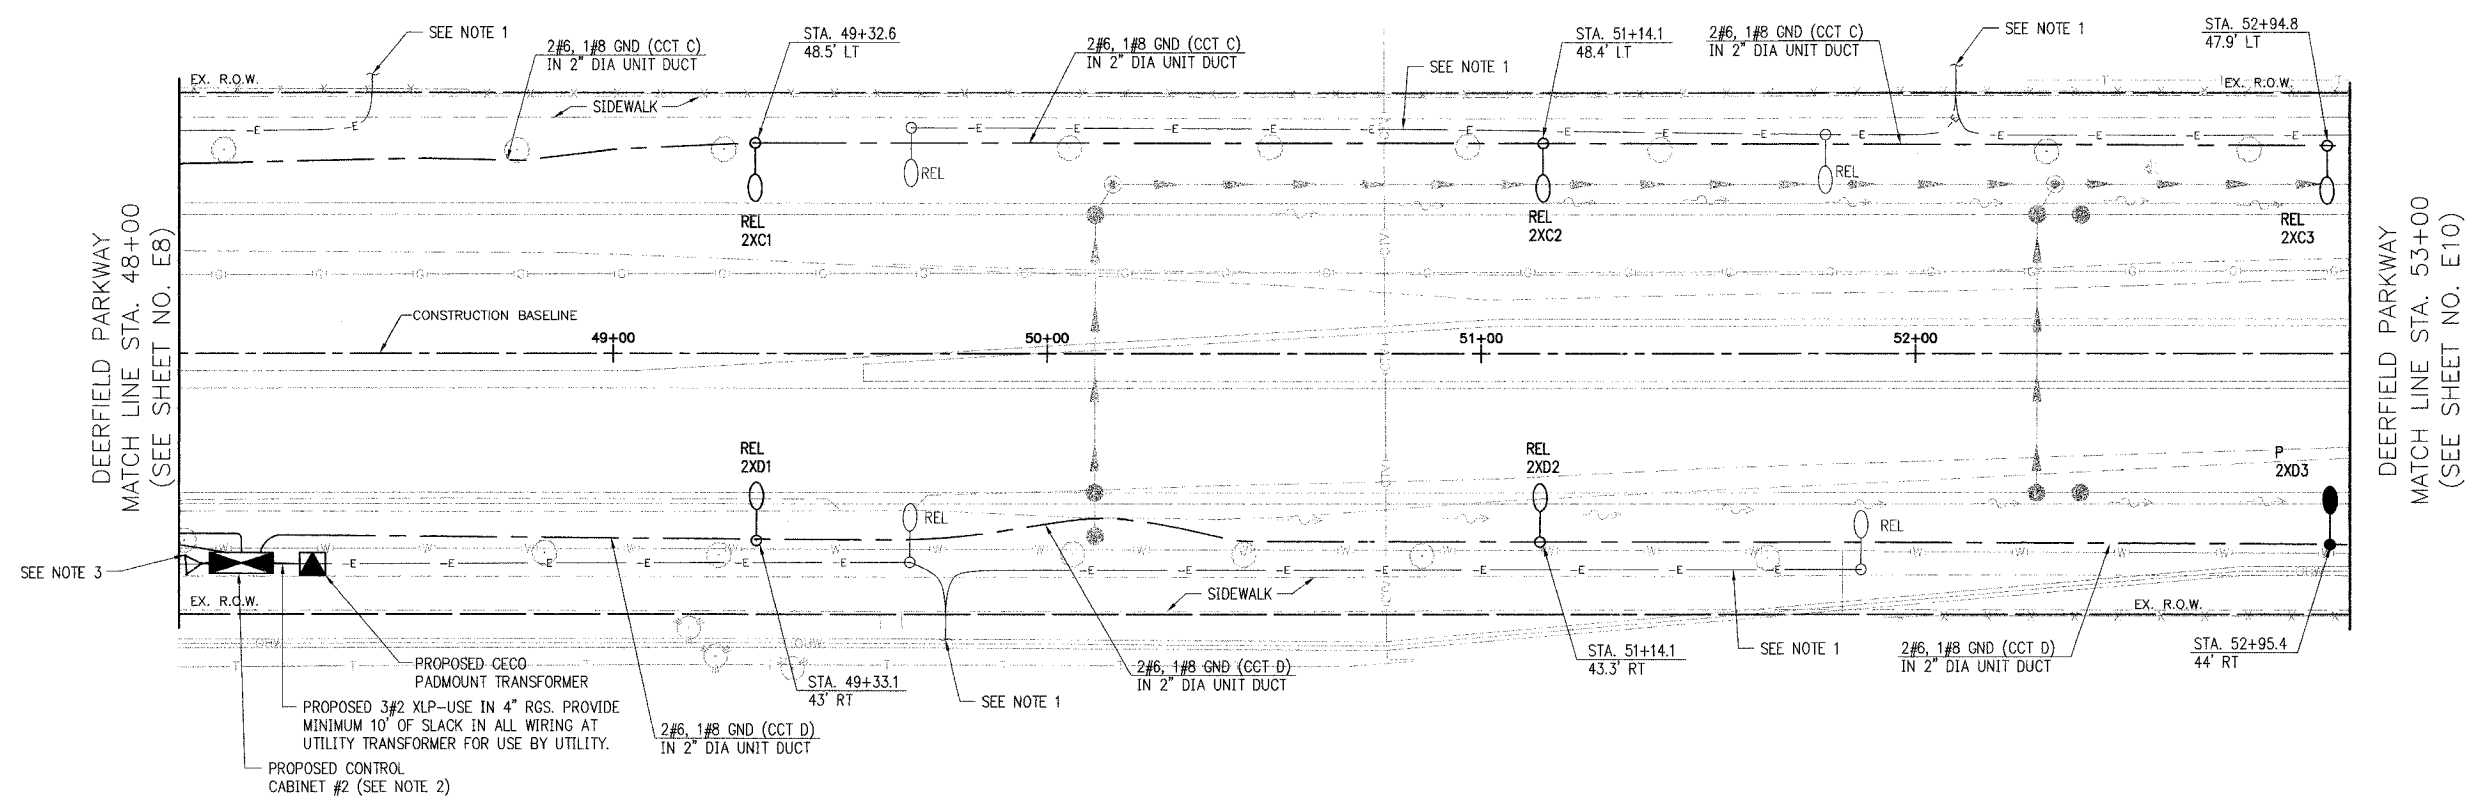

- NOTES:**
1. LOCATION OF EXISTING WIRING IS APPROXIMATE. EXACT LOCATION AND SOURCE SHALL BE FIELD DETERMINED. CONTRACTOR SHALL DISCONNECT EXISTING WIRING AT THE SOURCE AND ABANDON IN PLACE.
 2. SEE ELECTRICAL DETAILS SHEET 3 OF 4 FOR LIGHTING CONTROL CABINET DETAIL.
 3. SEE ELECTRICAL DETAILS SHEET 4 OF 4 FOR GROUND FIELD DETAIL.

E9 OF E22



REVISIONS	
NAME	DATE

VILLAGE OF BUFFALO GROVE

LIGHTING PLANS

DEERFIELD PARKWAY IMPROVEMENT

STA. 48+00 TO 53+00

SCALE IN FEET

DATE: 6/2/2005
DESIGNED BY: CMW
TECHNICIAN: JRH
CHECKED BY: MAR