


FILE#	SECTION	COUNTY	TOTAL SHEETS	SHEET NO
CH	A47	LAKE	176	120
STA.	53+00	TO STA.	57+00	
03-00088-00-PP	BLDG	SURFACE TRANSPORTATION FUNDING		
CONTRACT NUMBER 83607				

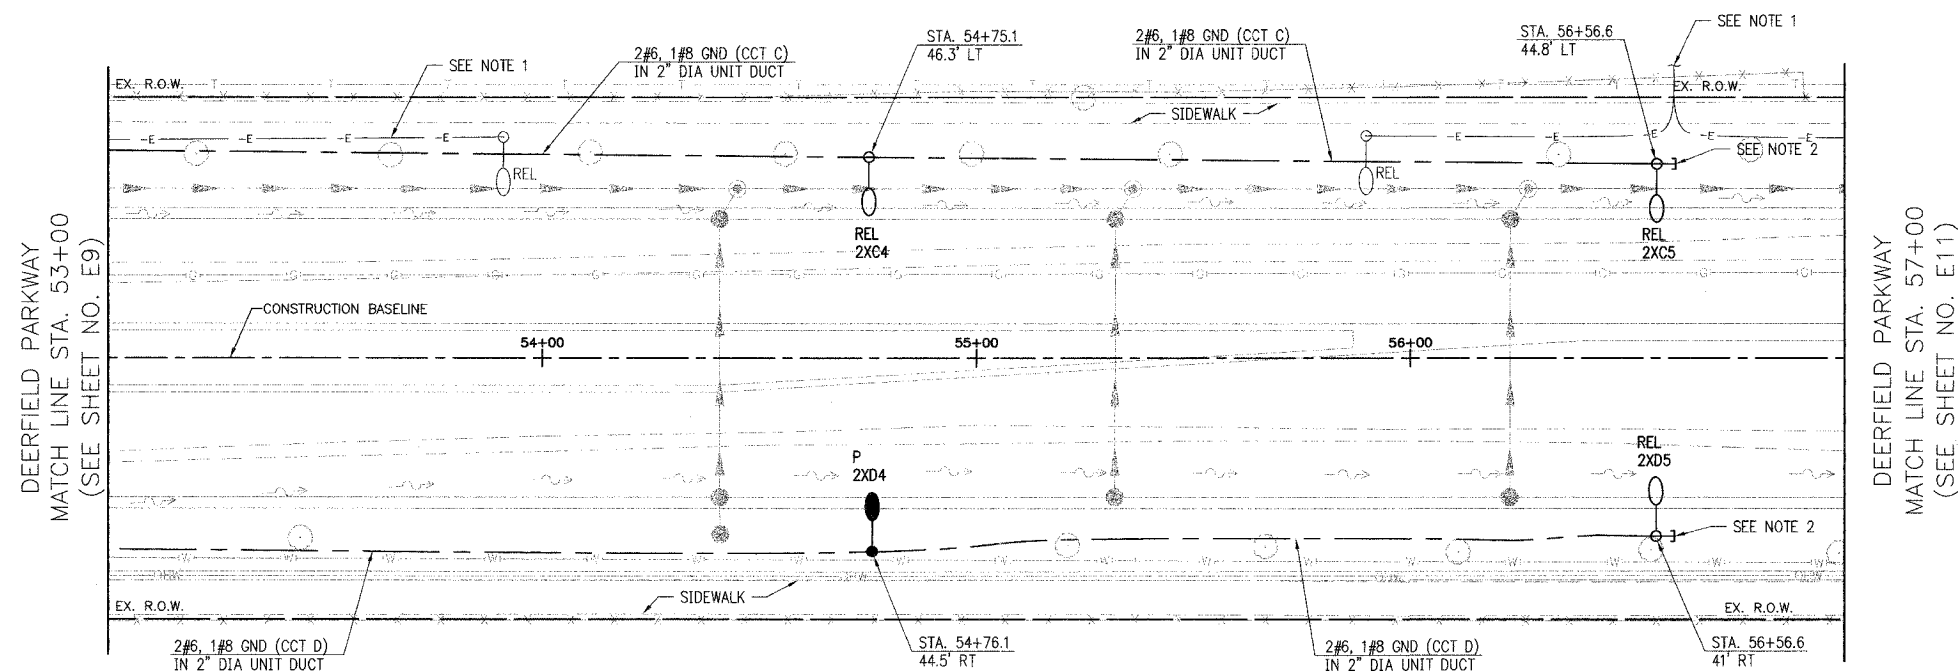

NOTES:

1. LOCATION OF EXISTING WIRING IS APPROXIMATE. EXACT LOCATION AND SOURCE SHALL BE FIELD DETERMINED. CONTRACTOR SHALL DISCONNECT EXISTING WIRING AT THE SOURCE AND ABANDON IN PLACE.
2. CONTRACTOR SHALL STUB AND CAP 2" RGC CONDUIT 2'-0" BEYOND LIGHT POLE FOUNDATION FOR FUTURE USE.

E10 OF E22

VILLAGE OF BUFFALO GROVE

LIGHTING PLANS
DEERFIELD PARKWAY IMPROVEMENT
STA. 53+00 TO 57+00



DATE: 6/2/2005
DESIGNED BY: CMW
TECHNICIAN: LRS
CHECKED BY: MAR



REVISIONS	
NAME	DATE