


REV #	SECTION	COUNTY	TOTAL SHEETS	SHEET NO
CH	A47	LAKE	176	122
STA. 62+25		TO STA. 67+00		
03-00088-00-FP		ILLINOIS	SURFACE TRANSPORTATION FUNDING	
CONTRACT NUMBER 83807				

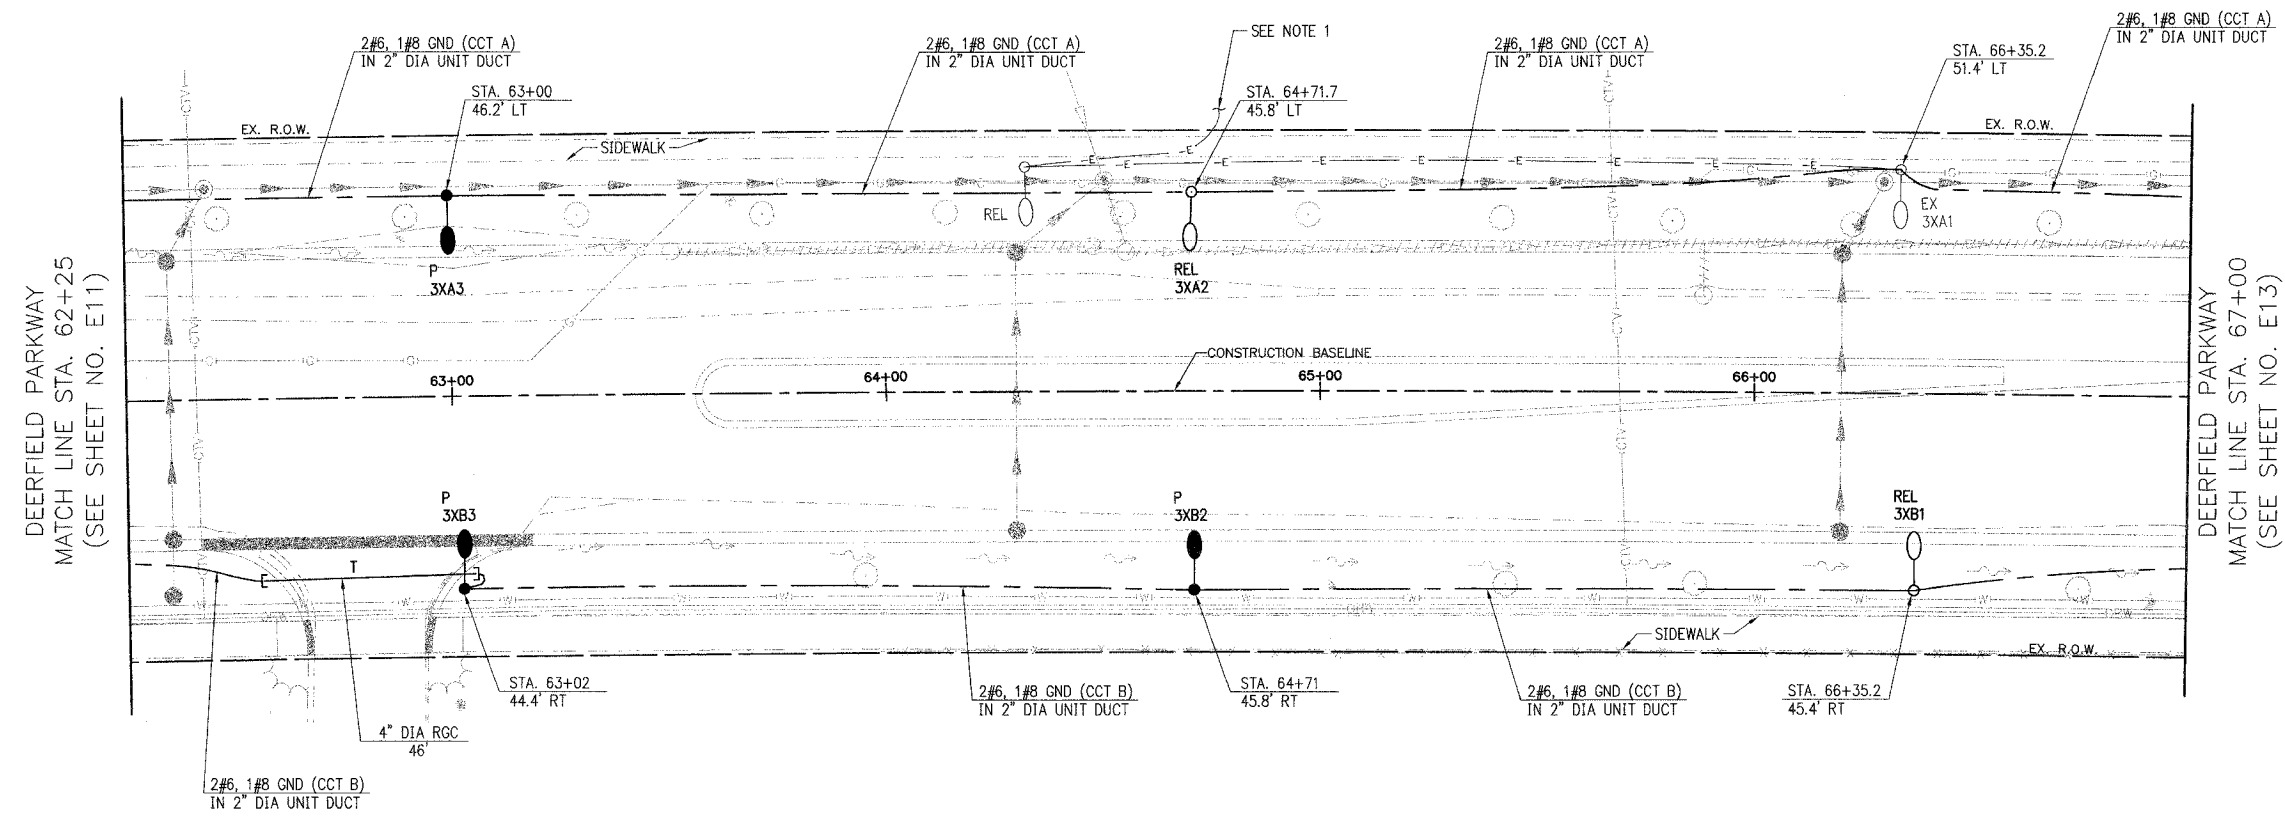

NOTES:
 1. LOCATION OF EXISTING WIRING IS APPROXIMATE. EXACT LOCATION AND SOURCE SHALL BE FIELD DETERMINED. CONTRACTOR SHALL DISCONNECT EXISTING WIRING AT THE SOURCE AND ABANDON IN PLACE.

E12 OF E22

VILLAGE OF BUFFALO GROVE
LIGHTING PLANS
 DEERFIELD PARKWAY IMPROVEMENT
 STA. 62+25 TO 67+00

DATE: 6/2/2005
 DESIGNED BY: CMW
 TECHNICIAN: LRS
 CHECKED BY: MAR



REVISIONS	
NAME	DATE

