


PROJECT	SECTION	COUNTY	TOTAL SHEETS	SHEET NO.
CH	A47	LAKE	176	124
STA. 72+00	TO STA. 77+00			
03-00088-00-FP	LINE	SURFACE TRANSPORTATION FUNDING		
CONTRACT NUMBER 83807				

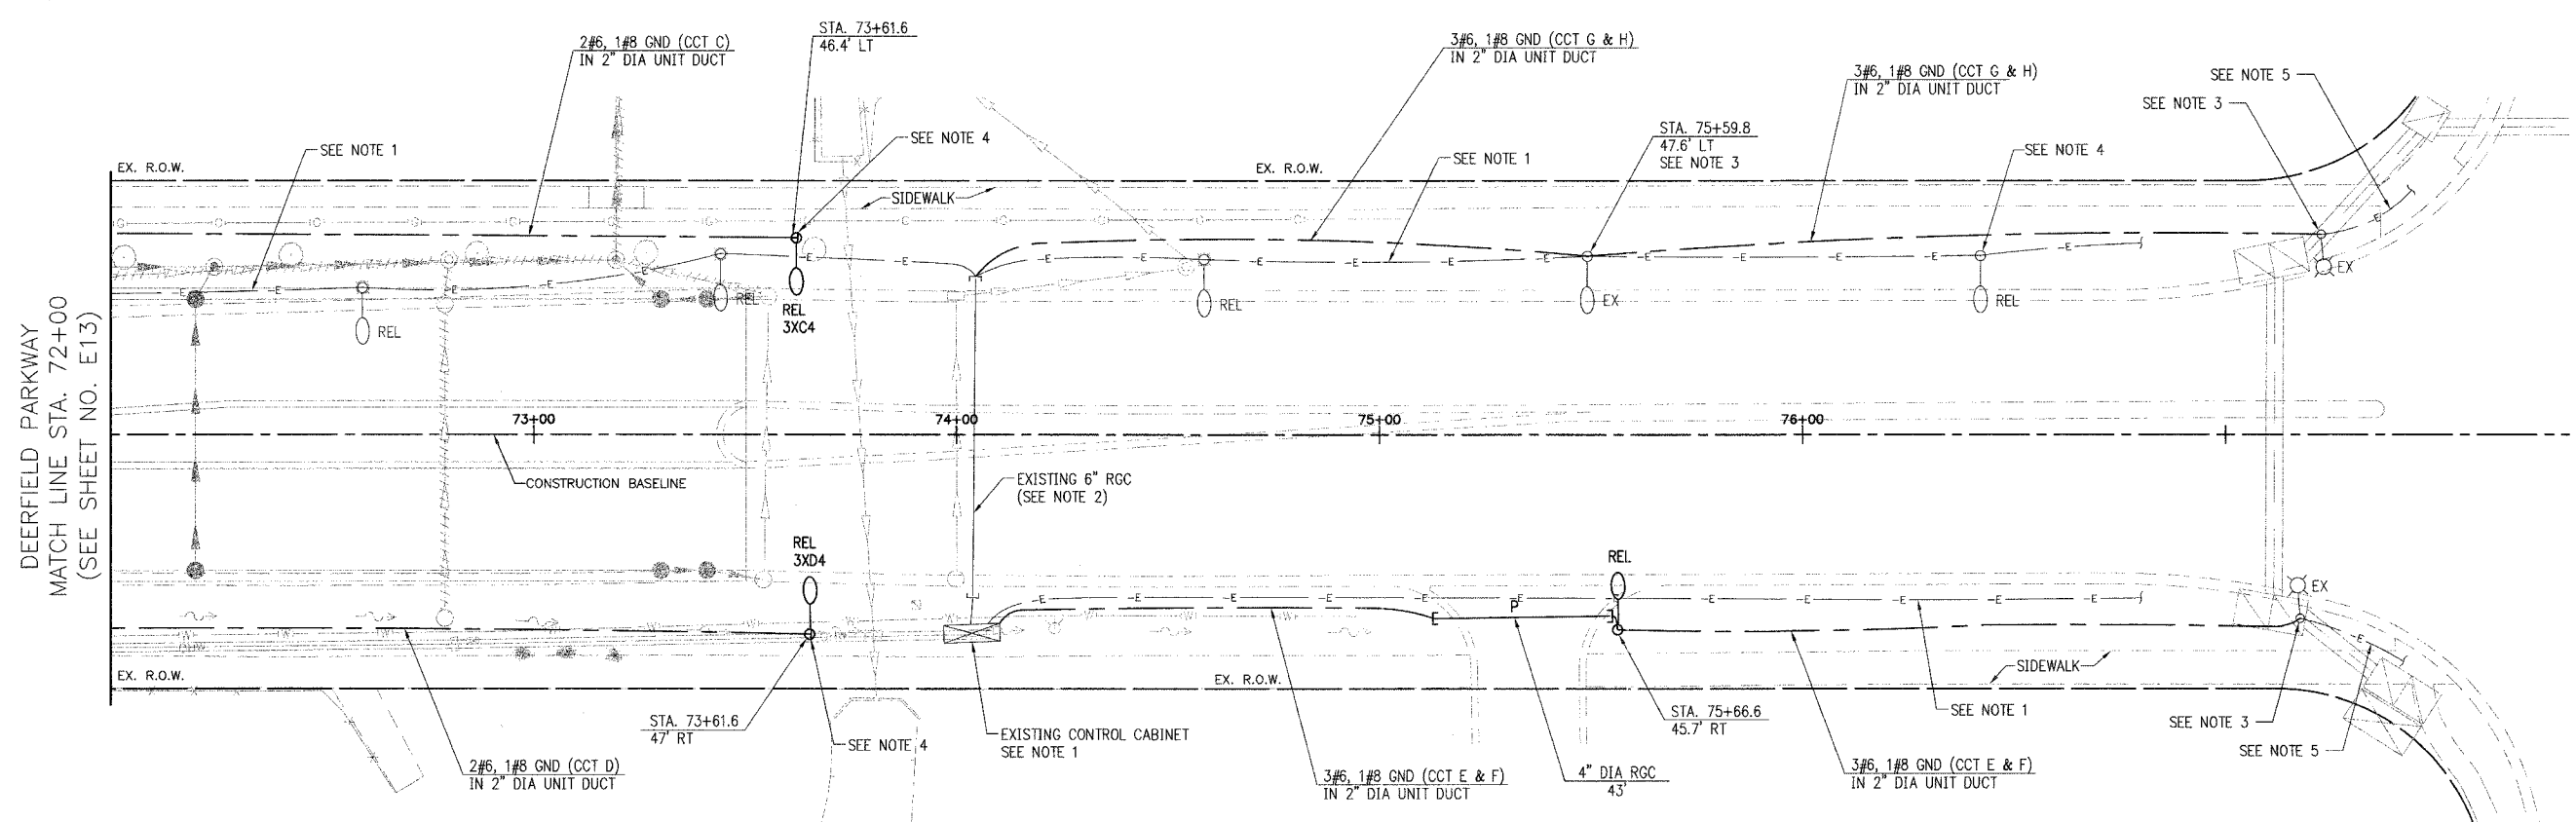

DEERFIELD PARKWAY  
MATCH LINE STA. 72+00  
(SEE SHEET NO. E13)

WEILAND ROAD

- NOTES:**
1. LOCATION OF EXISTING WIRING IS APPROXIMATE. EXACT LOCATION SHALL BE FIELD DETERMINED. CONTRACTOR SHALL DISCONNECT EXISTING CONDUCTORS AT EXISTING CONTROL CABINET. EXISTING CONDUCTORS BEING REPLACED SHALL BE REMOVED FROM CONTROL CABINET.
  2. CONTRACTOR SHALL REMOVE EXISTING WIRING FROM THE 6" RGC AND PULL IN NEW WIRING/UNIT DUCT.
  3. CONTRACTOR SHALL REMOVE EXISTING CONDUIT AND CABLE IDENTIFIED IN NOTE 1 FROM THE WEST TO THE COMBINATION POLES AT WEILAND AVE AND REPLACE WITH PROPOSED WIRING AS SHOWN AND SPLICE TO EXISTING CONDUCTORS IN THE COMBINATION POLES.
  4. CONTRACTOR SHALL STUB AND CAP 2" RGC CONDUIT 2'-0" BEYOND LIGHT POLE FOUNDATION FOR FUTURE USE.
  5. EXISTING CONDUIT AND WIRING TO REMAIN.

E14 OF E22

VILLAGE OF BUFFALO GROVE  
**LIGHTING PLANS**  
DEERFIELD PARKWAY IMPROVEMENT  
STA. 72+00 TO 77+00

DATE: 6/2/2005  
DESIGNED BY: CMW  
TECHNICIAN: JRH  
CHECKED BY: MAR



REVISIONS	
NAME	DATE

