


FILE	SECTION	COUNTY	TOTAL SHEETS	SHEET NO.
CH	A47	LAKE	176	125
STA.	121+00	TO STA.	127+00	
03-00088-00-FP	LANDS	SURFACE TRANSPORTATION FUNDING		
CONTRACT NUMBER 83807				

BUFFALO GROVE ROAD
MATCH LINE STA. 121+00
(SEE SHEET NO. E6)

BUFFALO GROVE ROAD
MATCH LINE STA. 127+00
(SEE SHEET NO. E16)

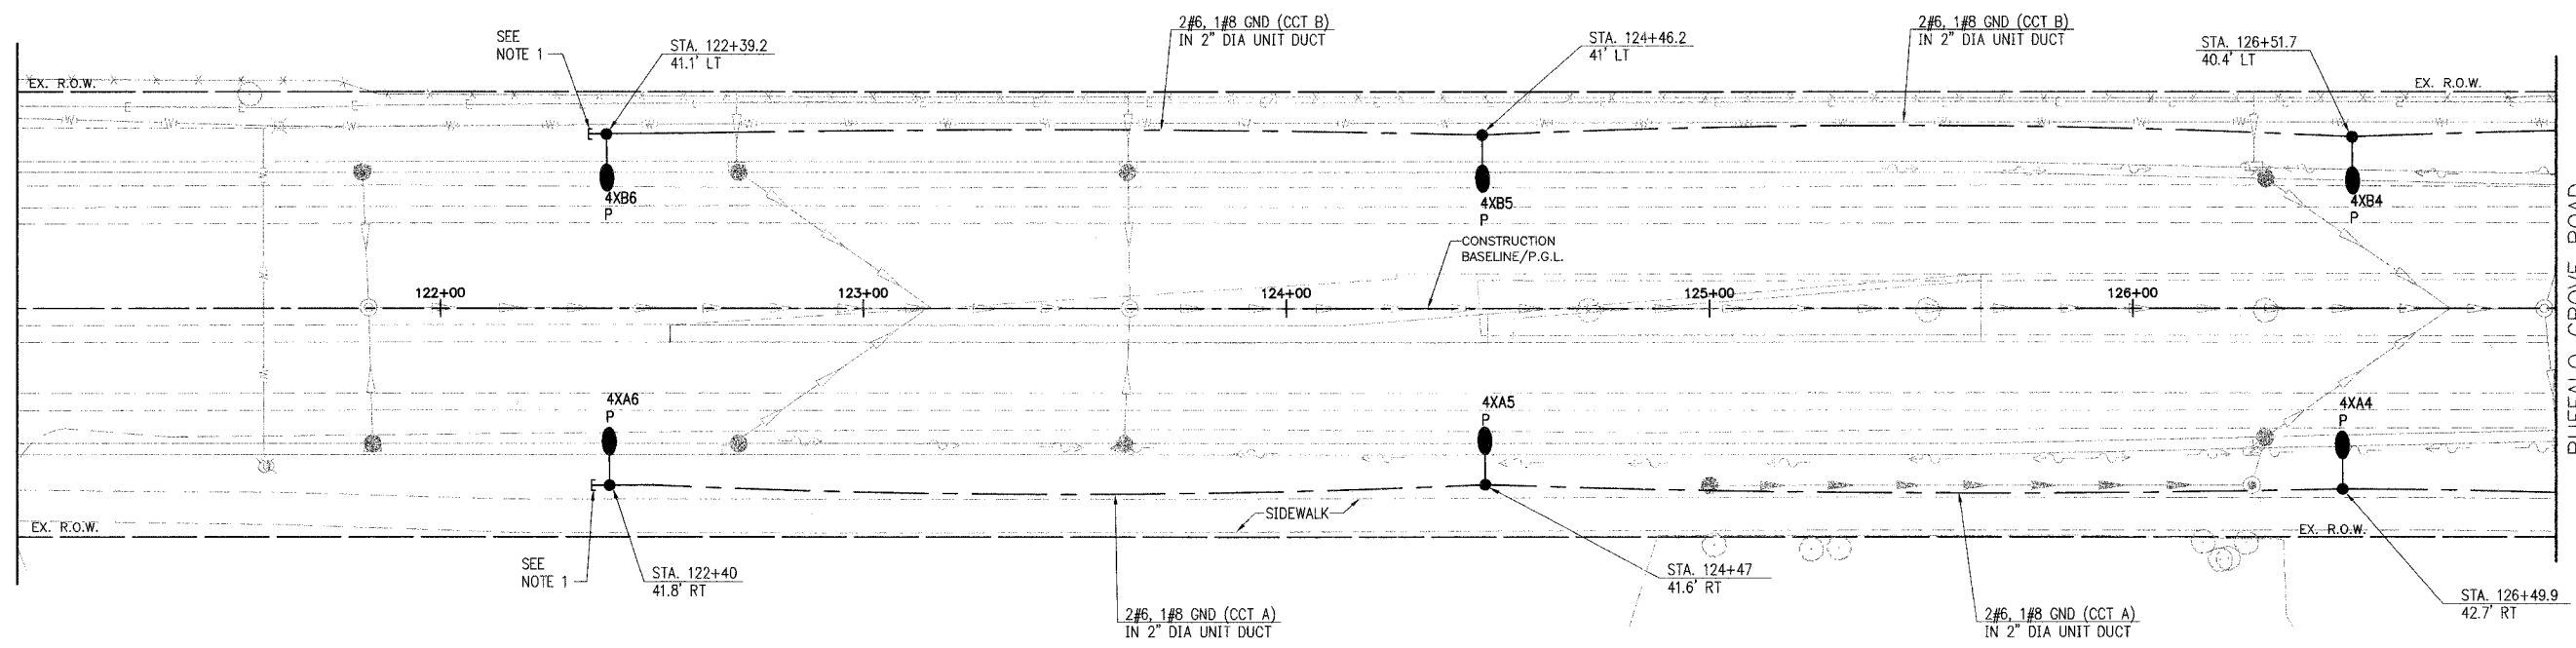

NOTE:
1. CONTRACTOR SHALL STUB AND CAP 2\"/>

E15 OF E22



REVISIONS	
NAME	DATE

VILLAGE OF BUFFALO GROVE
LIGHTING PLANS
BUFFALO GROVE ROAD IMPROVEMENT
STA. 121+00 TO 127+00

DATE: 6/2/2005
DESIGNED BY: CMW
TECHNICIAN: EJB
CHECKED BY: MAR

SCALE IN FEET
20 0 20