


CH	SECTION	COUNTY	TOTAL SHEETS	SHEET NO.
CH	A47	LAKE	176	126
STA. 127+00		TO STA. 132+50		
03-00088-00-FP		ILLINOIS		SURFACE TRANSPORTATION FUNDING
CONTRACT NUMBER 83807				

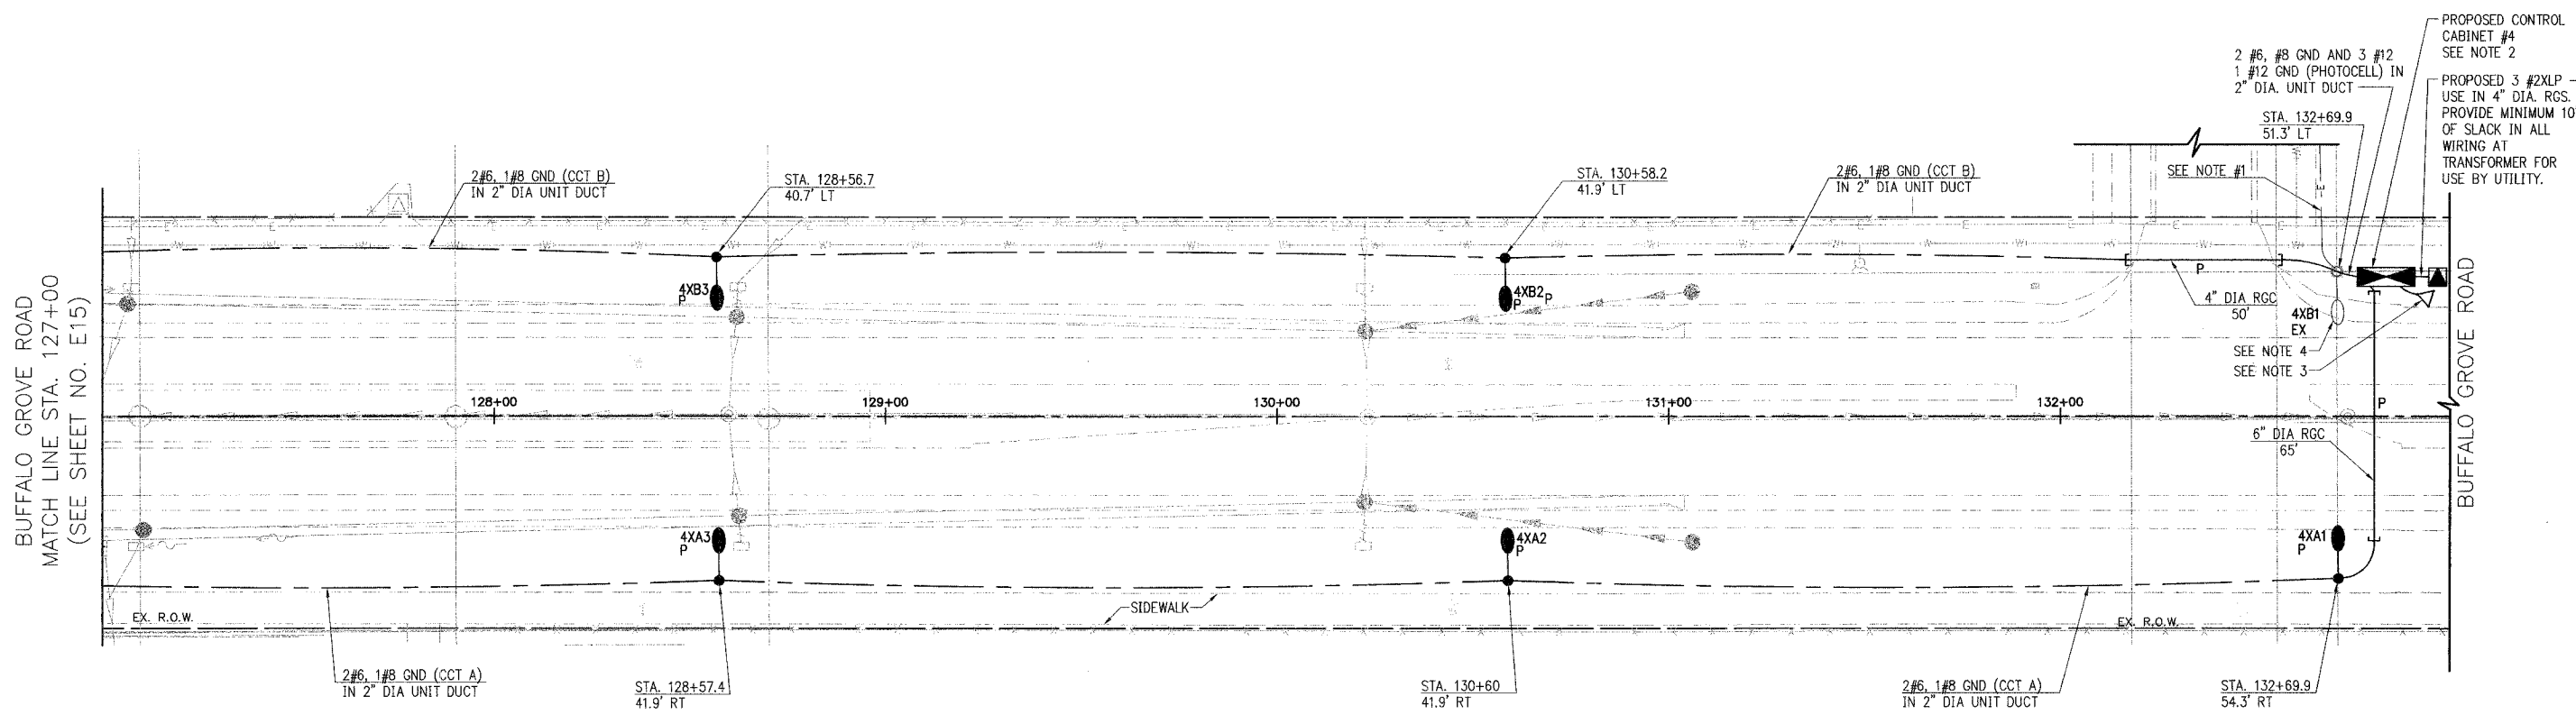

- NOTES:**
1. LOCATION OF EXISTING WIRING IS APPROXIMATE. EXACT LOCATION AND SOURCE SHALL BE FIELD DETERMINED. CONTRACTOR SHALL DISCONNECT EXISTING WIRING AT THE SOURCE AND ABANDON IN PLACE.
  2. SEE ELECTRICAL DETAILS SHEET 3 OF 4 FOR LIGHTING CONTROL CABINET DETAIL.
  3. SEE ELECTRICAL DETAILS SHEET 4 OF 4 FOR GROUND FIELD DETAIL.
  4. EXISTING POLE ALREADY HAS PHOTOCELL. CONTRACTOR SHALL WIRE PHOTOCELL TO 3#12, 1#12 GND FROM LIGHTING CONTROL CABINET.

E16 OF E22



REVISIONS	
NAME	DATE

VILLAGE OF BUFFALO GROVE

**LIGHTING PLANS**

BUFFALO GROVE ROAD IMPROVEMENT  
STA. 127+00 TO 133+00

SCALE IN FEET

DATE: 6/2/2005  
DESIGNED BY: CMW  
TECHNICIAN: EJB  
CHECKED BY: MAR