


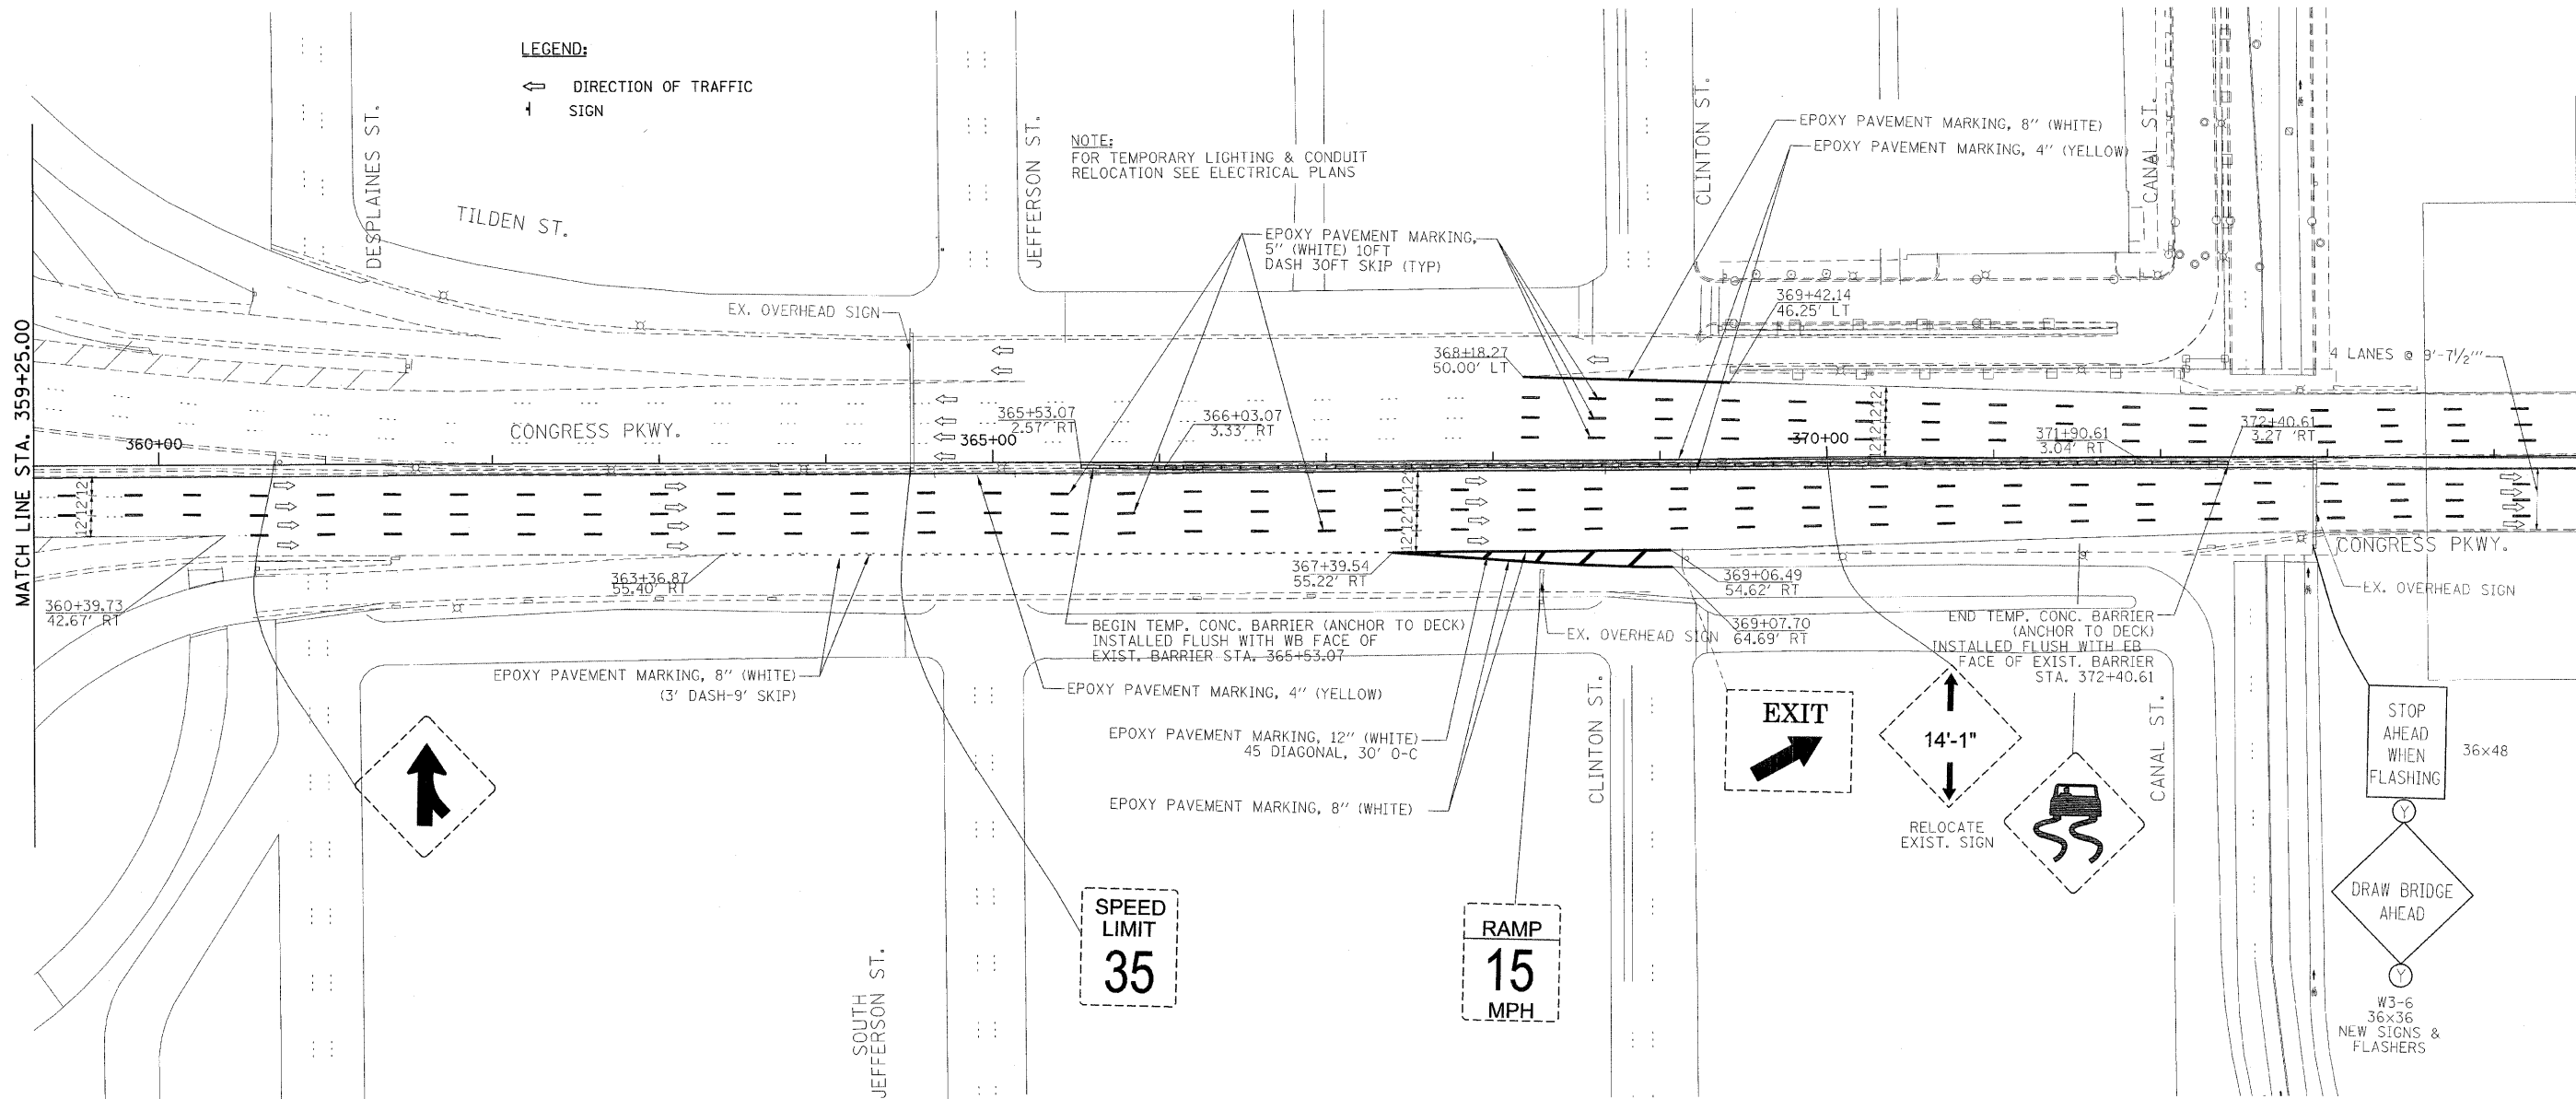

**LEGEND:**

- ↔ DIRECTION OF TRAFFIC
- + SIGN

NOTE:  
FOR TEMPORARY LIGHTING & CONDUIT  
RELOCATION SEE ELECTRICAL PLANS



**PB Americas, Inc.**  
230 WEST MONROE STREET,  
SUITE 900  
CHICAGO, IL. 60606

USER NAME = #USER#  
FILE NAME = #FILENAME#  
PLOT SCALE = #SCALE#  
PLOT DATE = 5/7/2009

DESIGNED - DM  
DRAWN - MS  
CHECKED - DS  
DATE - 5/08/09

REVISED -  
REVISED -  
REVISED -  
REVISED -

**STATE OF ILLINOIS  
DEPARTMENT OF TRANSPORTATION**

**CONGRESS PARKWAY OVER SOUTH BRANCH OF THE CHICAGO RIVER  
SUGGESTED STAGES OF CONSTRUCTION AND  
TRAFFIC CONTROL PLANS - WINTER LANE CONFIGURATION**

SCALE: 1" = 50' SHEET NO. 38 OF 83 SHEETS STA. 377+01.00 TO STA. 382+45.28

F.A.P.  
RTE. 389

SECTION  
2424-2B-R

COUNTY  
COOK

TOTAL SHEETS  
398

SHEET NO.  
38

CONTRACT NO. 60D61

FED. ROAD DIST. NO. 1 ILLINOIS FED. AID PROJECT