
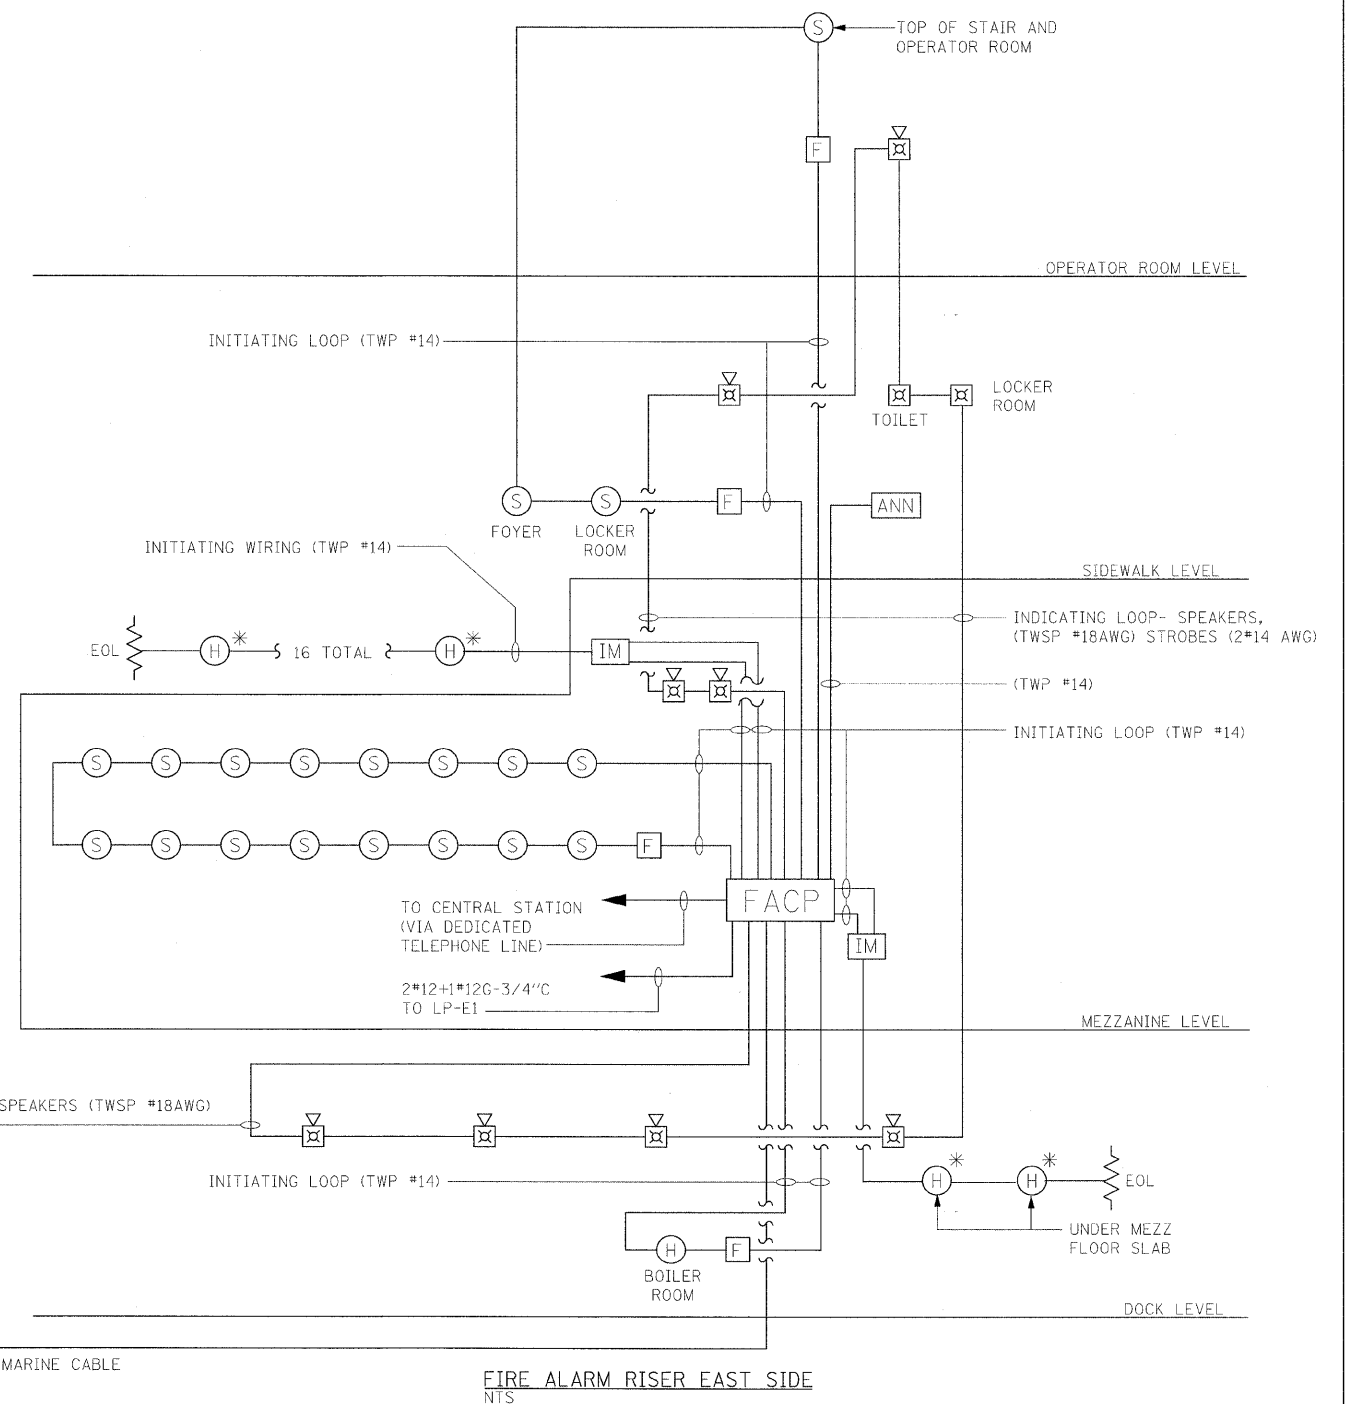


- NOTES:**
- FOR ELECTRICAL SYMBOLS AND ABBREVIATIONS SEE DWG E-04, E-05 AND E-06.
 - FOR GENERAL NOTES SEE DWGS E-02 AND E-03.

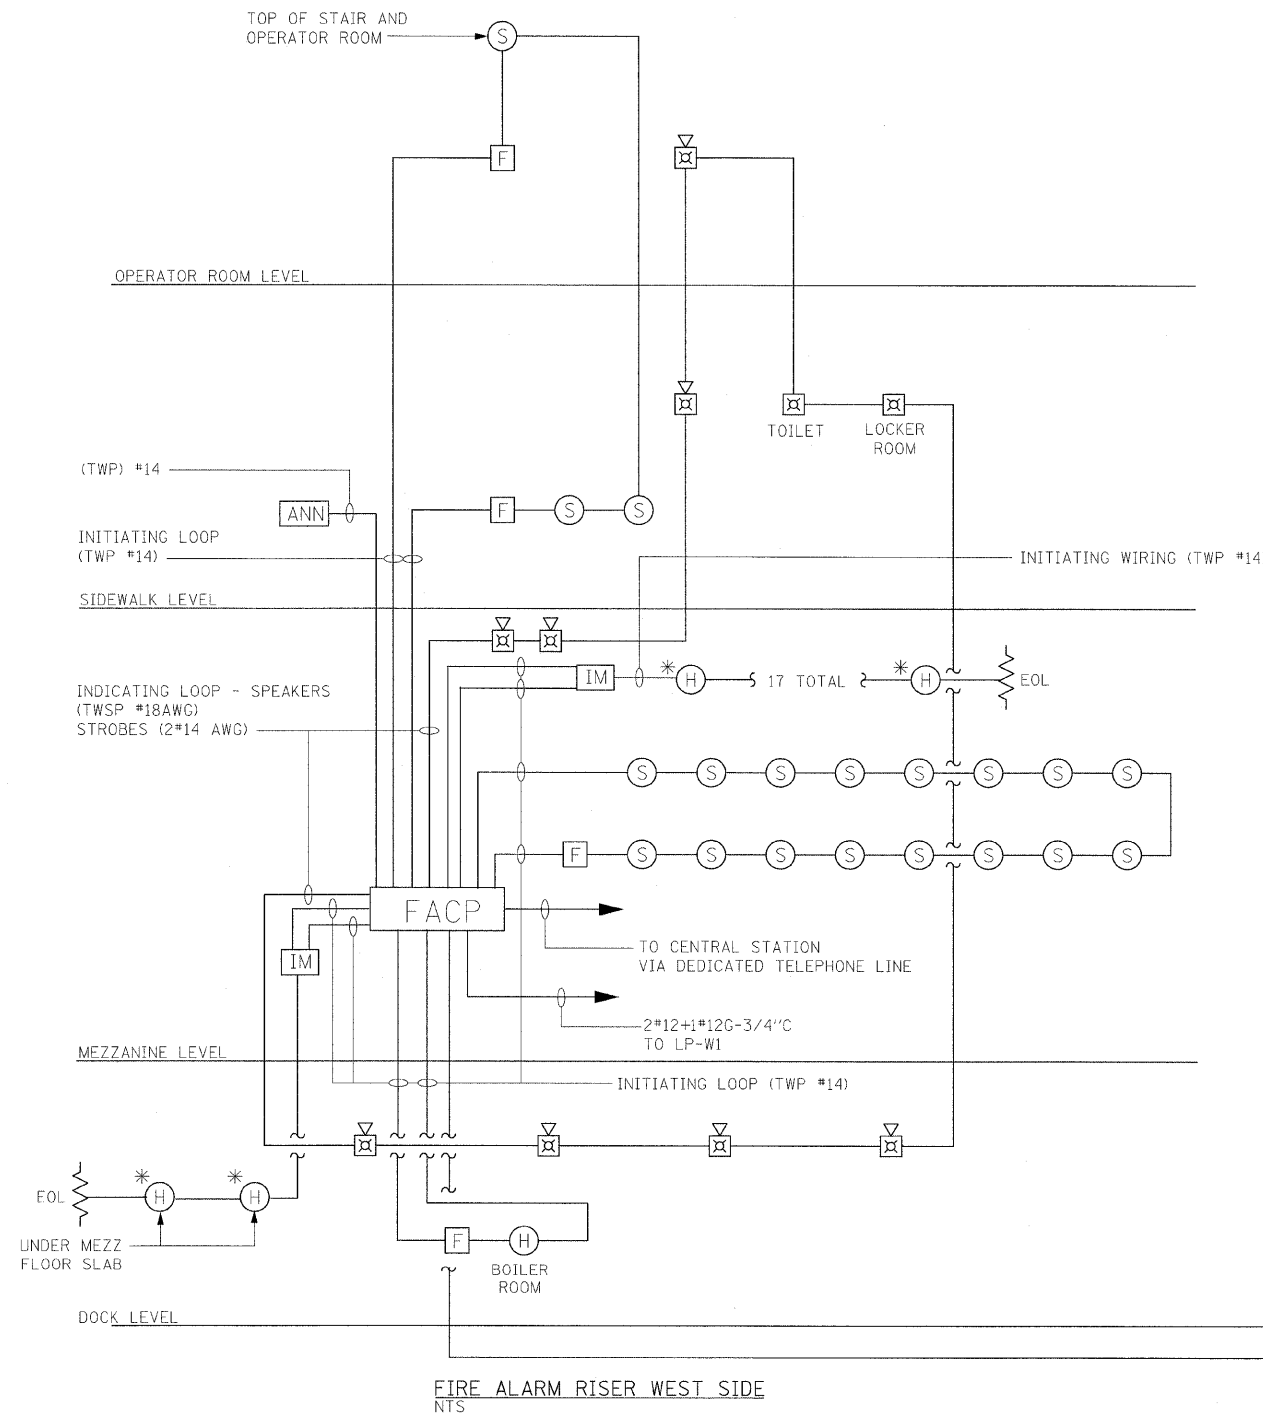

H* NON-ADDRESSABLE HEAT DETECTOR

PB Americas, Inc. 230 WEST MONROE STREET, SUITE 900 CHICAGO, IL. 60606	USER NAME = sharma	DESIGNED - R. GODULIAS	REVISED -	STATE OF ILLINOIS DEPARTMENT OF TRANSPORTATION	EAST AND WEST FIRE ALARM RISER DIAGRAM	F.A.P. RTE.	SECTION	COUNTY	TOTAL SHEETS	SHEET NO.
	FILE NAME = D16@d61-shr-elc-16.dgn	DRAWN - S. SHARMA	REVISED -			389	2424-2B-R	COOK	398	287
	PLOT SCALE = NONE	CHECKED - M. INTATANO	REVISED -			CONTRACT NO. 60D61				
	PLOT DATE = 5/7/2009	DATE - MAY 8, 2009	REVISED -			FED. ROAD DIST. NO. 1 ILLINOIS FED. AID PROJECT				
SCALE: AS SHOWN SHEET NO. E-16 OF E-125 SHEETS STA. 379+06.09 TO STA. 382+45.28										