




NOTES:

1. FOR ELECTRICAL SYMBOLS AND ABBREVIATIONS SEE DWGS E-04, E-05 AND E-06.
2. FOR GENERAL NOTES SEE DWGS E-02 AND E-03.
3. FOR FIRE ALARM RISER DIAGRAM, SEE DWG E-16.
4. FOR CCTV RISER DIAGRAM, SEE DWG E-17.
5. NEMA 4X STAINLESS STEEL LOCKABLE CABINET 48"x36"x10". SIZE TO BE DETERMINED BY THE DEPARTMENT TIE-IN REQUIREMENTS.
6. FOR CCTV 96 PORT WALL MOUNTED PATCH PANEL ELEVATIONS SEE DWG E-54.

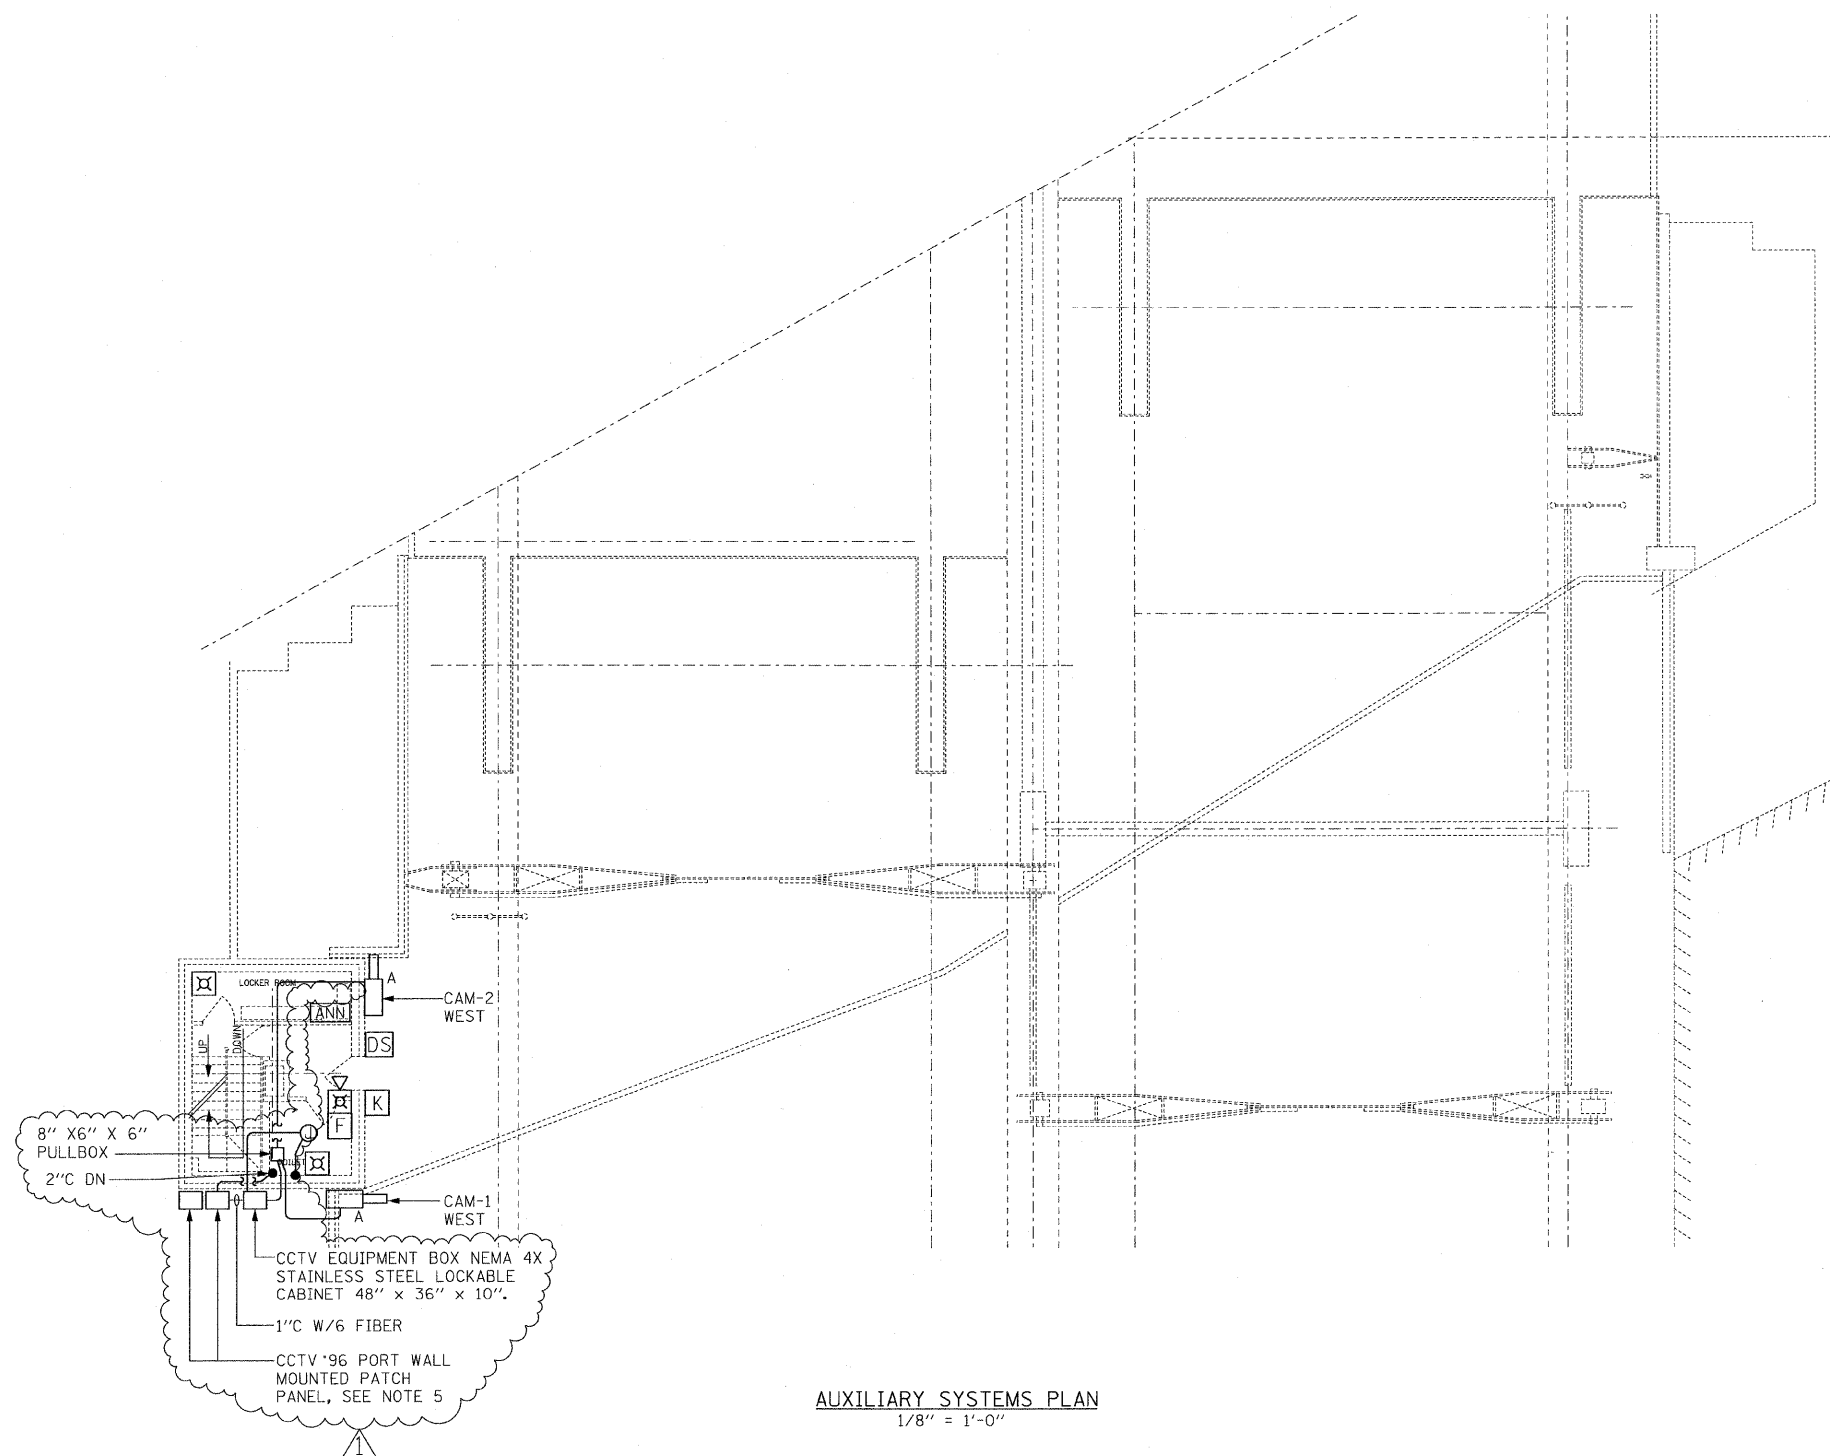

AUXILIARY SYSTEMS PLAN
1/8" = 1'-0"

ADDENDUM - JULY 14, 2009

PB Americas, Inc.
230 WEST MONROE STREET,
SUITE 900
CHICAGO, IL. 60606

USER NAME = sharma	DESIGNED - R. GODULIAS	REVISED -
FILE NAME = D:\6061-sht-elc-53.dgn	DRAWN - S. SHARMA	REVISED -
PLOT SCALE = NONE	CHECKED - M. INTATANO	REVISED -
PLOT DATE = 5/7/2009	DATE - MAY 8, 2009	REVISED -

**STATE OF ILLINOIS
DEPARTMENT OF TRANSPORTATION**

**AUXILIARY SYSTEMS PLAN
WEST SIDE SIDEWALK LEVEL**

SCALE: AS SHOWN | SHEET NO. E-53 OF E-125 SHEETS | STA. 379+06.09 TO STA. 382+45.28

F.A.P. RTE.	SECTION	COUNTY	TOTAL SHEETS	SHEET NO.
389	2424-2B-R	COOK	398	324
FED. ROAD DIST. NO. 1 ILLINOIS FED. AID PROJECT			CONTRACT NO. 60D61	