
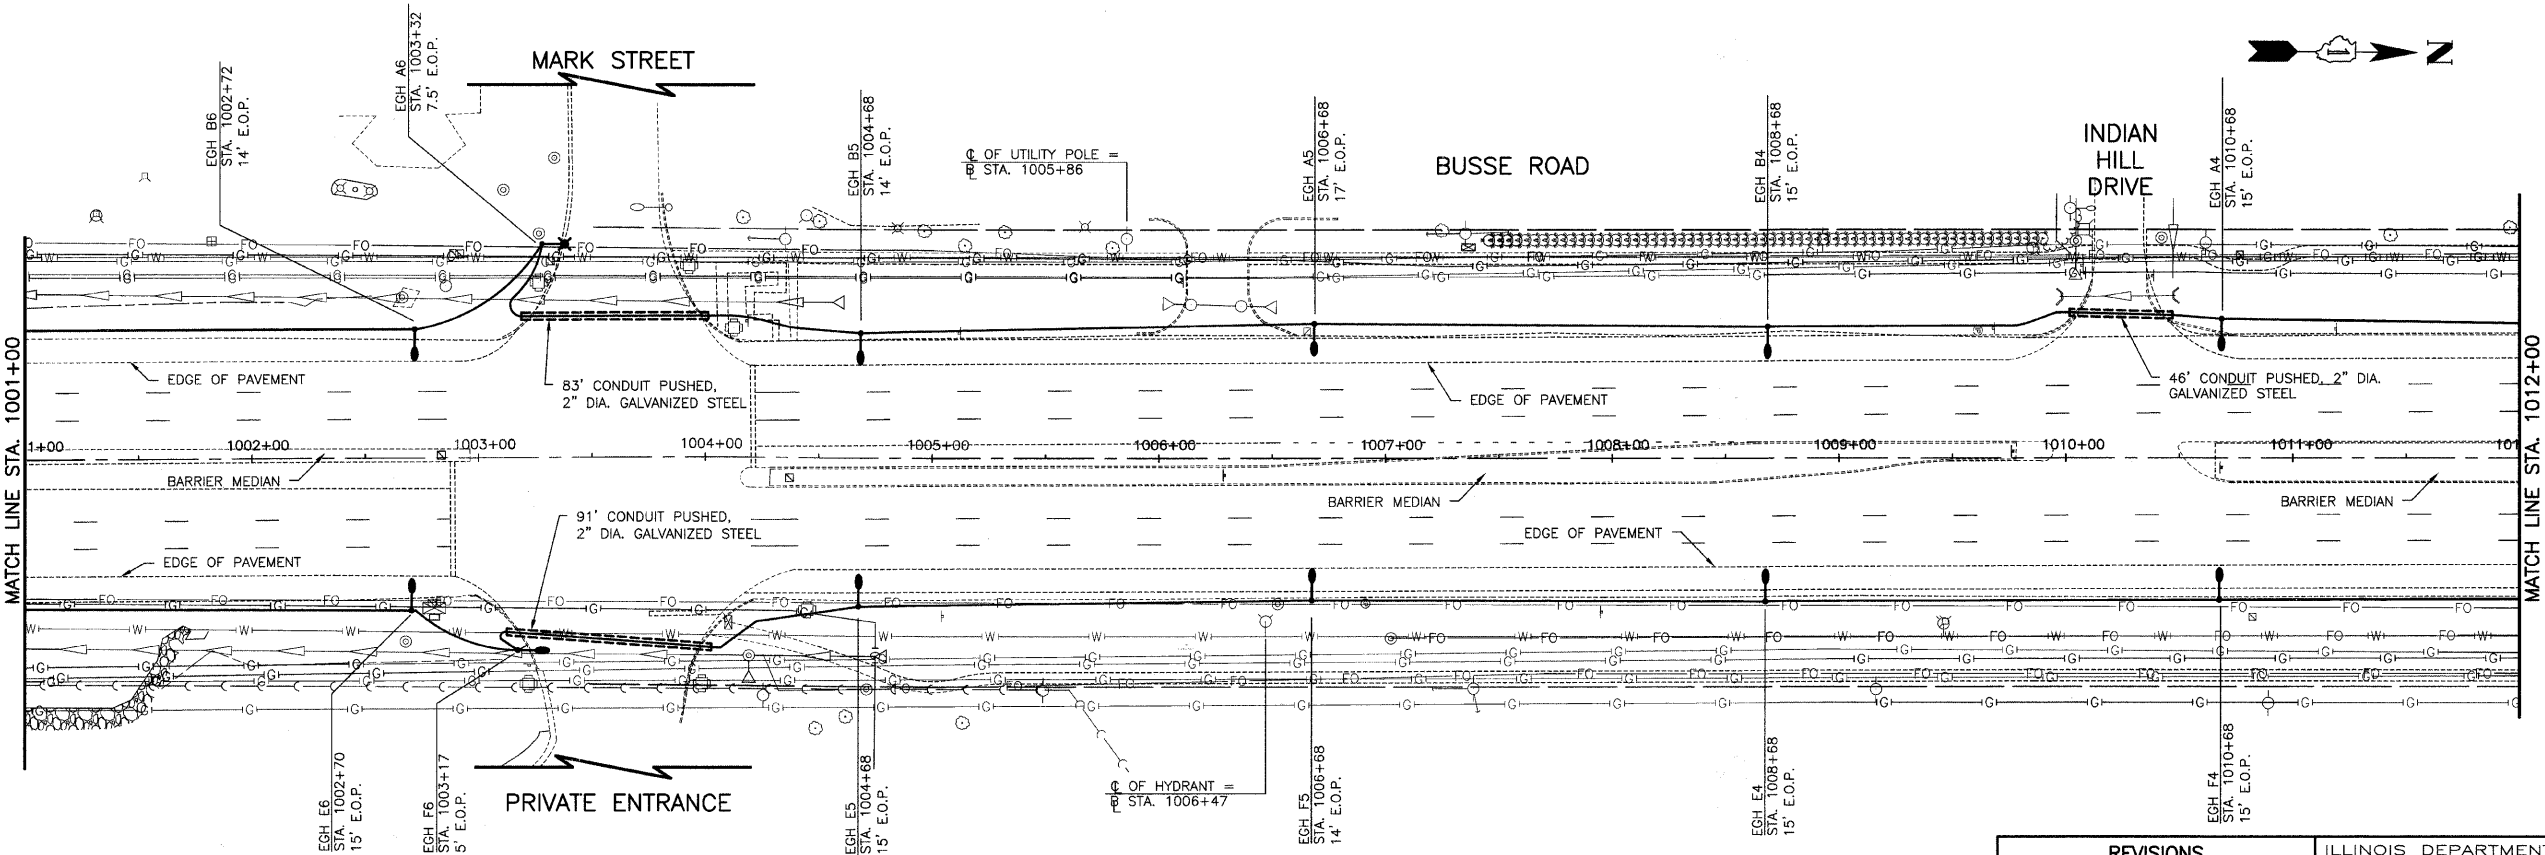


SECTION	COUNTY	TOTAL SHEETS	SHEET NO.
08-00053-00-LT	COOK/DUPAGE	15	3
IL RTE. 83 - STA. 998+85 TO STA. 1012+00			
LIGHTING PLAN			

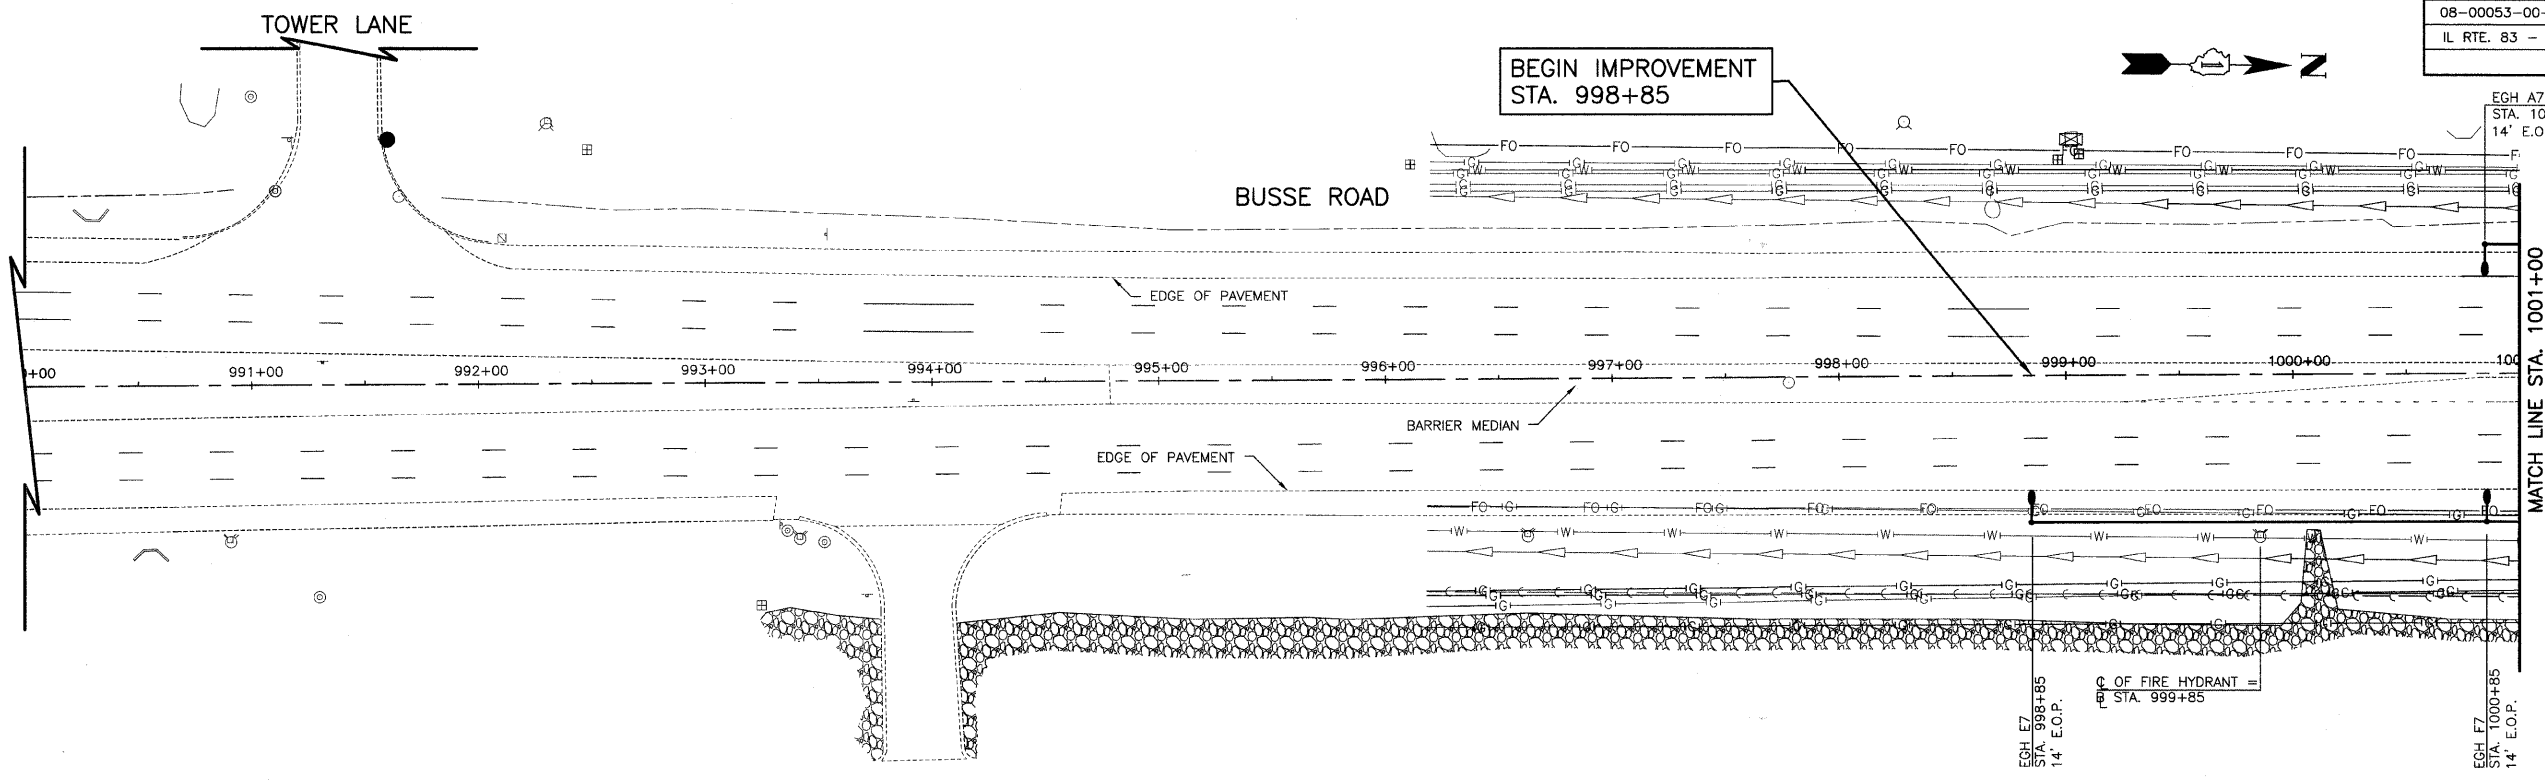

REVISIONS	
NAME	DATE

ILLINOIS DEPARTMENT OF TRANSPORTATION  
ILLINOIS ROUTE 83  
ROADWAY LIGHTING  
**LIGHTING PLAN**

ILLINOIS ROUTE 83 (BUSSE ROAD)  
STA. 1000+85 TO STA. 1012+00

DATE: 05/14/2008  
CHECKED BY: D.N.M.

SCALE IN FEET

