


SECTION	COUNTY	TOTAL SHEETS	SHEET NO.
08-00053-00-LT	COOK/DUPAGE	15	9
GREENLEAF AVENUE			
LIGHTING PLAN			

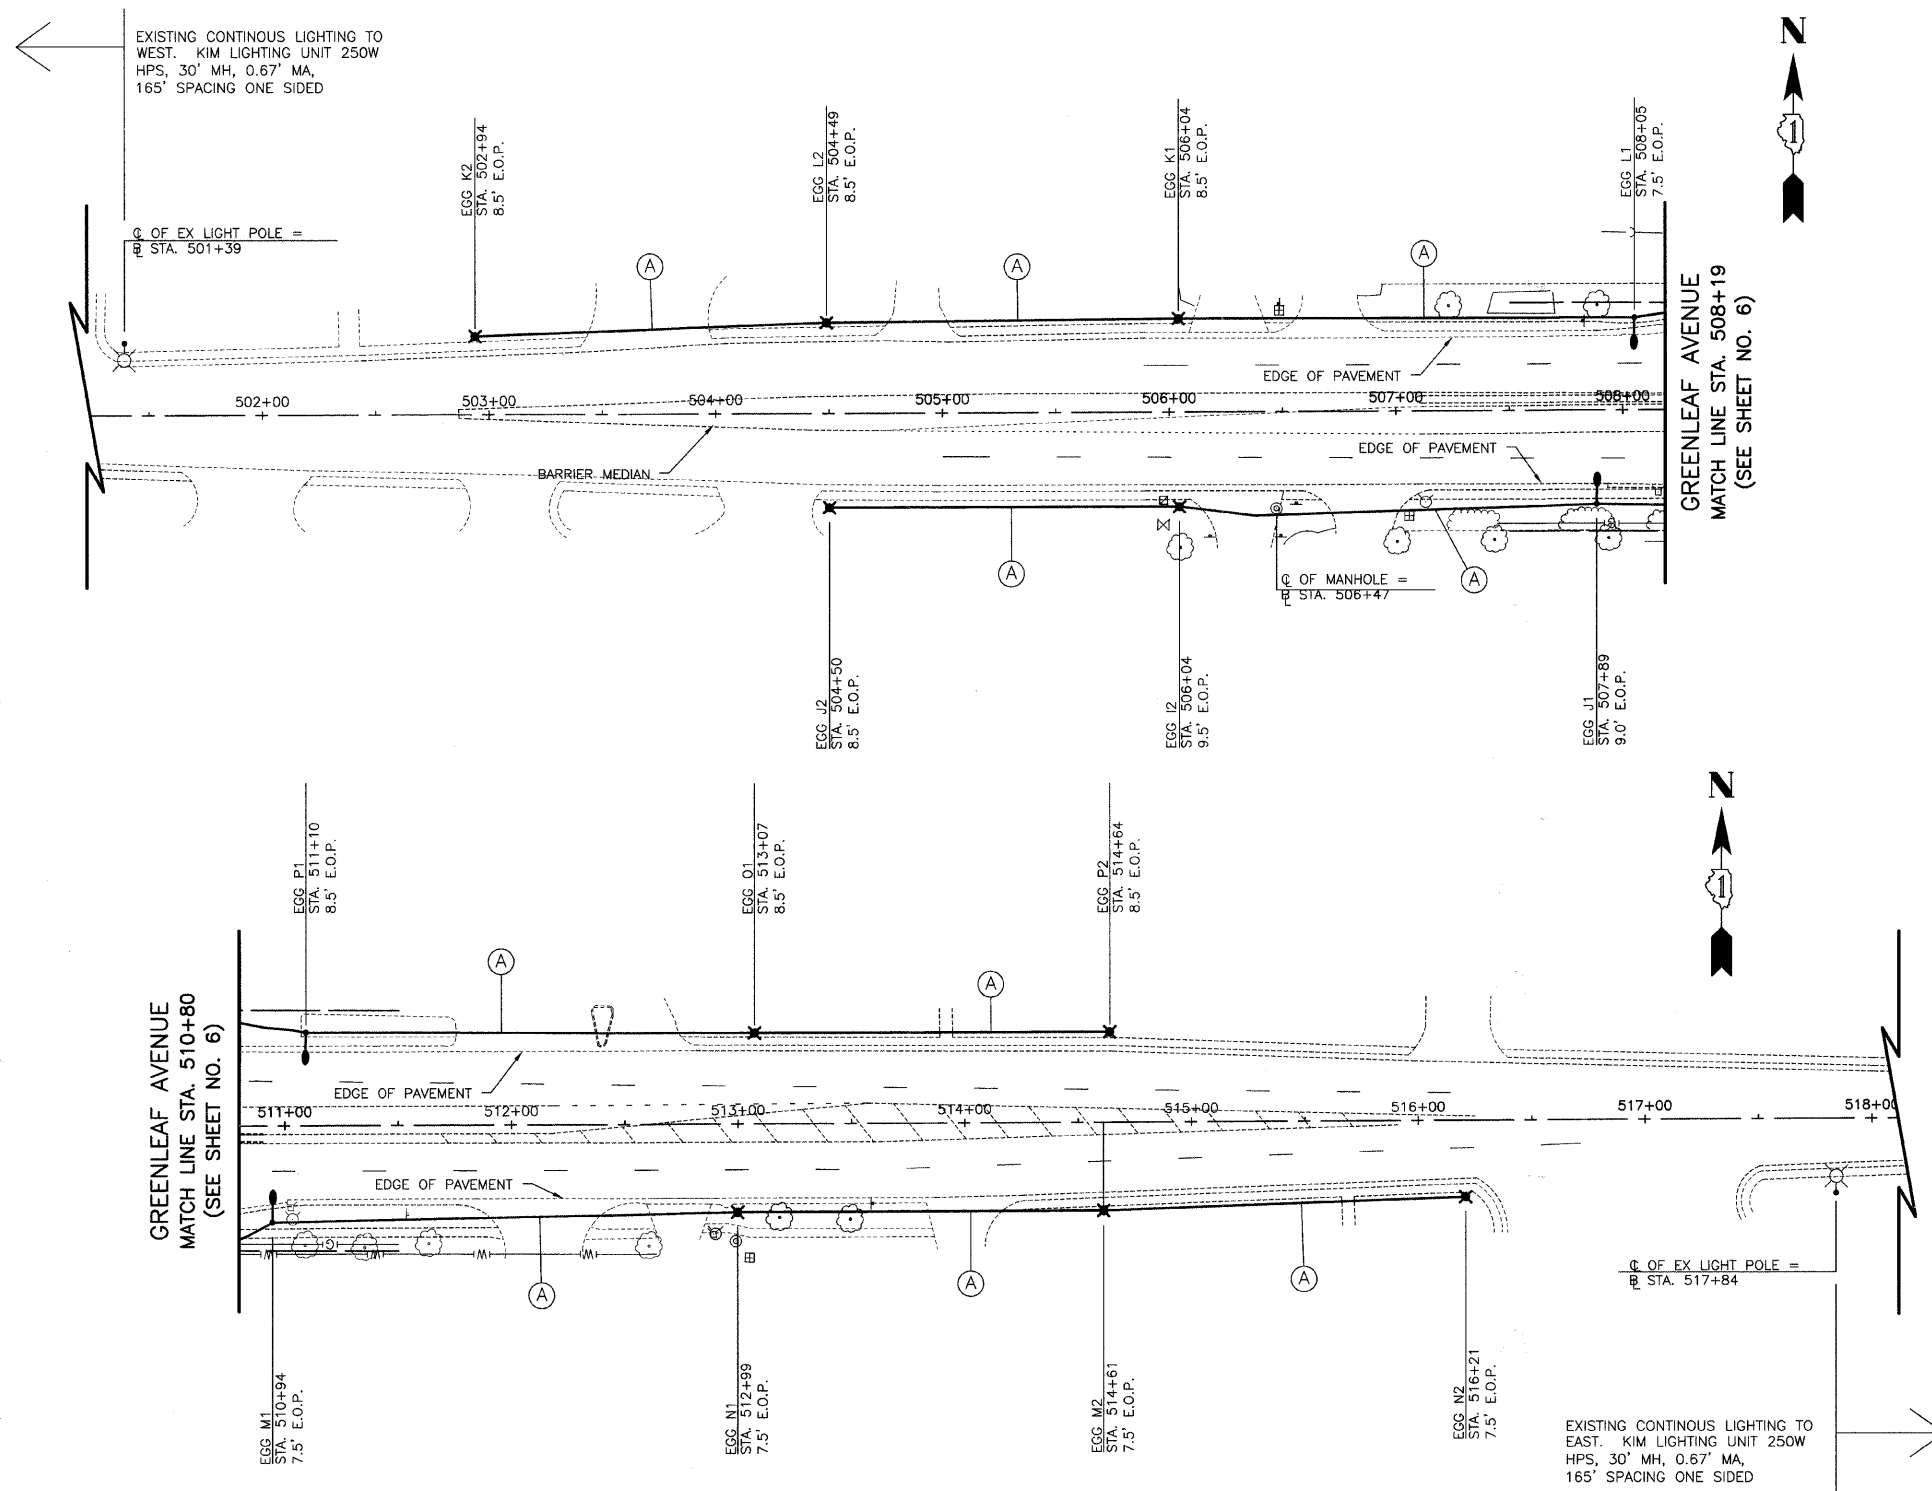

NOTE:

1. ALL UNIT DUCT IS 600V, 3-1C NO.4, 1/C NO.4 GROUND, (XLP-TYPE USE), 1 1/4" DIA. POLYETHYLENE EXCEPT WHERE NOTED WITH (A), WHICH IS UNIT DUCT, 600V, 3-1C NO.8, 1/C NO.8 GROUND, (XLP-TYPE USE), 1" DIA. POLYETHYLENE

REVISIONS	
NAME	DATE

ILLINOIS DEPARTMENT OF TRANSPORTATION
ILLINOIS ROUTE 83
ROADWAY LIGHTING
LIGHTING PLAN
GREENLEAF AVENUE

SCALE IN FEET

DATE: 05/14/2008
CHECKED BY: D.N.M.