
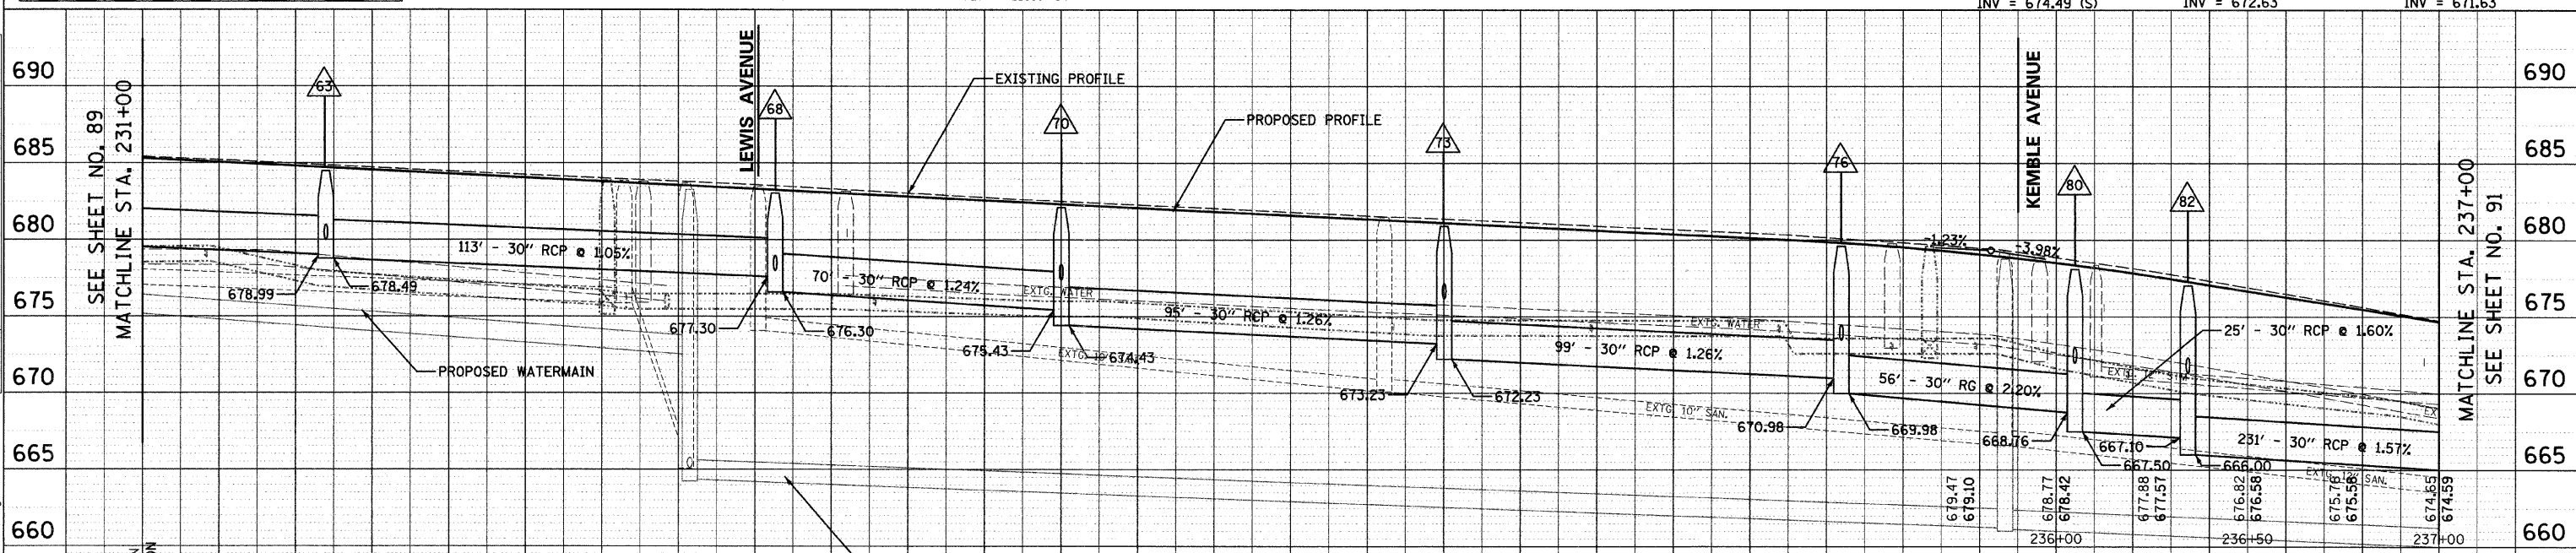


STA. 231+48, 26' LT CB, TYPE C, 2' DIA. TYPE 23 F&G R = 684.05 INV = 679.96	STA. 231+48, 26' RT CB, TYPE C, 2' DIA. TYPE 23 F&G R = 684.05 INV = 680.05	STA. 102+63, 4' RT CB, TYPE A, 4' DIA. TYPE 1 F, CL RIM = 683.10 INV = 678.51 (E,W,S)	STA. 232+65, 6' LT MH, TYPE A, 5' DIA. TYPE 1 F, CL RIM = 683.05 INV = 677.30 (W) INV = 676.30 (E) INV = 677.99 (N)	STA. 233+40, 6' LT MH, TYPE A, 5' DIA. TYPE 1 F, CL RIM = 682.12 INV = 675.43 (W) INV = 674.43 (E) INV = 677.41 (N,S)	STA. 234+40, 26' RT CB, TYPE C, 2' DIA. TYPE 23 F&G R = 680.45 INV = 675.28	STA. 234+40, 26' LT CB, TYPE C, 2' DIA. TYPE 23 F&G R = 680.45 INV = 676.45	STA. 235+42, 26' LT CB, TYPE C, 2' DIA. TYPE 23 F&G R = 679.18 INV = 675.18	STA. 235+44, 6' LT MH, TYPE A, 5' DIA. TYPE 1 F, CL RIM = 679.59 INV = 670.98 (W) INV = 669.98 (E) INV = 673.48 (S) INV = 675.00 (N)	STA. 235+40, 26' RT CB, TYPE C, 2' DIA. TYPE 23 F&G R = 679.21 INV = 673.77
---	---	---	---	---	---	---	---	---	---

F.A.U. R.T.E.	SECTION	COUNTY	TOTAL SHEETS	SHEET NO.
1230	03-00159-00-PV	LAKE	262	90
STA. 231+00		TO STA. 237+00		
FED. ROAD DIST. NO. 1		ILLINOIS		FED. AID PROJECT
CONTRACT: 83828				

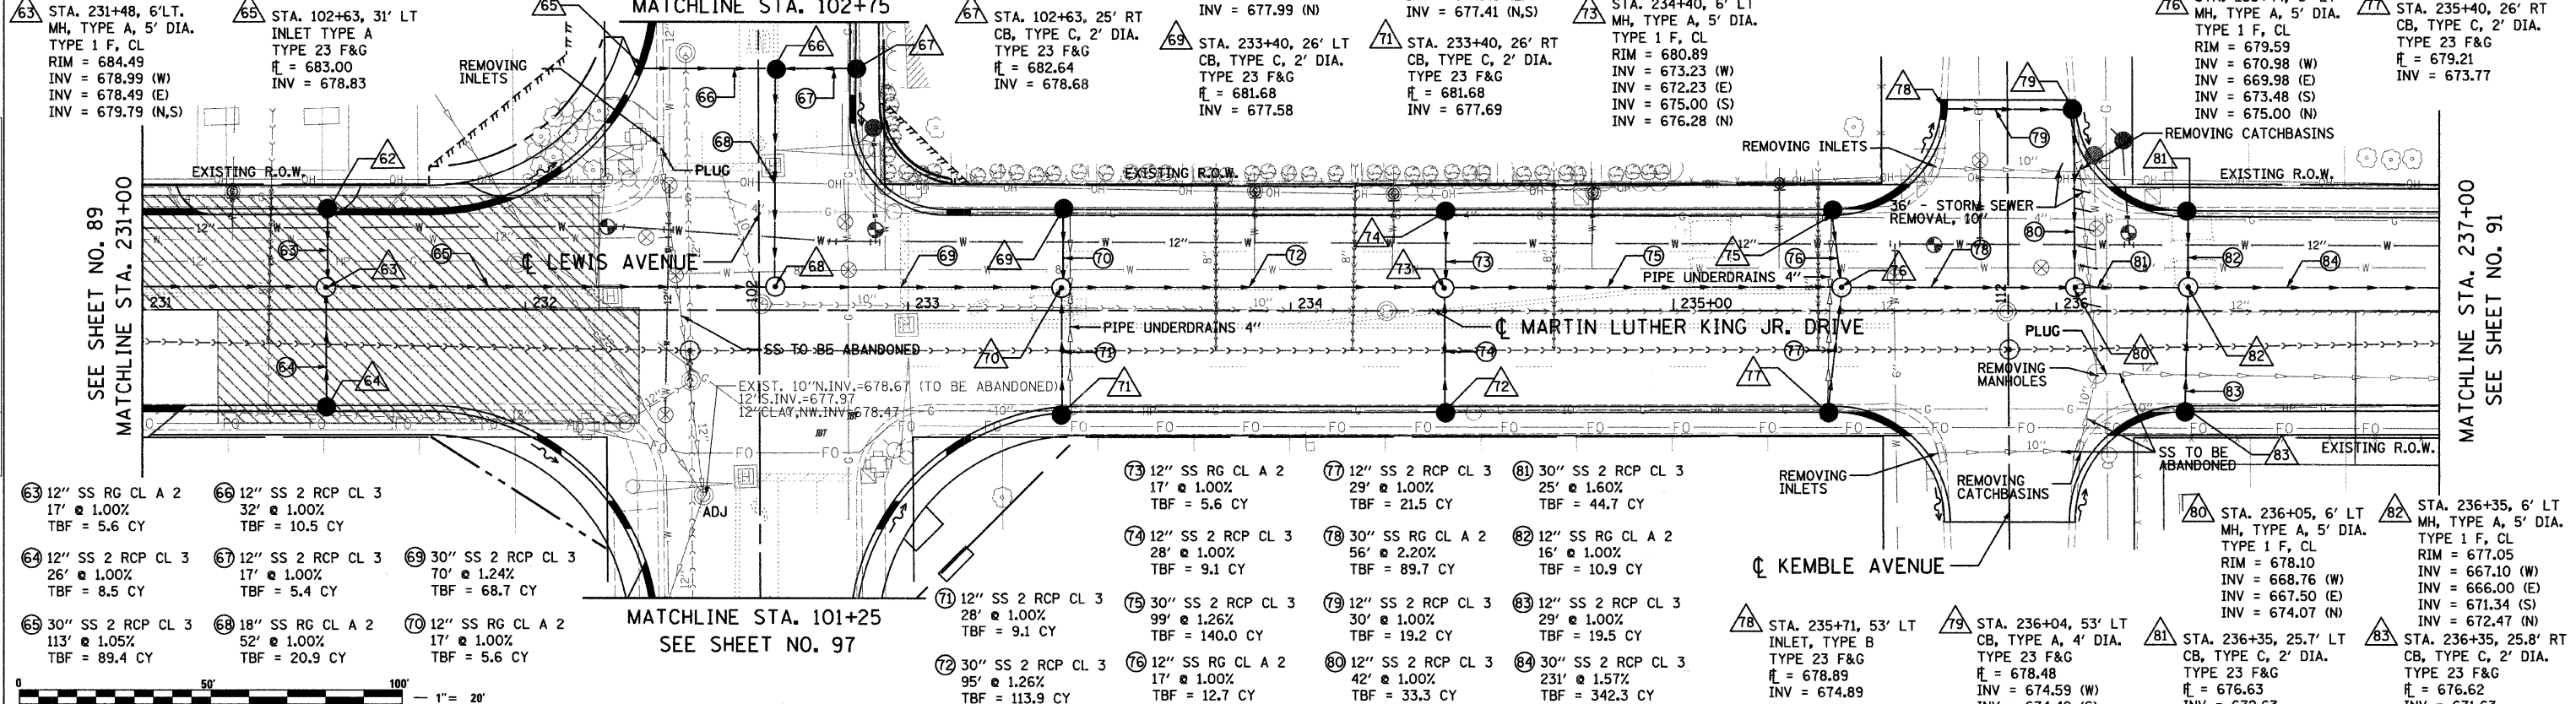

685.32	685.20	685.05	684.89	684.74	684.58	684.44	684.28	684.16	683.97	683.89	683.66	683.52	683.35	683.31	683.04	682.96	682.74	682.61	682.43	682.32	682.12	682.03	681.81	681.72	681.50	681.42	681.20	681.17	680.89	680.88	680.58	680.59	680.27	680.30	679.96	679.89	679.62			
231+00		231+50		232+00		232+50		233+00		233+50		234+00		234+50		235+00		235+50		236+00		236+50		237+00																

REVISIONS	
NAME	DATE

**Clorba Group, Inc.**  
CONSULTING ENGINEERS  
5507 North Cumberland Avenue, Suite 402 Chicago, Illinois 60656  
Tel: 773.775.4009 Fax: 773.775.4014 Email: chicago@clorba.com

CITY OF NORTH CHICAGO  
MARTIN LUTHER KING JR. DRIVE IMPROVEMENTS  
MARTIN LUTHER KING JR. DRIVE  
PROPOSED STORM SEWER  
PLAN AND PROFILE  
STA. 231+00 TO 237+00

SCALE: 1"=20'  
DATE: APRIL, 2008  
DRAWN BY: KMS  
CHECKED BY: MJL

DATE: 7/1/2008  
FILENAME: N:\PROJ\05161\Design\Drainage\05161-CRN-08.dgn

PLAN: [ ]  
PROFILE: [ ]

BY: [ ]  
CHECKED: [ ]  
DATE: [ ]