




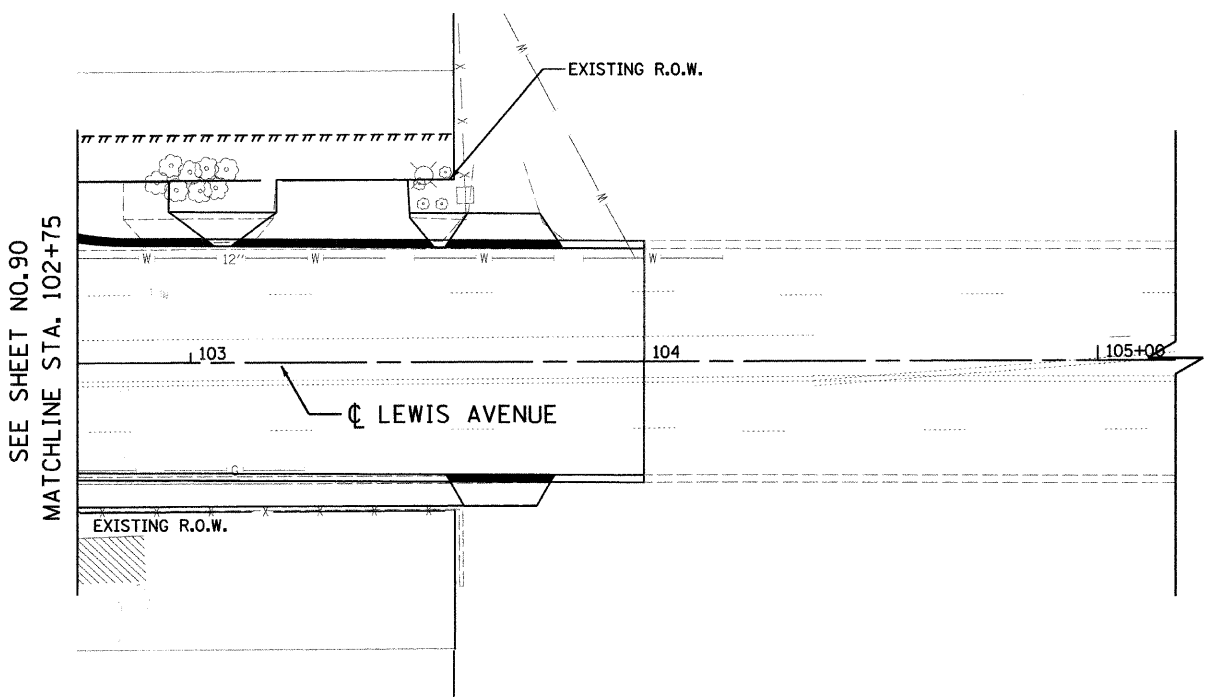

PLAN	DATE
NO.	
BY	
CHECKED	
DATE	
FILE NAME	

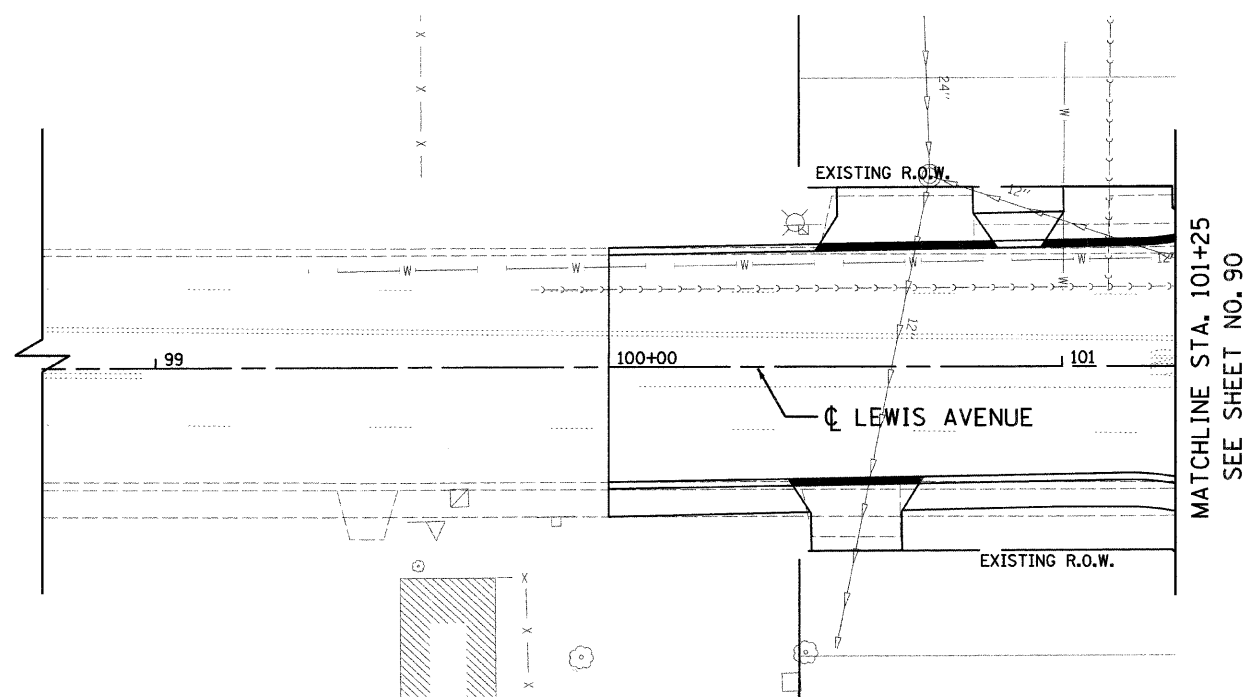

PROFILE	DATE
NO.	
BY	
CHECKED	
DATE	
FILE NAME	

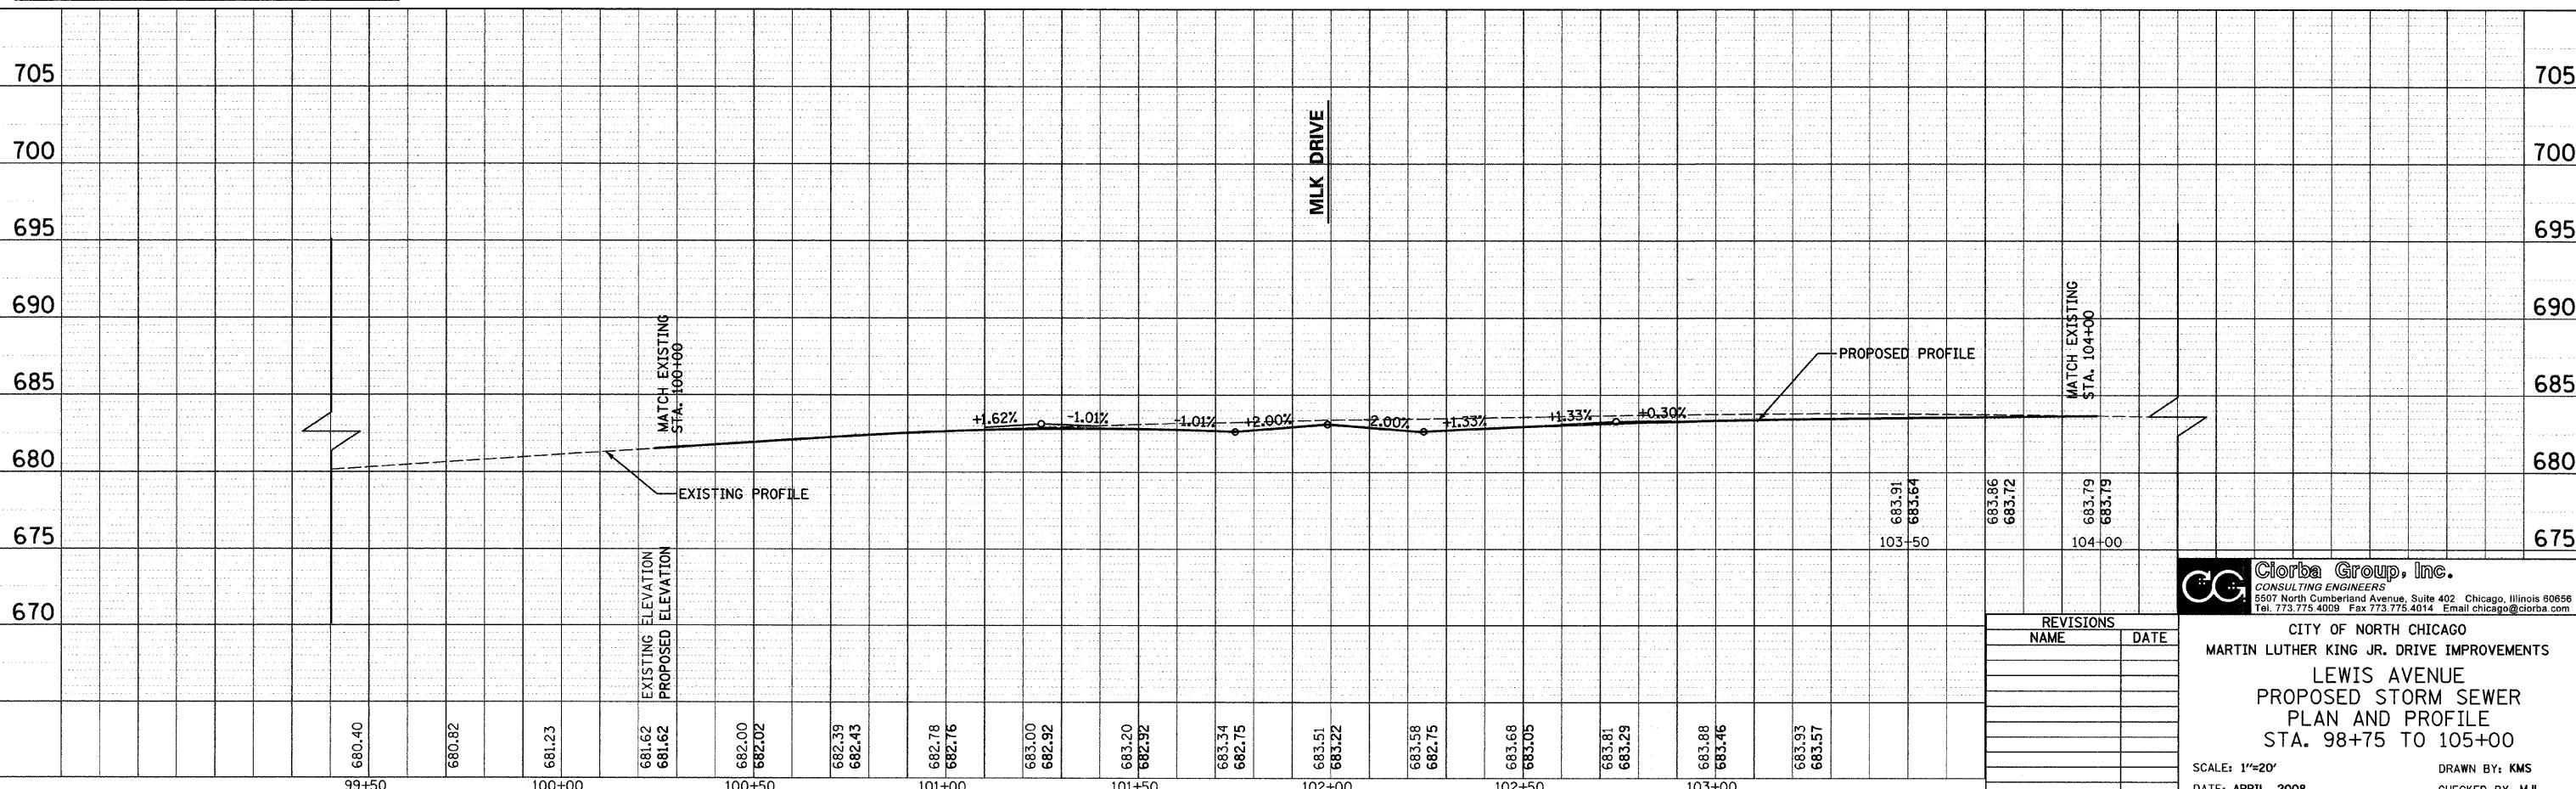

REVISIONS	
NAME	DATE

Clorba Group, Inc.
CONSULTING ENGINEERS
5507 North Cumberland Avenue, Suite 402 Chicago, Illinois 60656
Tel. 773.775.4009 Fax 773.775.4014 Email: chicago@clorba.com

CITY OF NORTH CHICAGO
MARTIN LUTHER KING JR. DRIVE IMPROVEMENTS
LEWIS AVENUE
PROPOSED STORM SEWER
PLAN AND PROFILE
STA. 98+75 TO 105+00

SCALE: 1"=20'
DATE: APRIL, 2008
DRAWN BY: KMS
CHECKED BY: MJL

DATE: 7/1/2008
TIME: 10:00 AM
FILE NAME: N:\PROJ\05161\Design\Drawings\61-DRN-13.dgn