
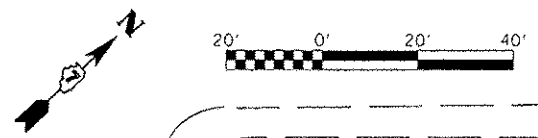


DATE	
BY	
DESIGNED	
CHECKED	
DRAWN	
PLANNED	
FILED	
NO.	

DATE	
BY	
DESIGNED	
CHECKED	
DRAWN	
PLANNED	
FILED	
NO.	

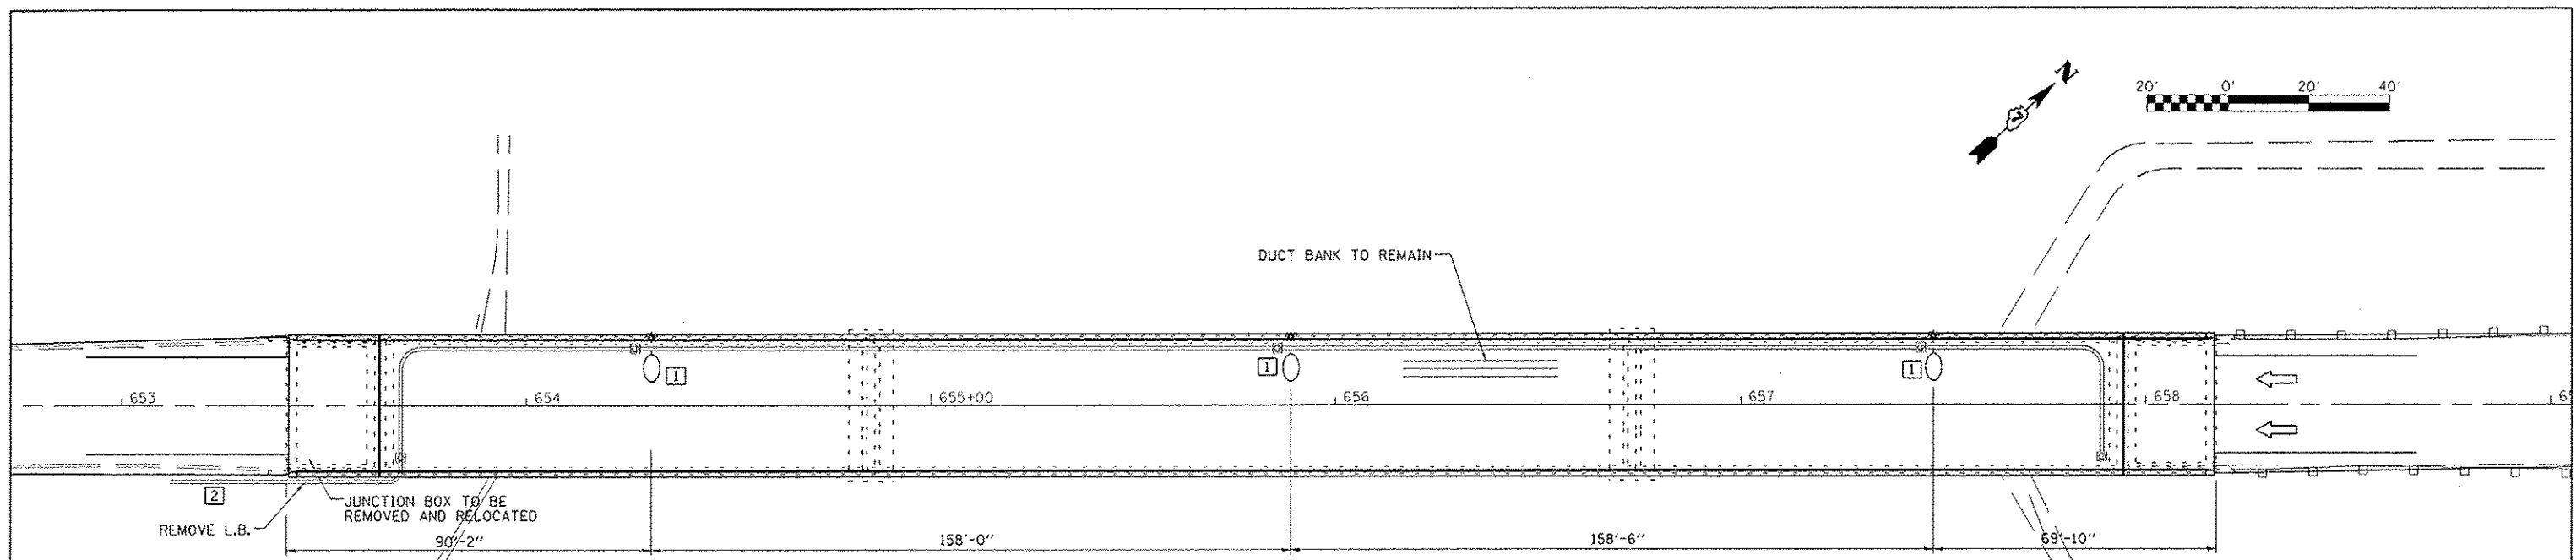


GENERAL NOTES FOR DEMOLITION

1. DISCONNECT AND REMOVE ELECTRICAL ITEMS AND ASSOCIATED CONDUIT, WIRING, ETC. AS SHOWN OR NOTED.
2. DISCONNECT AND REMOVE ALL DEVICES, CONDUIT, WIRING, ETC. ASSOCIATED WITH LIGHTING AND POWER SYSTEMS BEING REMOVED.
3. BE RESPONSIBLE FOR CONTINUITY OF ALL EXISTING POWER AND LIGHTING CIRCUITS AND SYSTEMS OF ALL REMAINING DEVICES AND SYSTEMS WHICH MAY BE AFFECTED BY MODIFICATIONS.
4. EXISTING CIRCUIT CONDUCTORS CONNECTED TO OTHER FIXTURES, DEVICES OR OTHER ELECTRICAL EQUIPMENT THAT ARE NOT TO BE REMOVED OR DISCONNECTED AND ARE PASSING THROUGH OUTLET BOXES, FIXTURES, AND CONDUIT THAT ARE BEING REMOVED, SHALL BE REROUTED FROM REMAINING EXISTING DEVICE TO NEXT REMAINING DEVICE AS NECESSARY TO KEEP REMAINING DEVICES IN SERVICE AND EXISTING CIRCUIT CONDUCTORS CONTINUOUS.
5. FOR EACH ITEM DISCONNECTED AND REMOVED, DISCONNECT AND REMOVE ABANDONED CIRCUIT WIRING AND CONDUIT BACK TO NEXT ACTIVE REMAINING DEVICE OR TO PANEL OR SWITCHBOARD FROM WHICH THE CIRCUIT ORIGINATES.
6. FOR EACH ITEM DISCONNECTED AND REMOVED, DISCONNECT AND REMOVE ABANDONED, EXPOSED CONDUITS AND/OR CONDUITS MADE EXPOSED BY DEMOLITION, BACK TO NEXT ACTIVE REMAINING DEVICE OR TO PANEL OR SWITCHBOARD FROM WHICH THE CIRCUIT ORIGINATES.
7. TURN OVER ALL REMOVED LIGHT FIXTURES TO THE OWNER AND DELIVER TO A PLACE OF STORAGE AS DIRECTED.

KEYED NOTES (FOR THIS SHEET ONLY)

- 1 REMOVE ALL CONDUIT, WIRE, LIGHTING POLES, FIXTURES AND JUNCTION BOXES UNLESS OTHERWISE NOTED.
- 2 EXISTING RIGID CONDUIT AND WIRE TO REMAIN.

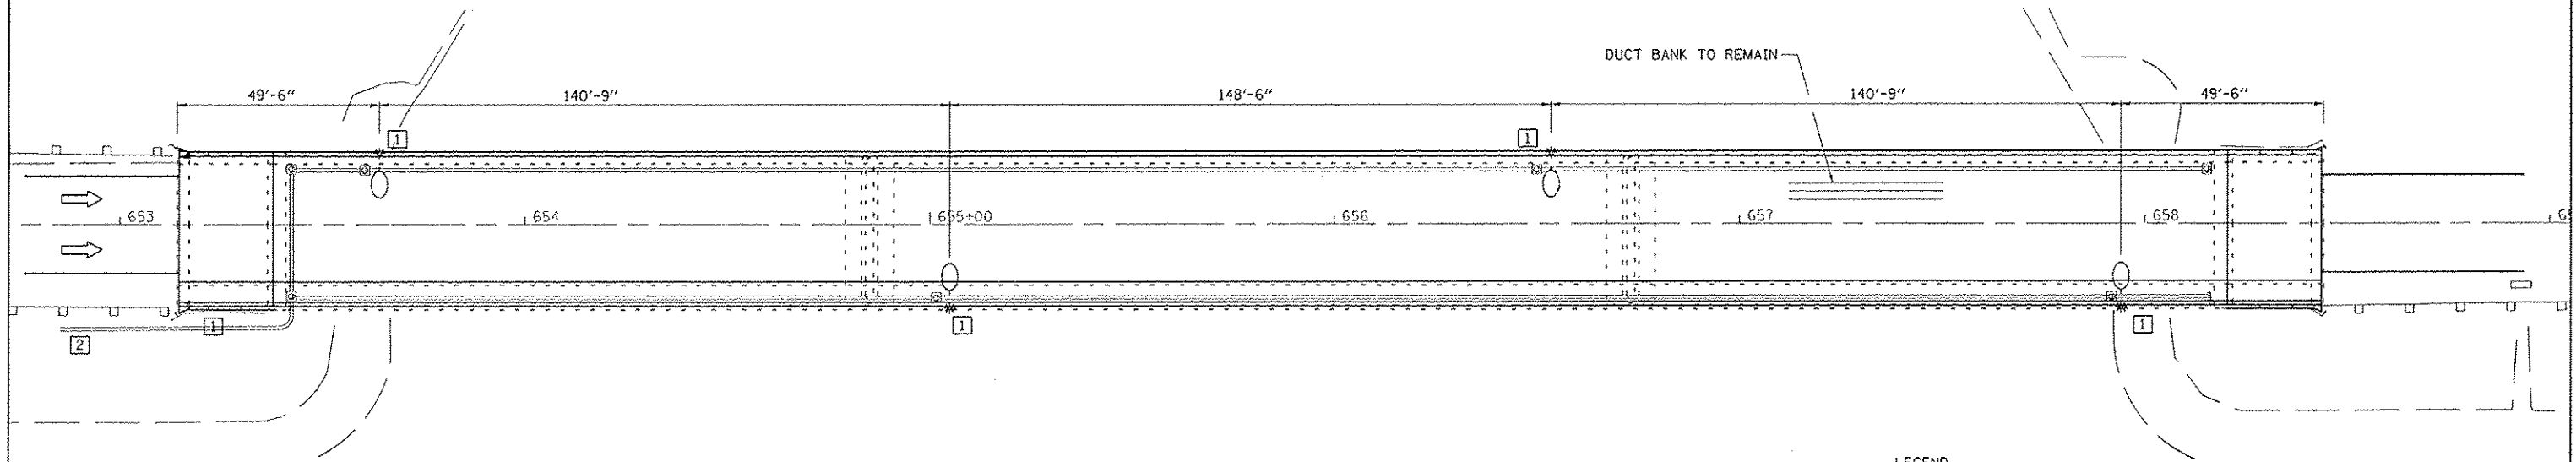

LEGEND

- ⊗ EXISTING JUNCTION BOX
- * EXISTING MAST ARM LIGHT POLE WITH LUMINAIRE
- EXISTING CONDUIT
- EXISTING CONDUIT STUB
- 1 INDICATES KEYED NOTE FOR SHEET ON WHICH IT APPEARS UNLESS OTHERWISE NOTED.

REV.

FILE NAME =	USER NAME = #USER#	DESIGNED -	REVISED -	STATE OF ILLINOIS DEPARTMENT OF TRANSPORTATION	LIGHTING PLAN (REMOVAL)	F.A.P. RTE.	SECTION	COUNTY	TOTAL SHEETS	SHEET NO.	
#FILE#		CHECKED -	REVISED -			710	(48-X-B-2)BR & (48BR)BR	MACON	144	36	
		DRAWN -	REVISED -			CONTRACT NO. 74438					
		CHECKED -	REVISED -			ILLINOIS FED. AID PROJECT					
				SCALE:	SHEET NO. 1 OF 3 SHEETS	STA.	TO STA.				