
 


F.A.P. RTE.	SECTION	COUNTY	TOTAL SHEETS	SHEET NO.
335	119R-2	LAKE	439	150
STA. 432+83.12		TO STA. 470+56.84		
FED. ROAD DIST. NO.		ILLINOIS FED. AID PROJECT		

60B01

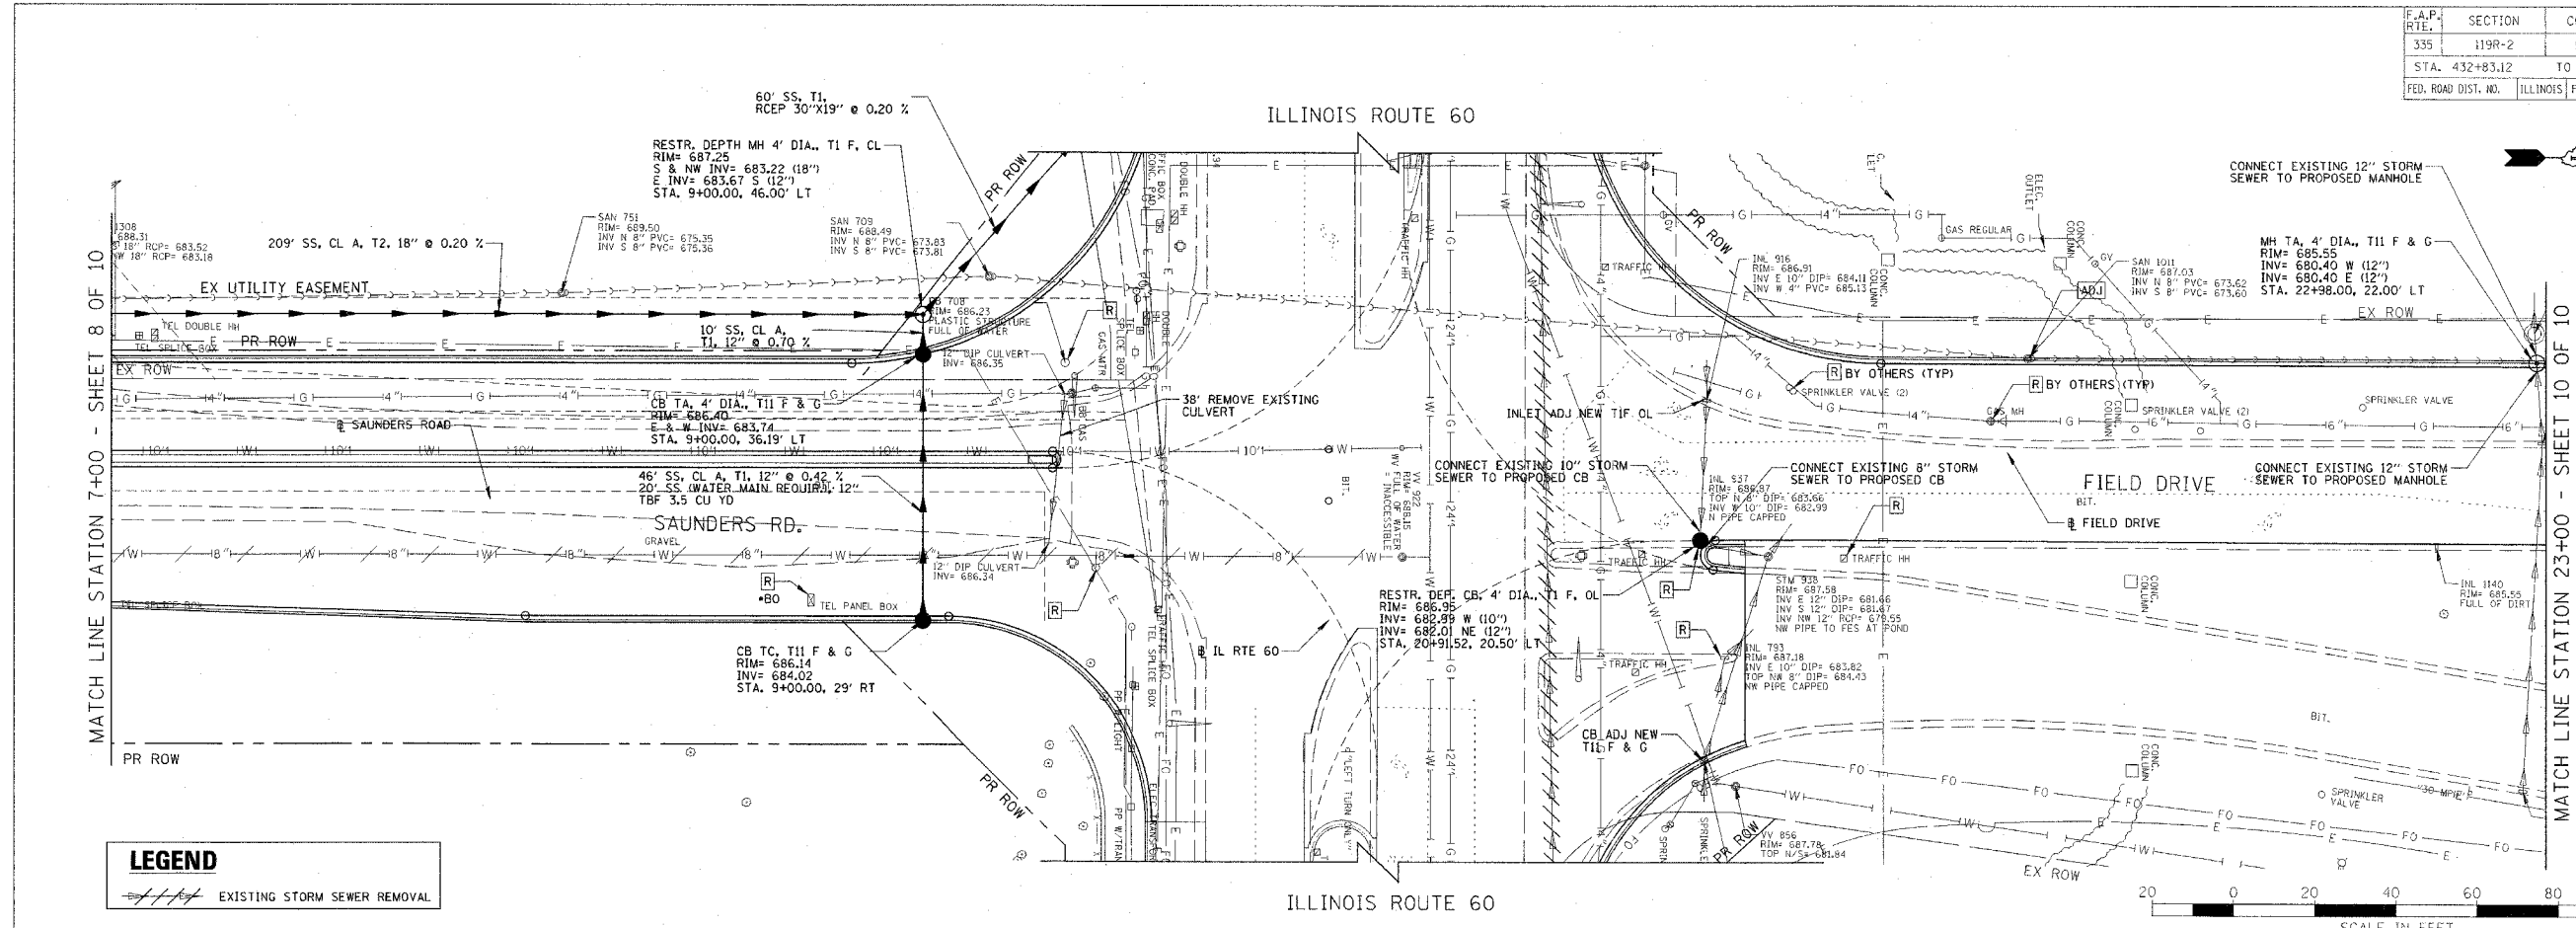


LEGEND
 EXISTING STORM SEWER REMOVAL



PLAN	SURVEYED	CHECKED
NOTE BOOK NO.	ALIGNED	APPROVED
	DATE	

PROFILE	SURVEYED	CHECKED
NOTE BOOK NO.	GRADES	NOTES
	DATE	

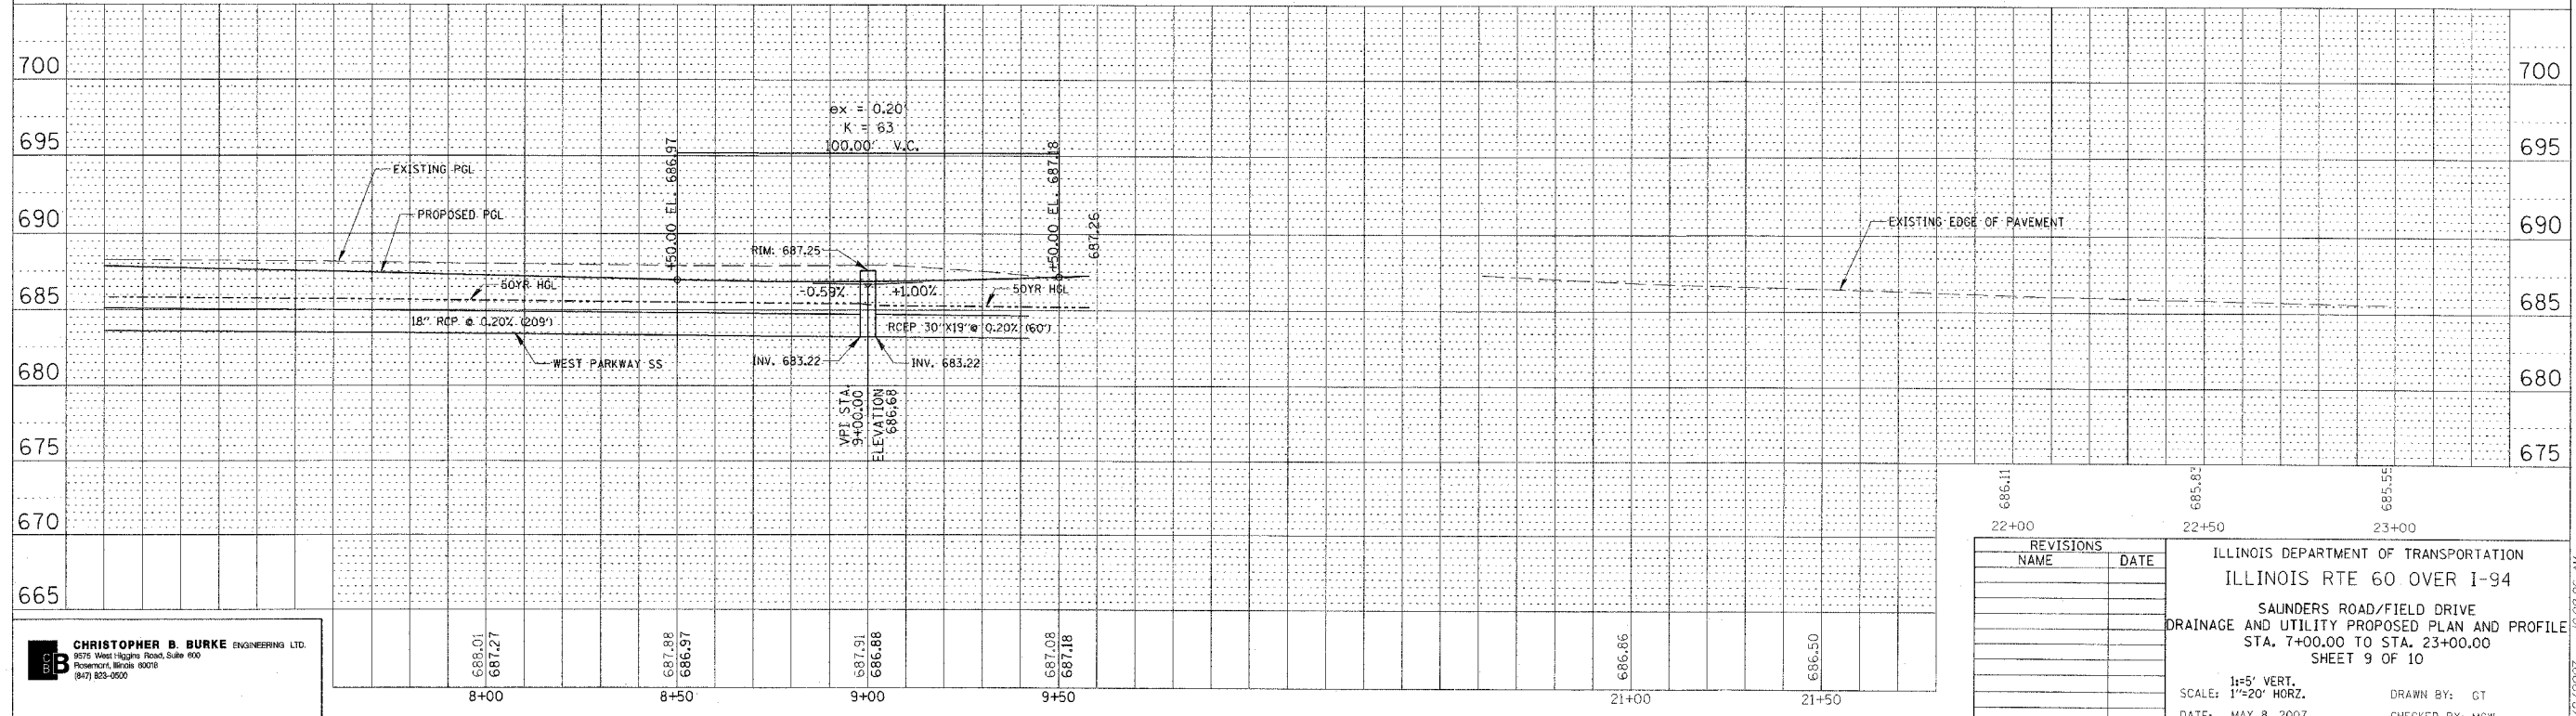

CHRISTOPHER B. BURKE ENGINEERING LTD.
 9575 West Higgins Road, Suite 600
 Rosemont, Illinois 60018
 (847) 823-0500

REVISIONS	NAME	DATE

ILLINOIS DEPARTMENT OF TRANSPORTATION
 ILLINOIS RTE 60 OVER I-94
 SAUNDERS ROAD/FIELD DRIVE
 DRAINAGE AND UTILITY PROPOSED PLAN AND PROFILE
 STA. 7+00.00 TO STA. 23+00.00
 SHEET 9 OF 10
 1"=5' VERT.
 SCALE: 1"=20' HORZ.
 DATE: MAY 8, 2007
 DRAWN BY: GT
 CHECKED BY: MCW

5/2/2007 10:08:26 AM