


CONTRACT NO. 60B82

F.A.I.L. RTE.	SECTION	COUNTY	TOTAL SHEETS	SHEET NO.
1320	581EXT-BR	COOK	46	19
STA.		TO STA.		
FED. ROAD DIST. NO.		ILLINOIS	FED. AID PROJECT	




LEGEND:

 EXISTING LIGHTING UNIT

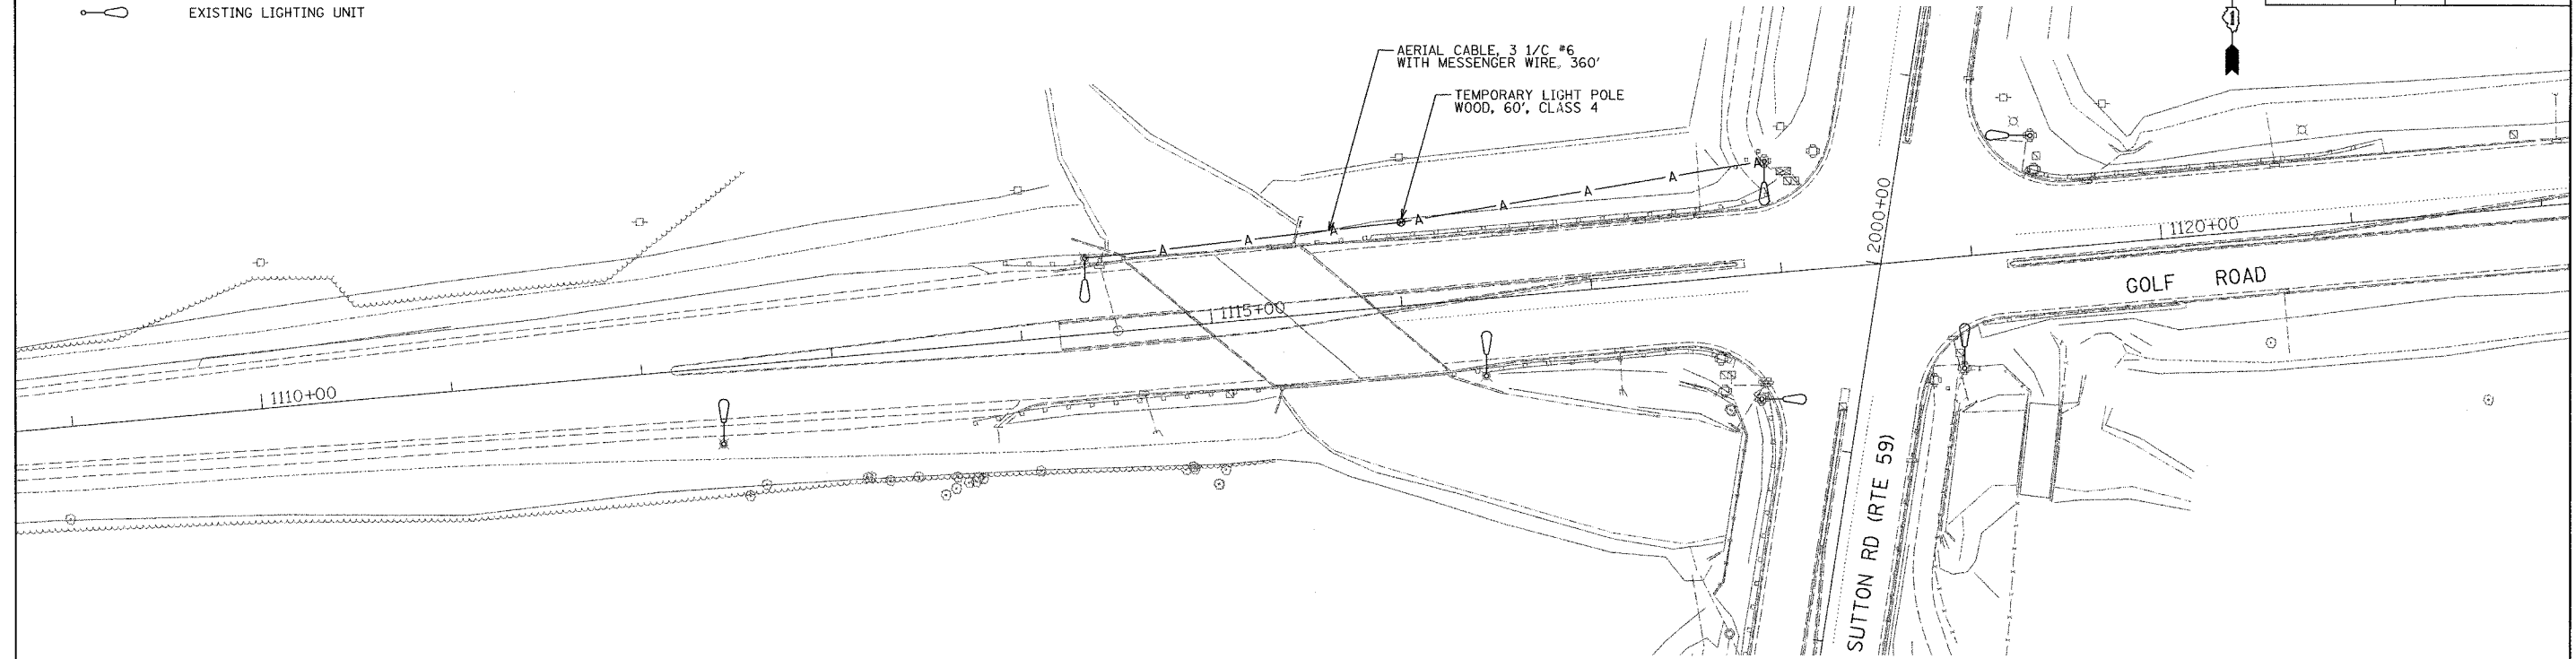


TEMPORARY LIGHTING PLAN

 


LEGEND:

 EXISTING LIGHTING UNIT

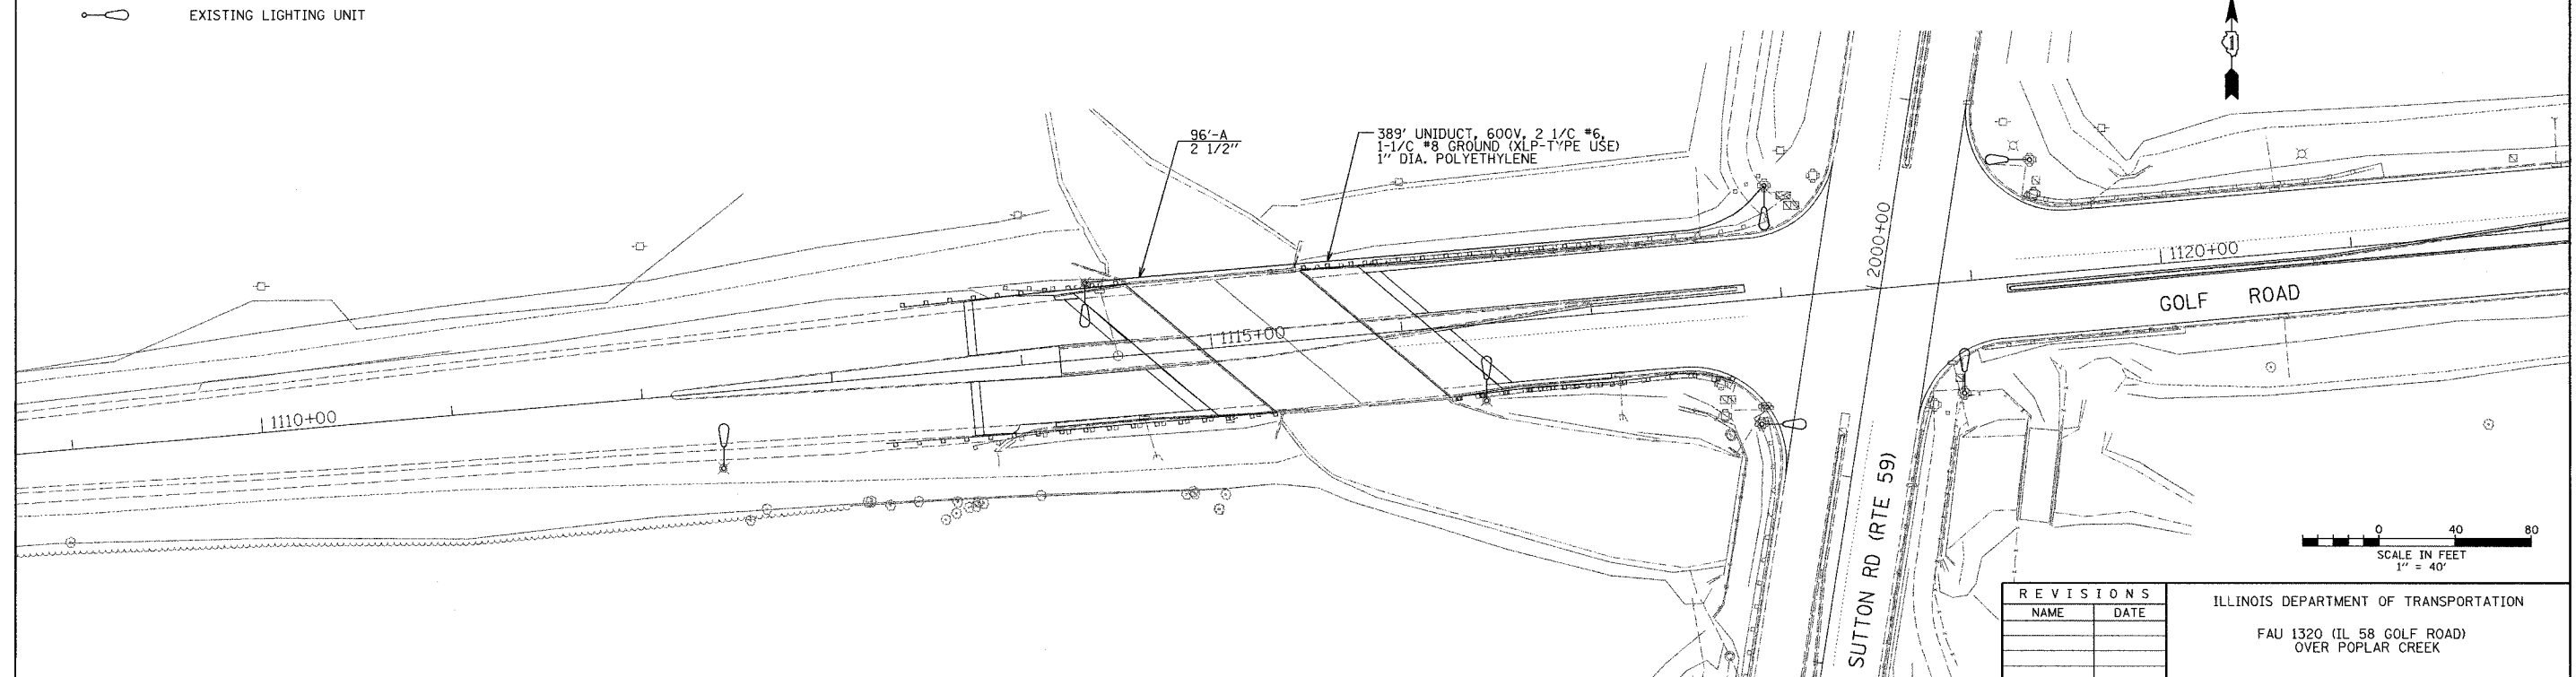

LIGHTING PLAN

 

REVISIONS	
NAME	DATE

ILLINOIS DEPARTMENT OF TRANSPORTATION
 FAU 1320 (IL 58 GOLF ROAD)
 OVER POPLAR CREEK
 LIGHTING PLAN

DATE: 7/20/2007
 SCALE: 1"=40'

DRAWN BY: AJR
 CHECKED BY: RJS