 



 


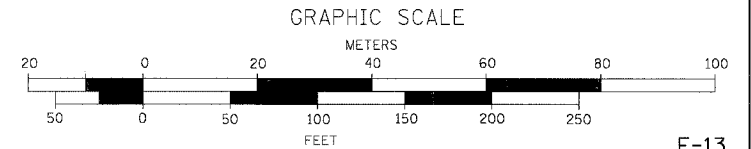
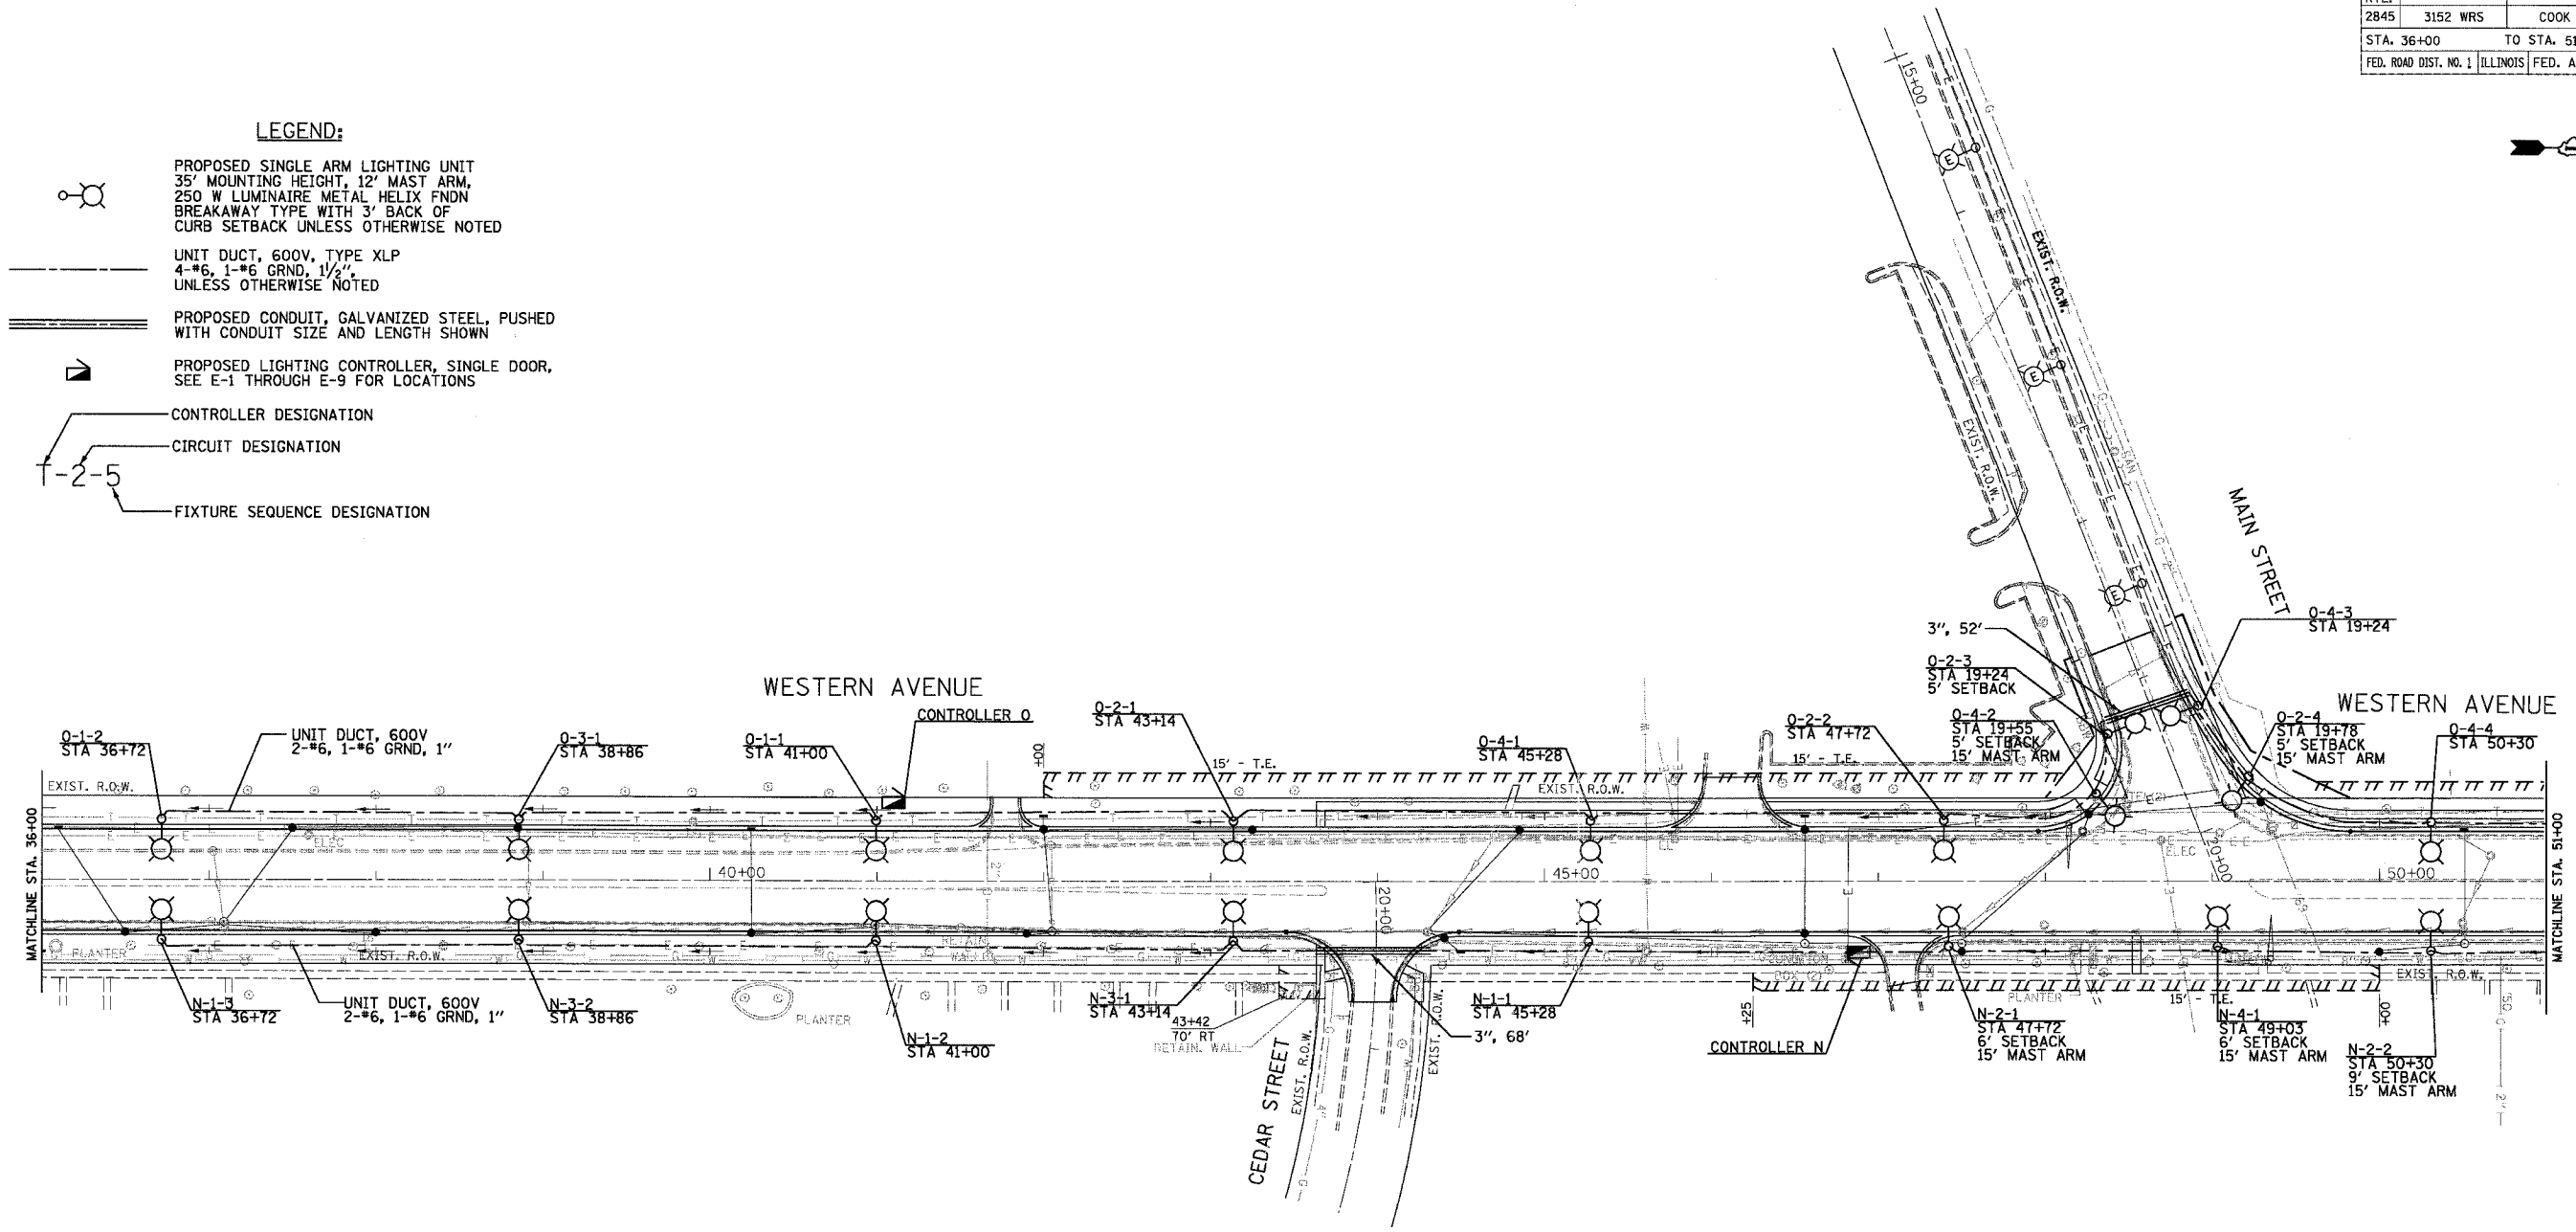


CONTRACT NO. 62742			
F.A. RTE.	SECTION	COUNTY	TOTAL SHEET NO.
2845	3152 WRS	COOK	141 137
STA. 36+00		TO STA. 51+00	
FED. ROAD DIST. NO. 1 ILLINOIS FED. AID PROJECT			

- LEGEND:**
-  PROPOSED SINGLE ARM LIGHTING UNIT
35' MOUNTING HEIGHT, 12' MAST ARM,
250 W LUMINAIRE METAL HELIX FNDN
BREAKAWAY TYPE WITH 3' BACK OF
CURB SETBACK UNLESS OTHERWISE NOTED
 -  UNIT DUCT, 600V, TYPE XLP
4-#6, 1-#6 GRND, 1 1/2"
UNLESS OTHERWISE NOTED
 -  PROPOSED CONDUIT, GALVANIZED STEEL, PUSHED
WITH CONDUIT SIZE AND LENGTH SHOWN
 -  PROPOSED LIGHTING CONTROLLER, SINGLE DOOR,
SEE E-1 THROUGH E-9 FOR LOCATIONS
 -  CONTROLLER DESIGNATION
 -  CIRCUIT DESIGNATION
 -  FIXTURE SEQUENCE DESIGNATION



E-13

REVISIONS	
NAME	DATE

ILLINOIS DEPARTMENT OF TRANSPORTATION

WESTERN AVE.
PROPOSED LIGHTING PLAN

SCALE: 1" = 50'
DATE: 1/7/07

DRAWN BY: A.P.
CHECKED BY: G.A.O.

EPSTEIN

A. EPSTEIN AND SONS INTERNATIONAL, INC.
850 WEST FULLTON STREET CHICAGO, ILLINOIS 60609-1186
TEL: 312-464-9100 FAX: 312-659-1217 www.epstein-il.com
CHICAGO LOS ANGELES TEL AVIV WARSAW BUCHAREST

PLOT DATE = 5/15/2007
FILE NAME = #FILE#
USER NAME = #USER#