 



 





F.A. RTE.	SECTION	COUNTY	TOTAL SHEETS	SHEET NO.
2845	3152 WRS	COOK	141	141
STA. 94+00		TO STA. 109+00		
FED. ROAD DIST. NO. 1		ILLINOIS FED. AID PROJECT		

**LEGEND:**

 
-  PROPOSED SINGLE ARM LIGHTING UNIT  
35' MOUNTING HEIGHT, 12' MAST ARM,  
250 W LUMINAIRE METAL HELIX FNDN  
BREAKAWAY TYPE WITH 3' BACK OF  
CURB SETBACK UNLESS OTHERWISE NOTED
-  UNIT DUCT, 600V, TYPE XLP  
4-#6, 1-#6 GRND, 1/2",  
UNLESS OTHERWISE NOTED
-  PROPOSED CONDUIT, GALVANIZED STEEL, PUSHED  
WITH CONDUIT SIZE AND LENGTH SHOWN
-  PROPOSED LIGHTING CONTROLLER, SINGLE DOOR,  
SEE E-1 THROUGH E-9 FOR LOCATIONS
-  CONTROLLER DESIGNATION
-  CIRCUIT DESIGNATION
-  FIXTURE SEQUENCE DESIGNATION

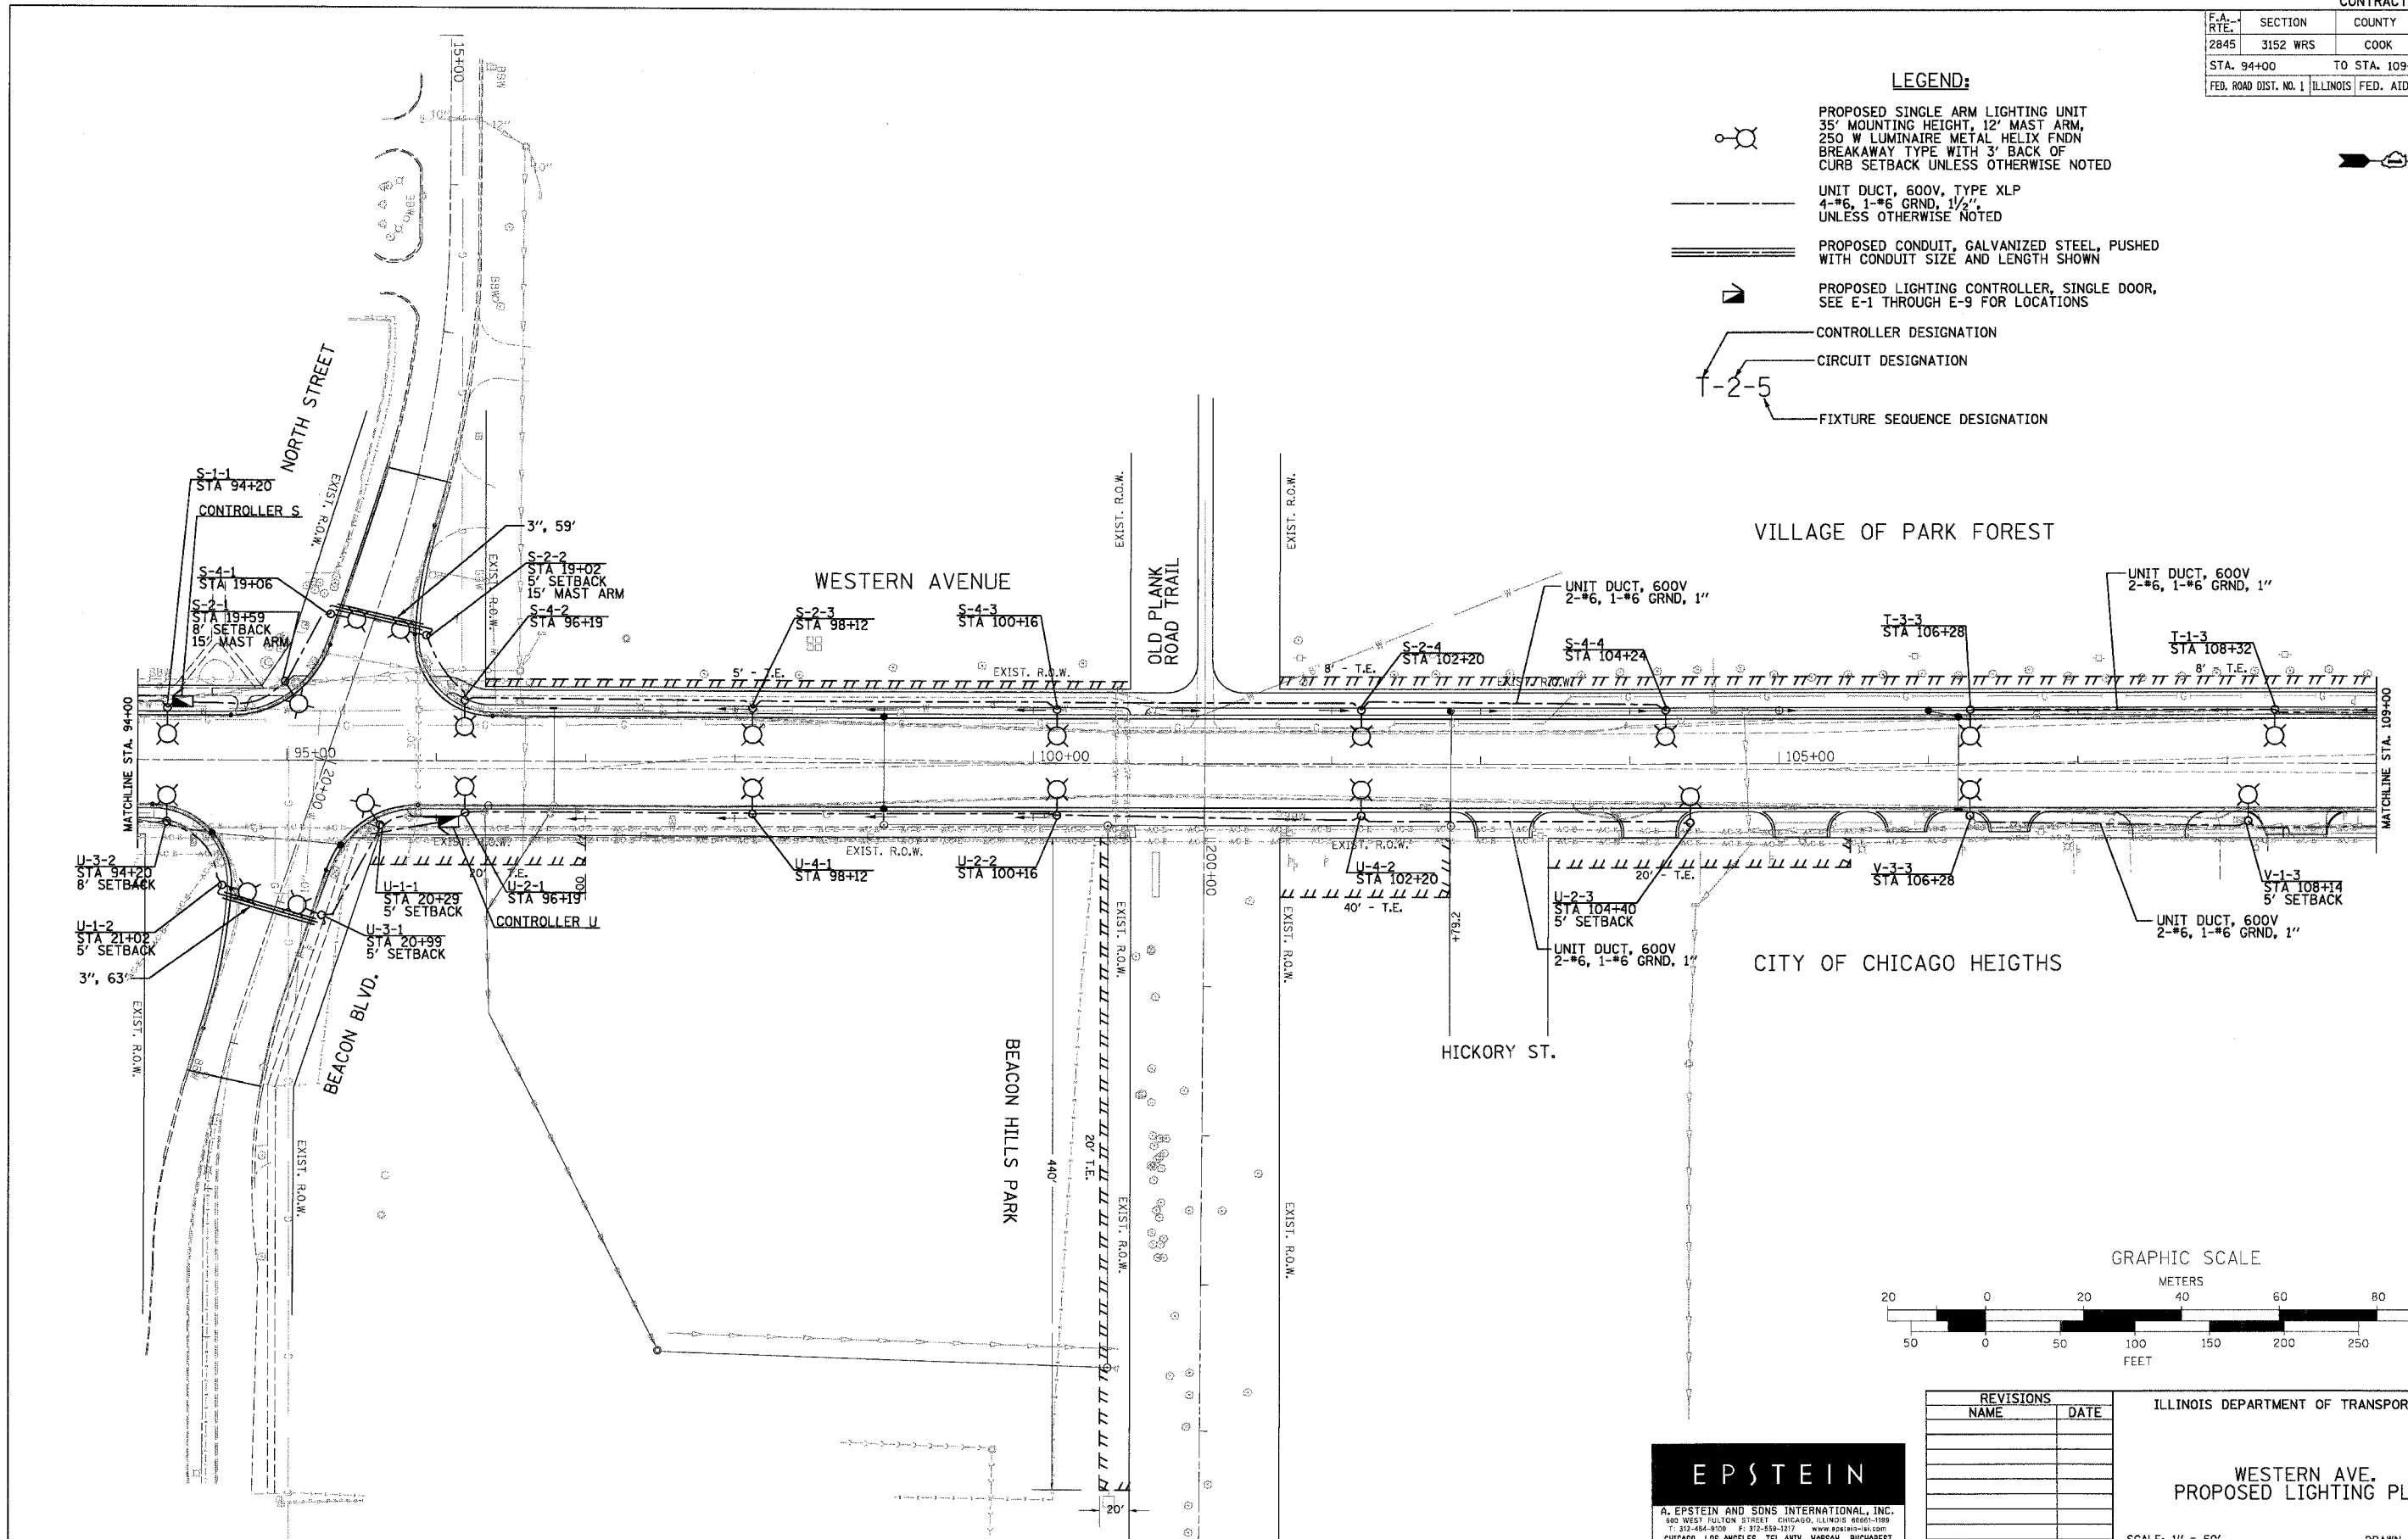

VILLAGE OF PARK FOREST

CITY OF CHICAGO HEIGHTS

GRAPHIC SCALE



E-17

REVISIONS	
NAME	DATE

ILLINOIS DEPARTMENT OF TRANSPORTATION

WESTERN AVE.  
PROPOSED LIGHTING PLAN

SCALE: 1" = 50'  
DATE: 1/7/07

DRAWN BY: A.P.  
CHECKED BY: G.A.O.

**EPSTEIN**  
A. EPSTEIN AND SONS INTERNATIONAL, INC.  
900 WEST FULLON STREET CHICAGO, ILLINOIS 60607-1188  
T: 312-454-9100 F: 312-559-1217 www.epsi-intl.com  
CHICAGO LOS ANGELES TEL AVIV WARSAW BUCHAREST

PLOT DATE = 5/19/2007  
PLOT SCALE = AS SHOWN  
USER NAME = AUSER18