 



F.A. RTE.	SECTION	COUNTY	TOTAL SHEETS	SHEET NO.
2845	3152 WRS	COOK	195	142
STA. 109+00		TO STA. 119+41		
FED. ROAD DIST. NO. 1		ILLINOIS FED. AID PROJECT		



**LEGEND:**

- PROPOSED SINGLE ARM LIGHTING UNIT  
35' MOUNTING HEIGHT, 12' MAST ARM,  
250 W LUMINAIRE METAL HELIX FNDN  
BREAKAWAY TYPE WITH 3' BACK OF  
CURB SETBACK UNLESS OTHERWISE NOTED
- UNIT DUCT, 600V, TYPE XLP  
4-#6, 1-#6 GRND, 1/2",  
UNLESS OTHERWISE NOTED
- PROPOSED CONDUIT, GALVANIZED STEEL, PUSHED  
WITH CONDUIT SIZE AND LENGTH SHOWN
- PROPOSED LIGHTING CONTROLLER, SINGLE DOOR,  
SEE E-1 THROUGH E-9 FOR LOCATIONS
- CONTROLLER DESIGNATION
- CIRCUIT DESIGNATION
- FIXTURE SEQUENCE DESIGNATION

 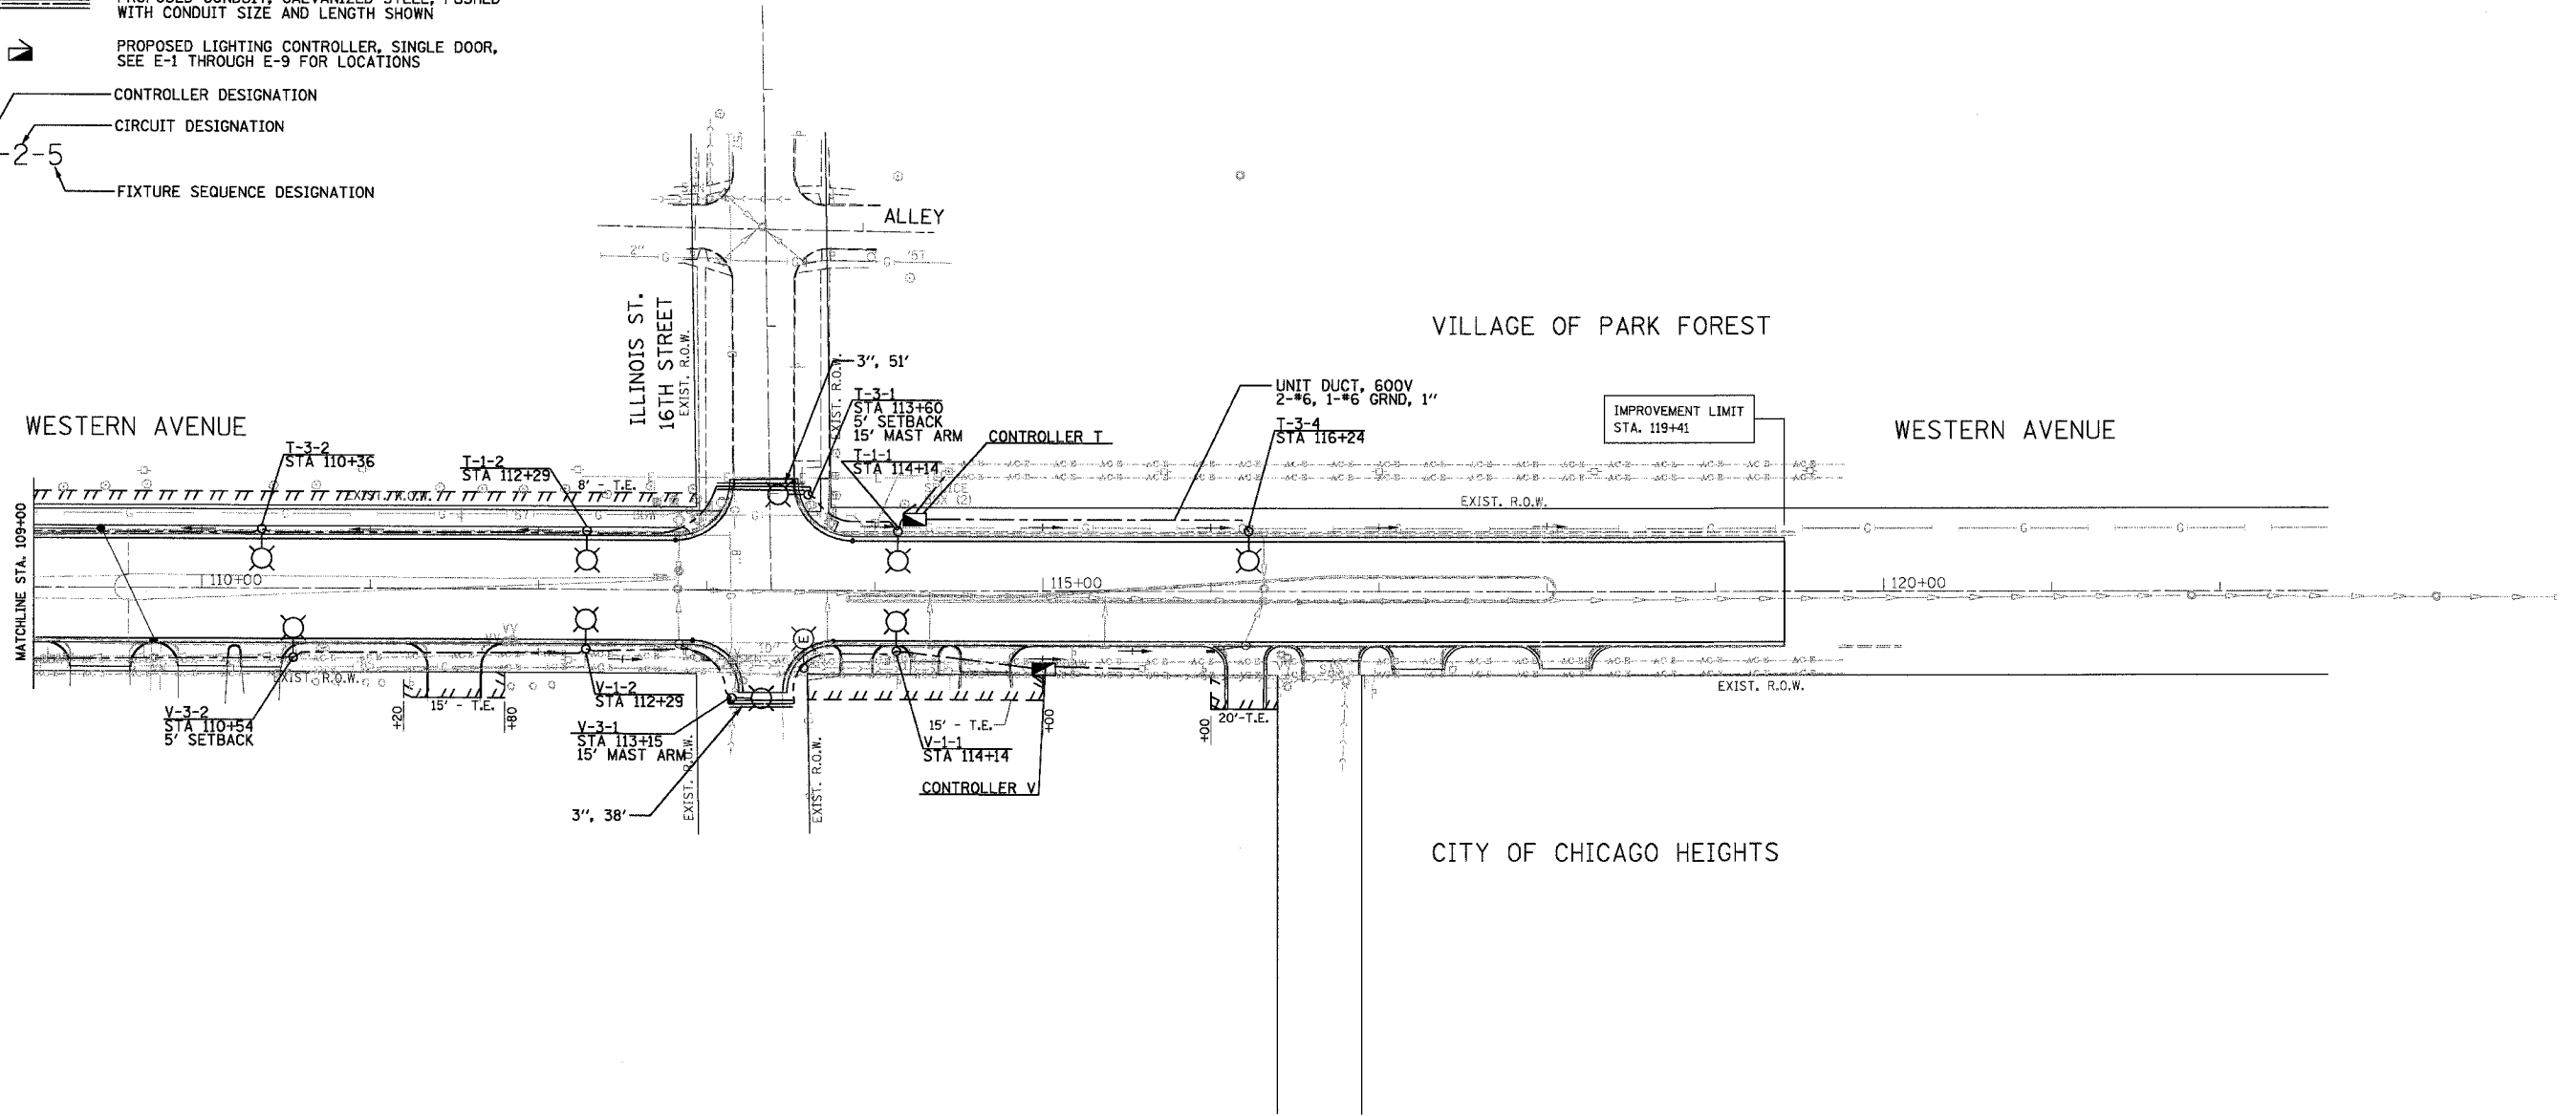


VILLAGE OF PARK FOREST

WESTERN AVENUE

CITY OF CHICAGO HEIGHTS

GRAPHIC SCALE



E-18

PLOT DATE = 8/18/07  
FILE NAME = WEST.AVE  
PLOT SCALE = 1"=50'  
USER NAME = JUBER

**EPSTEIN**  
A. EPSTEIN AND SONS INTERNATIONAL, INC.  
420 WEST FULTON STREET, CHICAGO, ILLINOIS 60661-1788  
T: 312-464-3900 F: 312-669-1217 www.epstein-ai.com  
CHICAGO LOS ANGELES TEL AVIV WARSAW BUCHAREST

REVISIONS	
NAME	DATE

ILLINOIS DEPARTMENT OF TRANSPORTATION

WESTERN AVE.  
PROPOSED LIGHTING PLAN

SCALE: 1" = 50'  
DATE: 1/7/07

DRAWN BY: A.P.  
CHECKED BY: G.A.O.