


F.A. RTE.	SECTION	COUNTY	TOTAL SHEETS	SHEET NO.
2845	3152 WRS	COOK	195	197
STA. -		TO STA. -		
FED. ROAD DIST. NO. 1		ILLINOIS	FED. AID PROJECT	

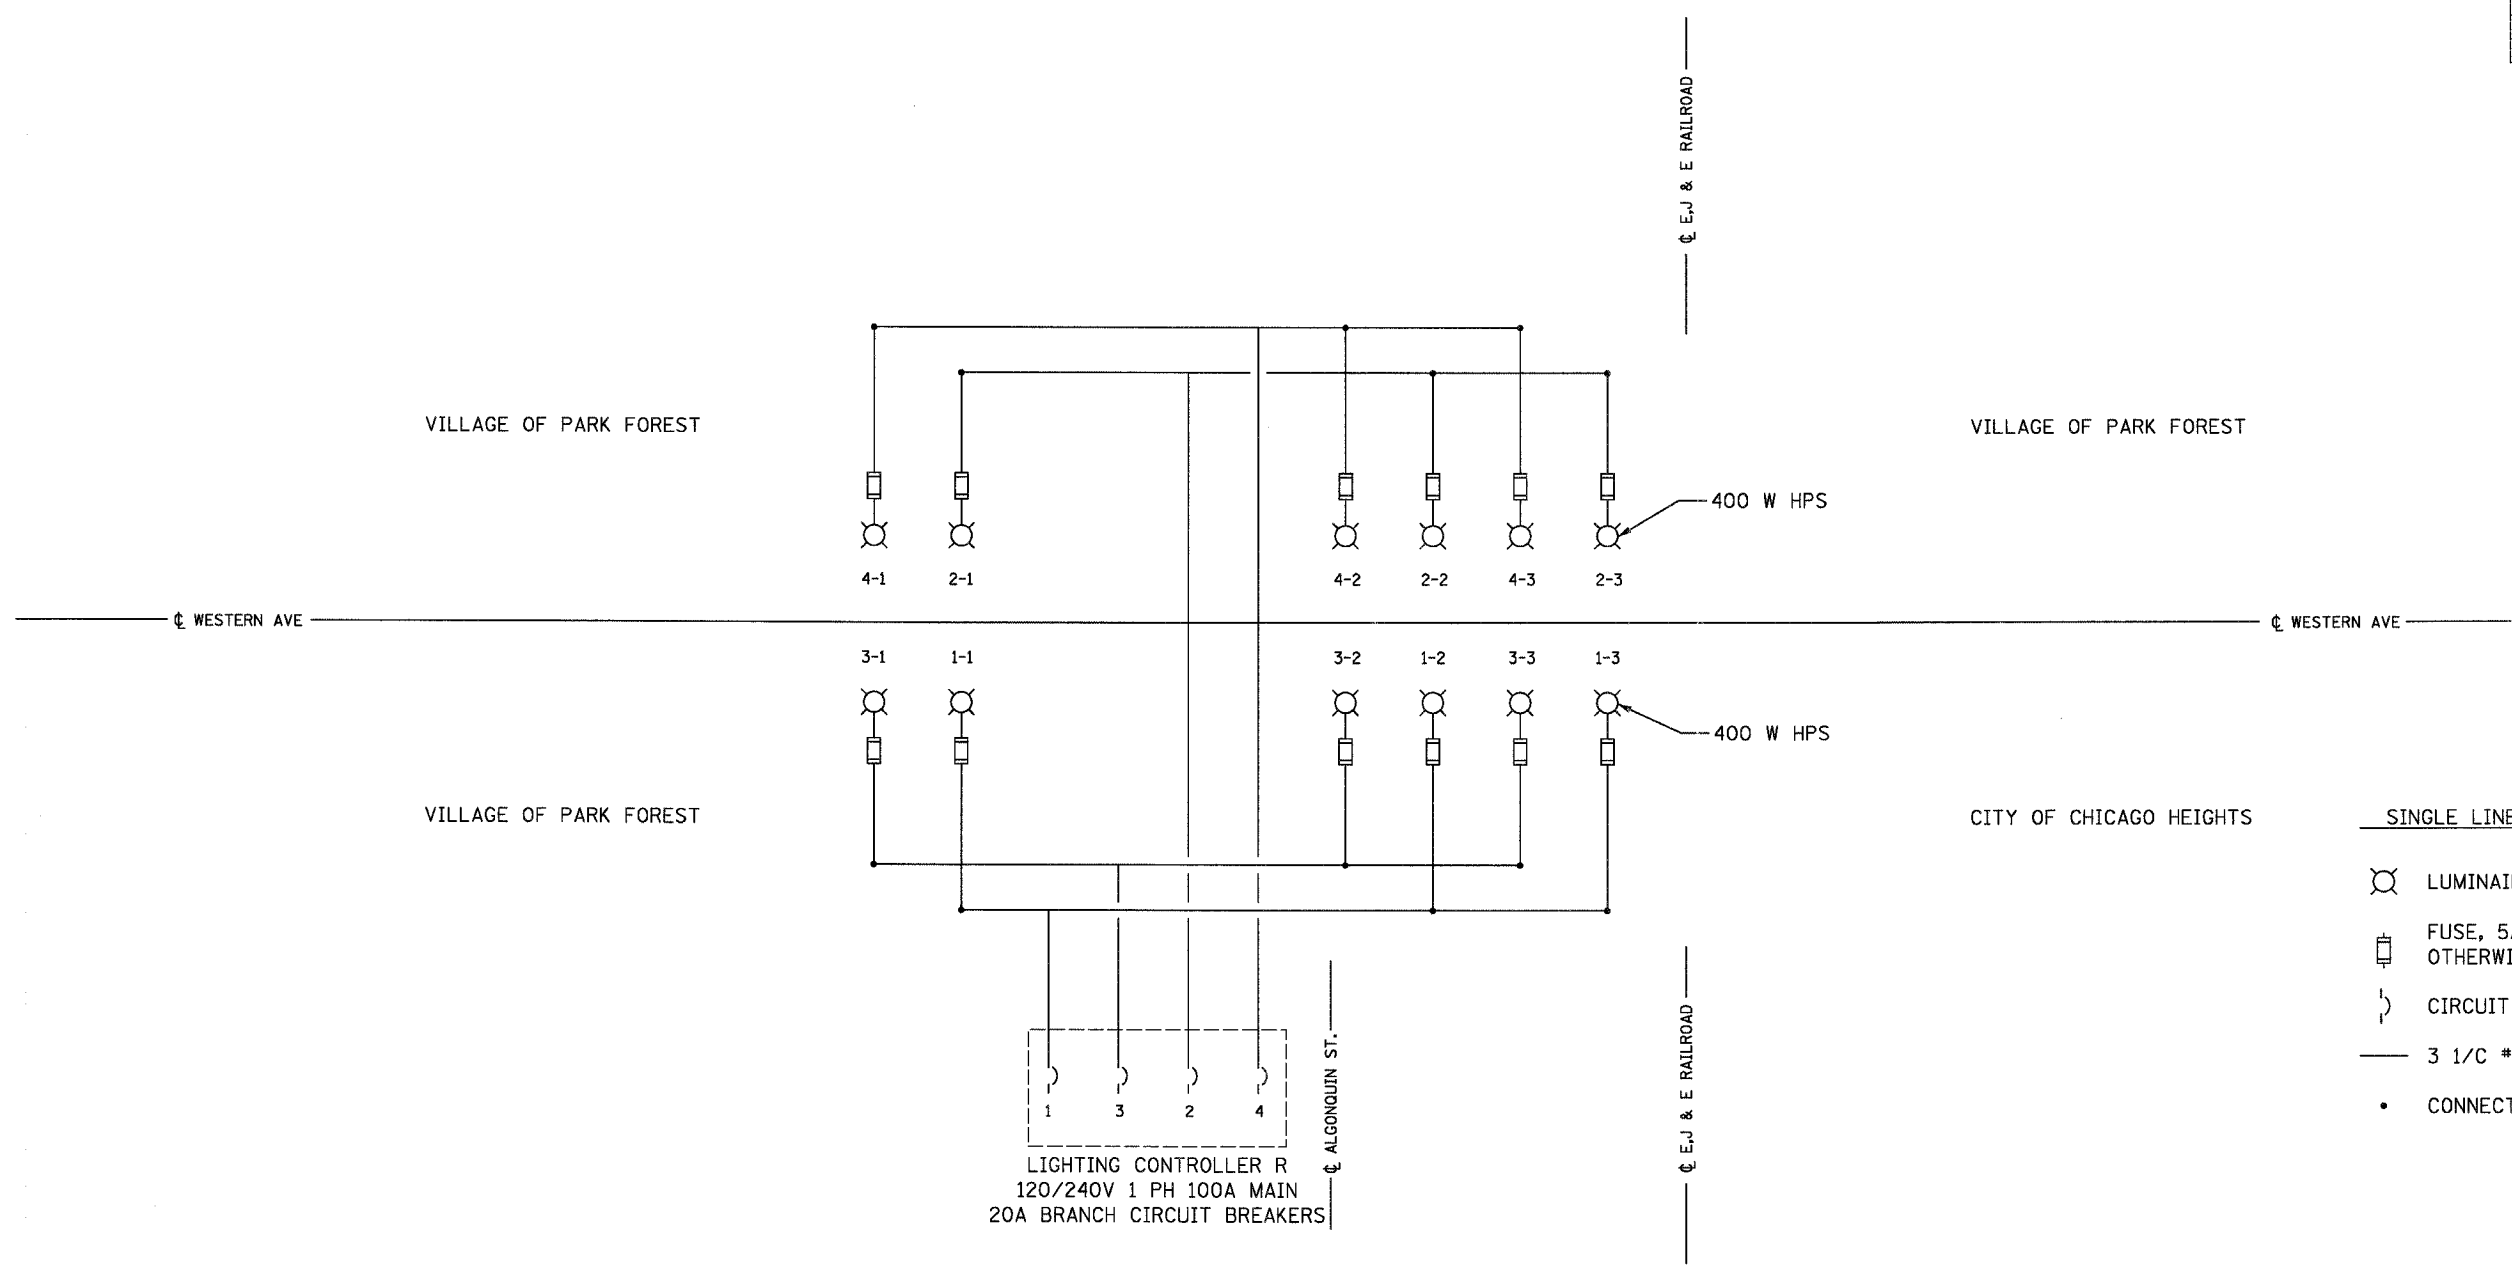

- SINGLE LINE LEGEND**
- LUMINAIRE, 250 W HPS, U.O.N.
 - FUSE, 5A UNLESS OTHERWISE INDICATED
 - CIRCUIT BREAKER
 - 3 1/C #6 & 1/C #6 GND
 - CONNECTION

LOAD TABULATION CONTROLLER R	
CIRCUIT	LOAD (WATTS)
R-1	1176
R-2	1176
R-3	1008
R-4	1008

EPSTEIN
 A. EPSTEIN AND SONS INTERNATIONAL, INC.
 808 WEST FULTON STREET CHICAGO, ILLINOIS 60611-1999
 F: 312-454-9100 F: 312-456-1317 www.epstein-intl.com
 CHICAGO LOS ANGELES TEL AVIV WARSAW BUCHAREST

REVISIONS	
NAME	DATE

ILLINOIS DEPARTMENT OF TRANSPORTATION
**WESTERN AVE.
 ONE LINE DIAGRAM
 CONTROLLER R**
 SCALE: N.T.S. DRAWN BY: A.P.
 DATE: 1/7/07 CHECKED BY: G.A.O.

PLOT DATE = 5/19/2007
 FILE NAME = 071011
 PLOT SCALE = 1/8"=1'-0"
 USER NAME = MJSER