
 


F.A.P. RTE.	SECTION	COUNTY	TOTAL SHEETS	SHEET NO.
..	9	4
STA.		TO STA.		
FED. ROAD DIST. NO.	ILLINOIS	FED. AID PROJECT		
** DIST 8 DEEP WELLS 2008-1 *** MADISON & ST. CLAIR				

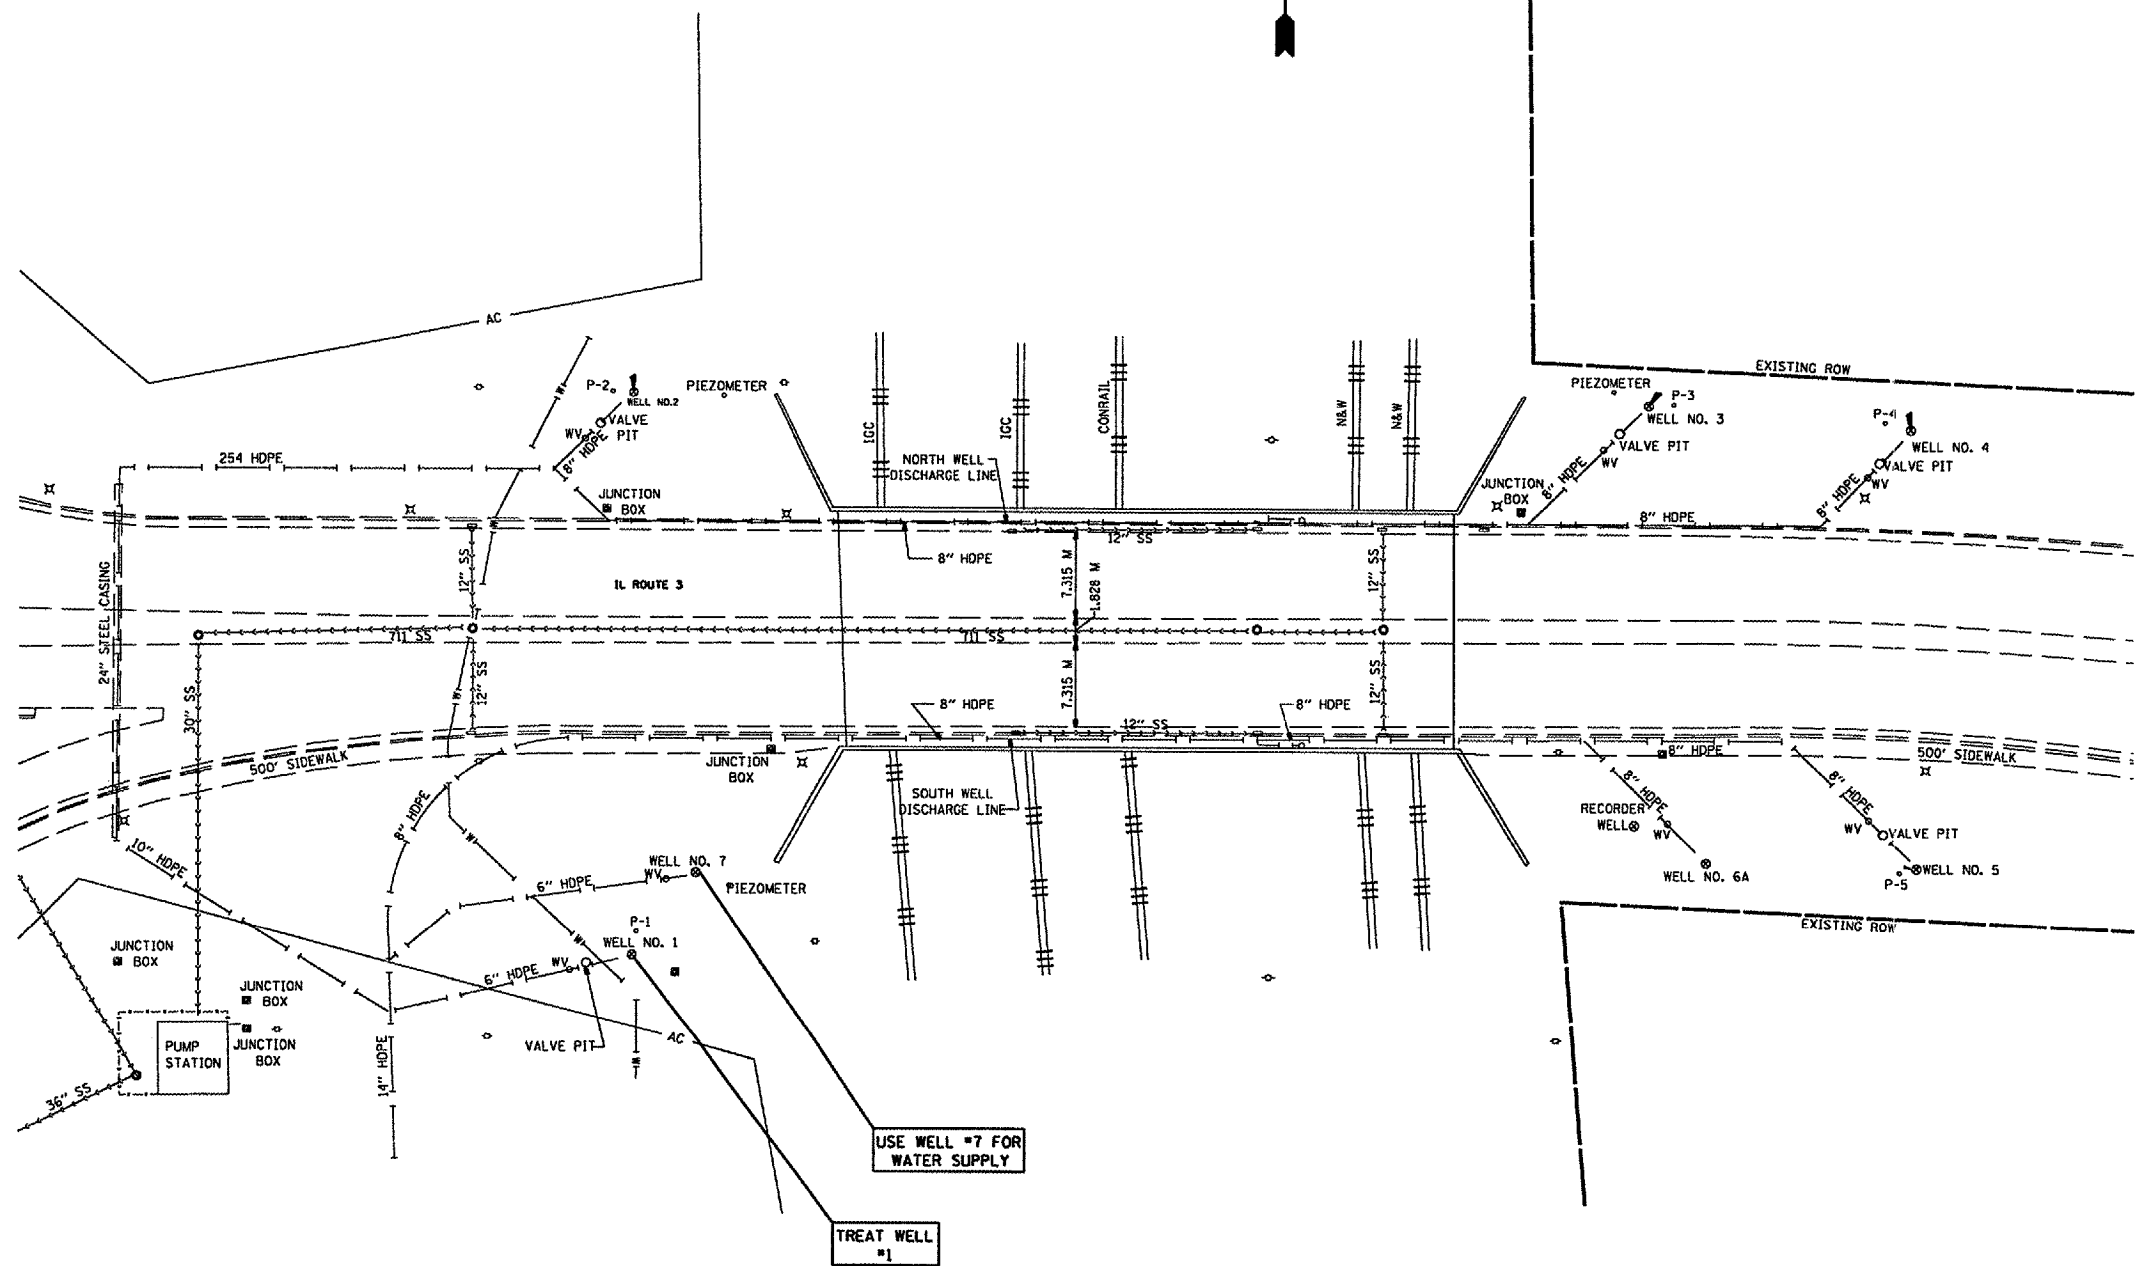

NOTE: HOSE FOR SUPPLY WATER MAY BE PLACED ON SIDE WALK WHILE IN USE, BUT MUST BE REMOVED OVER NIGHT.

LOCATION	ADDITIONAL TREATMENT NO.1	ADDITIONAL TREATMENT NO. 2	WELL CHEMICAL TREATMENT	WELL CHEMICAL TREATMENT SPECIAL	SONAR JET TREATMENT
WELL #1	X	X	X		



ILLINOIS DEPARTMENT OF TRANSPORTATION
LOCATION 1 SITE PLAN
VENICE WELLS (IL RTE 3)
 VARIOUS ROUTES
 DISTRICT 8 DEEP WELLS 2008-1
 MADISON & ST. CLAIR COUNTY

REVISIONS	
NAME	DATE

DRAWN BY:
 PLOT DATE: *DATE-TIME*

PLAN	DATE
REVISION	BY
NO.	
NO.	
DATE-TIME
 DRAW-SPEC
 REF-REF