


SECTION	COUNTY	TOTAL SHEETS	SHEET NO.
06-00052-00-LT	COOK	10	5
LANDMEIER ROAD			
LIGHTING PLAN			

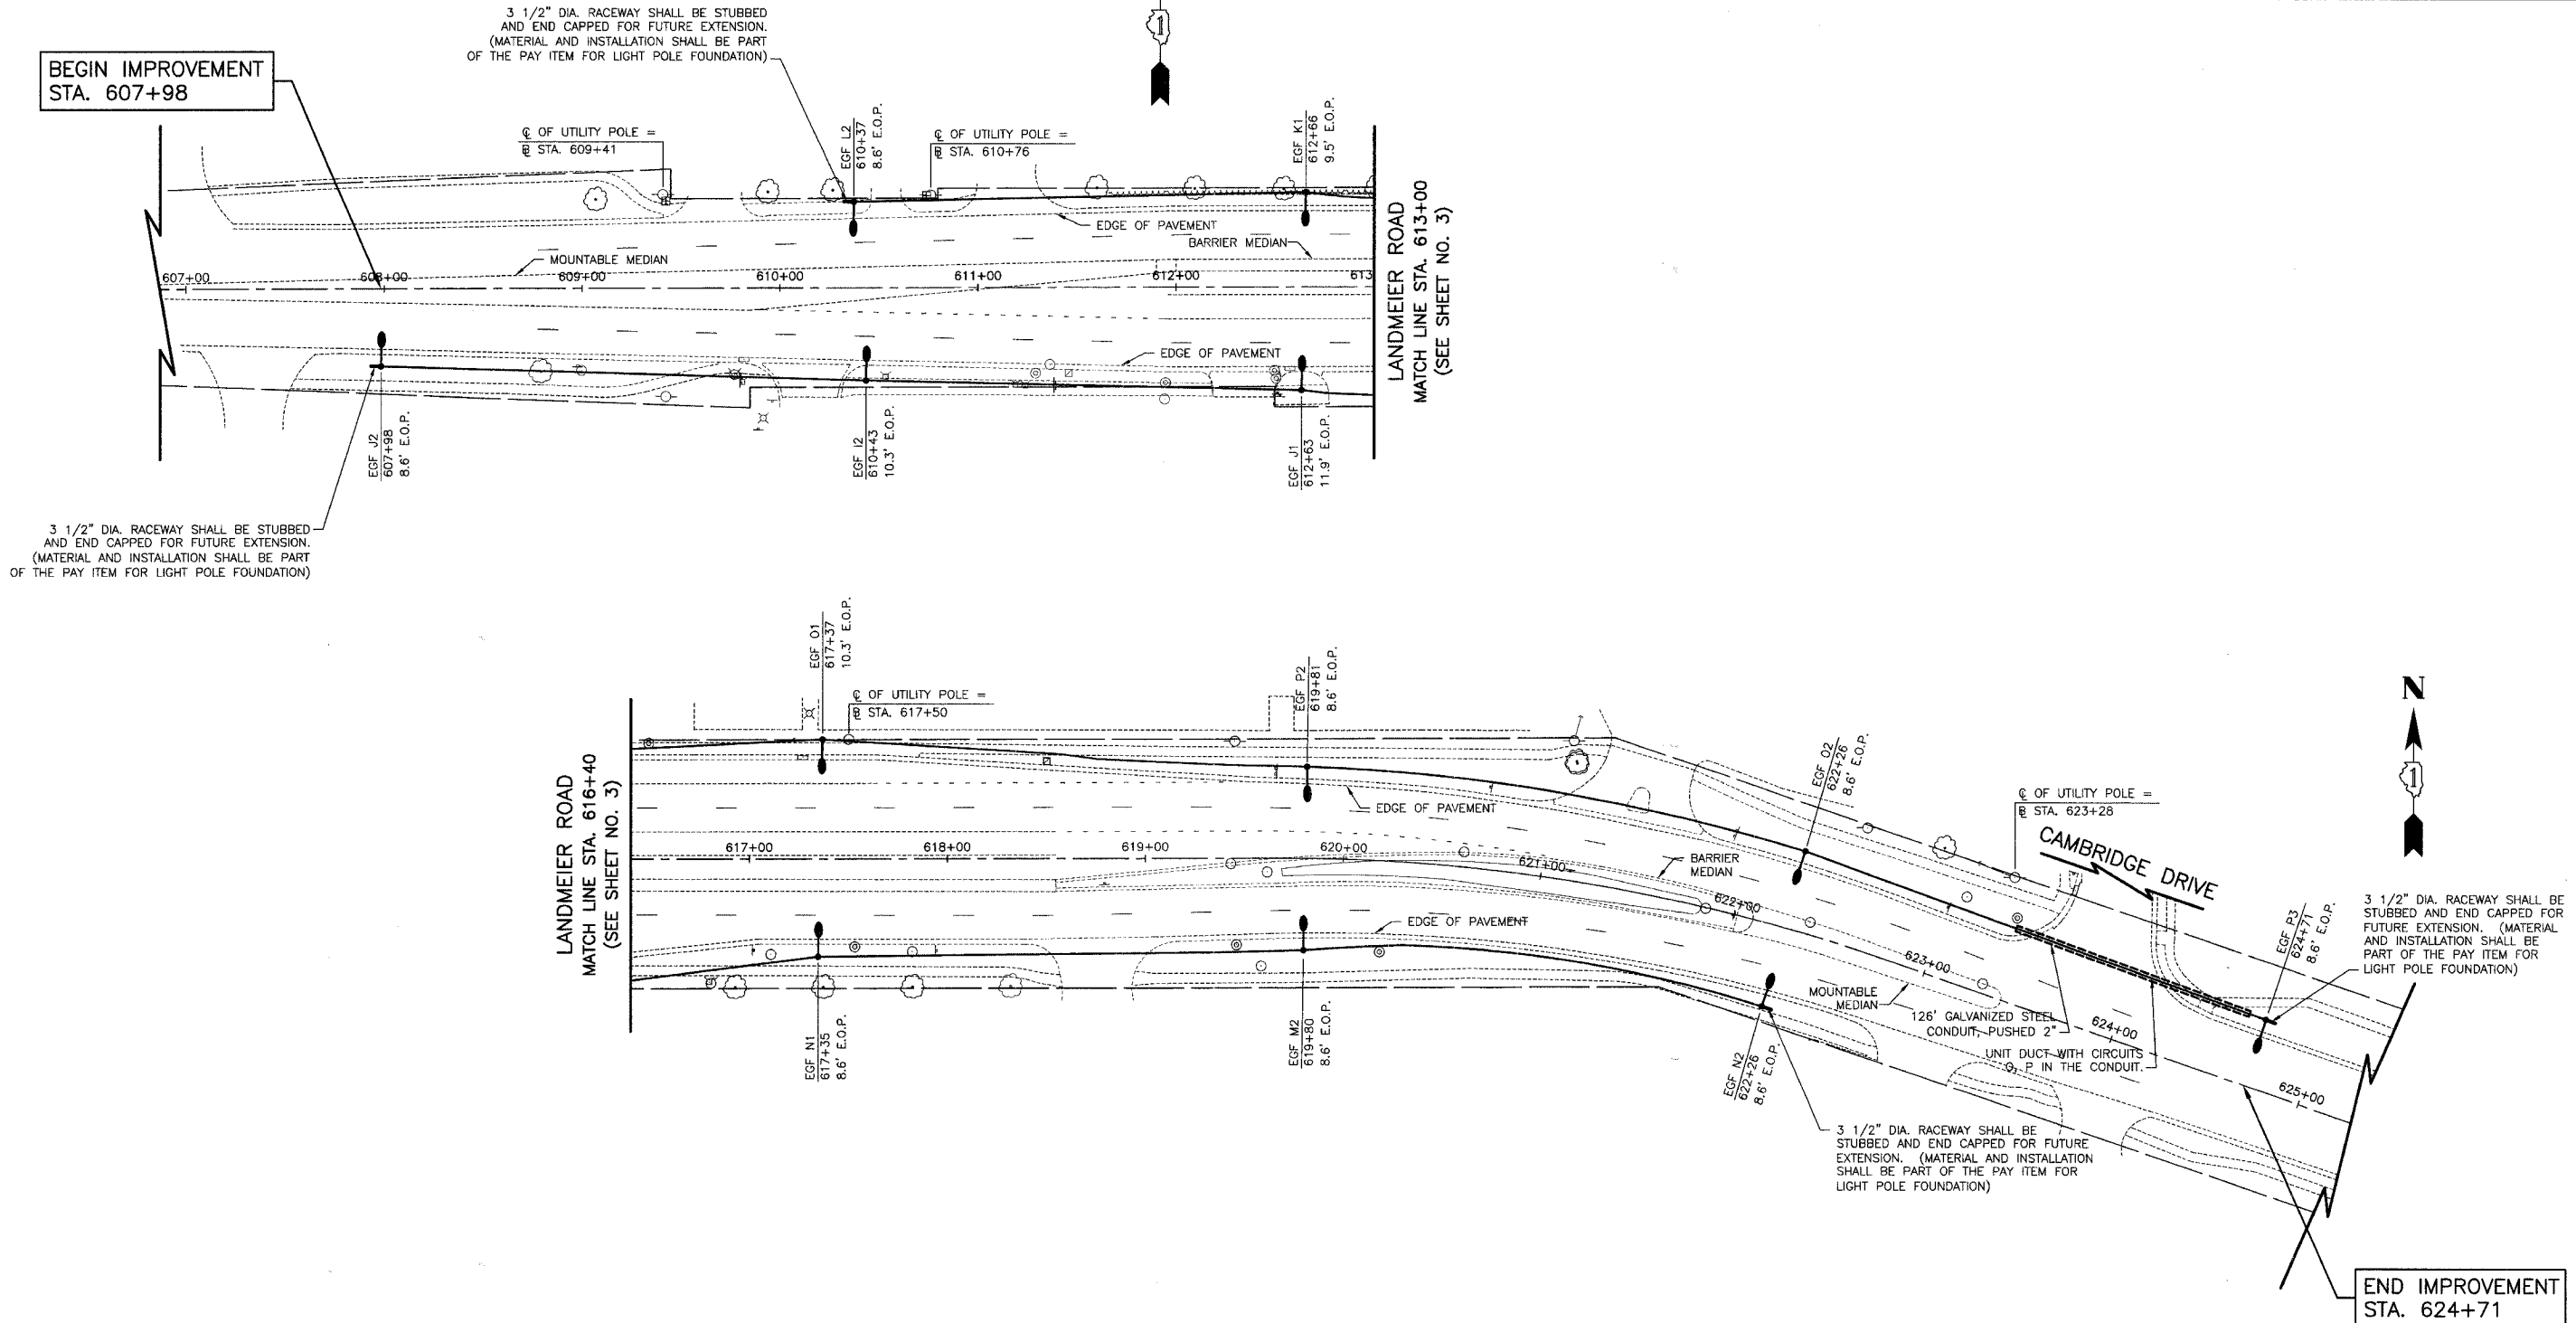

REVISIONS	
NAME	DATE

ILLINOIS DEPARTMENT OF TRANSPORTATION
 BUSSE ROAD (IL 83)
 ROADWAY LIGHTING
LIGHTING PLAN
 LANDMEIER ROAD
 STA. 607+98 TO STA. 624+71

DATE: 07/10/2007
 CHECKED BY: D.N.M.

SCALE IN FEET



.:\shared\cadd\work\sharkey\0606\busse_road\lighting\plan\05.dwg
 11/11/07 11:26:20 AM
 11/11/07 11:26:20 AM