

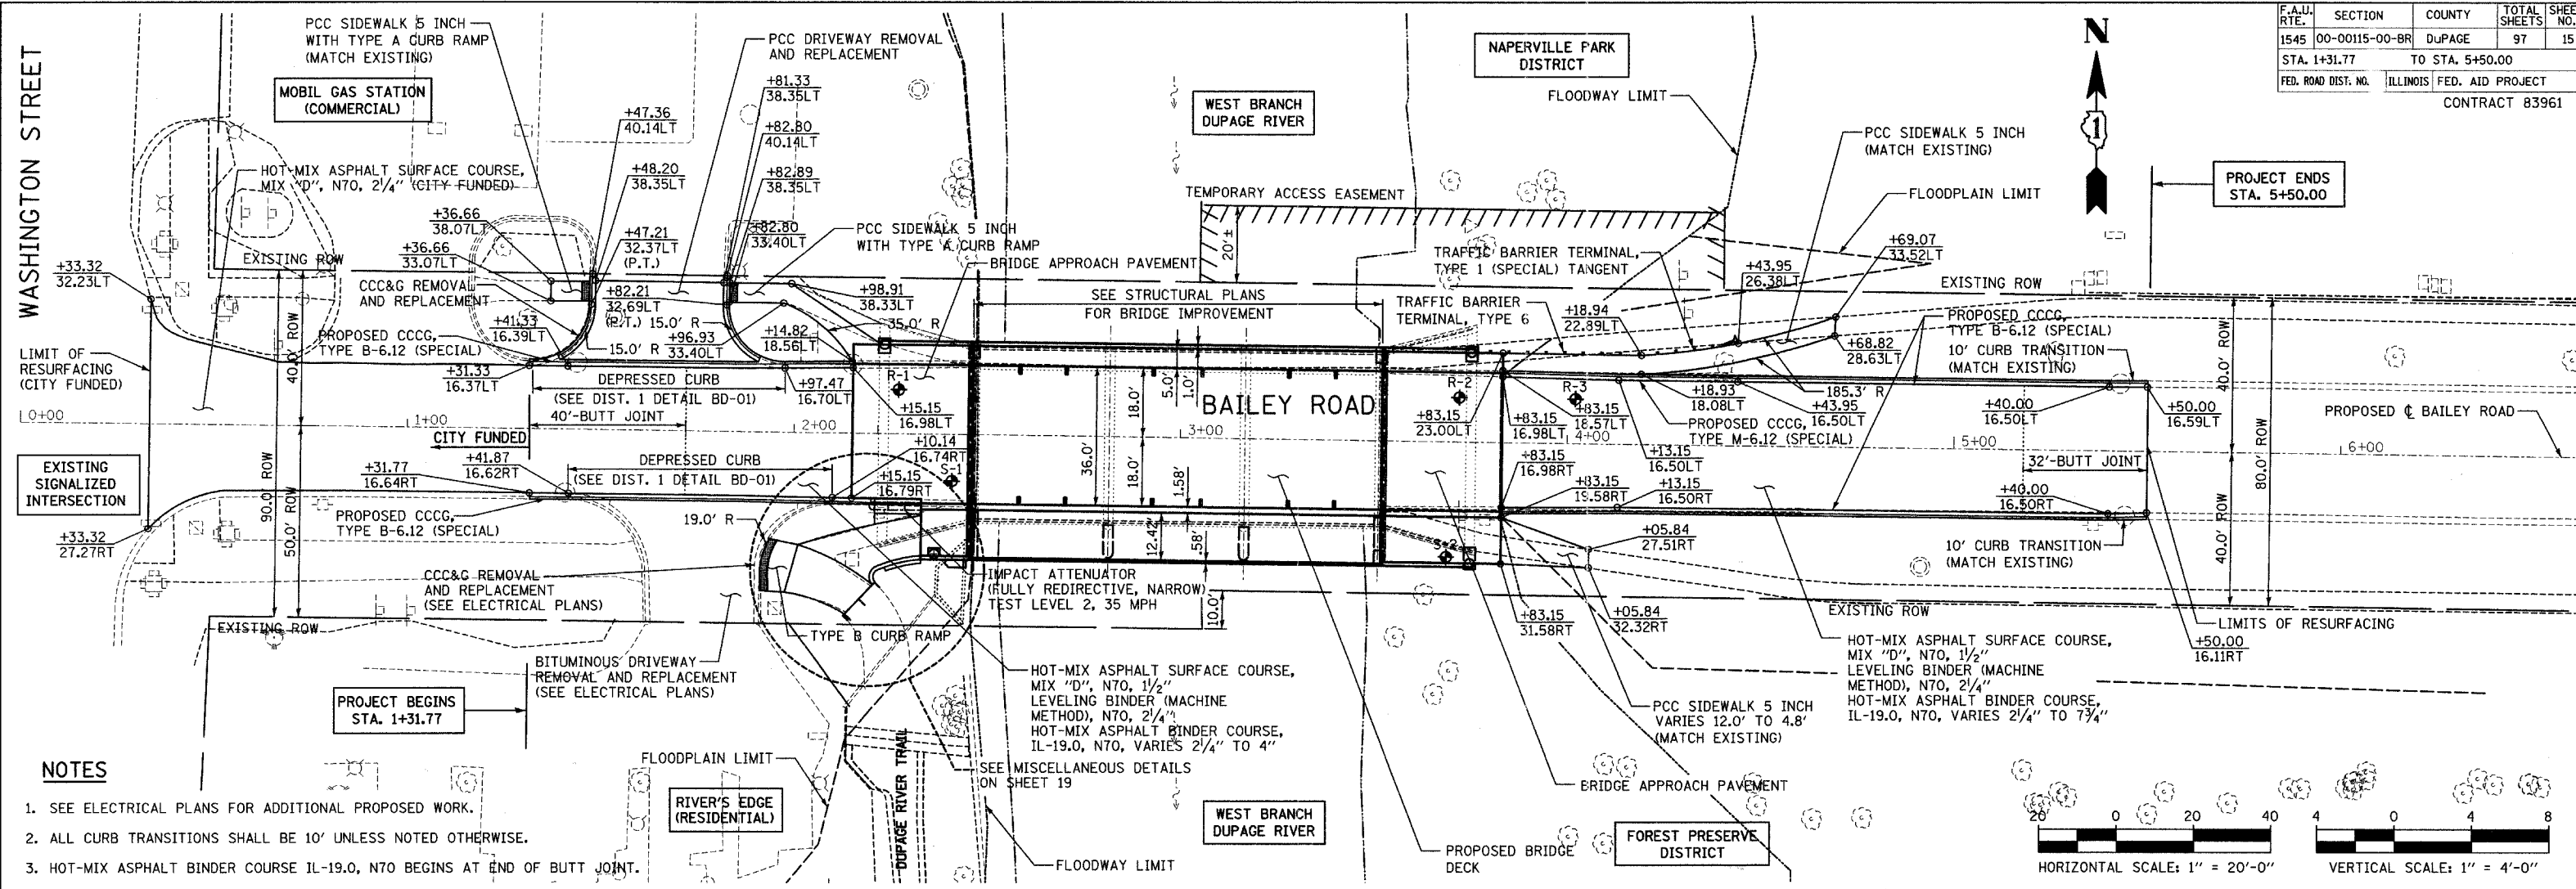



F.A.U. RTE.	SECTION	COUNTY	TOTAL SHEETS	SHEET NO.
1545	00-00115-00-8R	DUPAGE	97	15
STA. 1+31.77		TO STA. 5+50.00		
FED. ROAD DIST. NO.	ILLINOIS	FED. AID PROJECT	CONTRACT 83961	

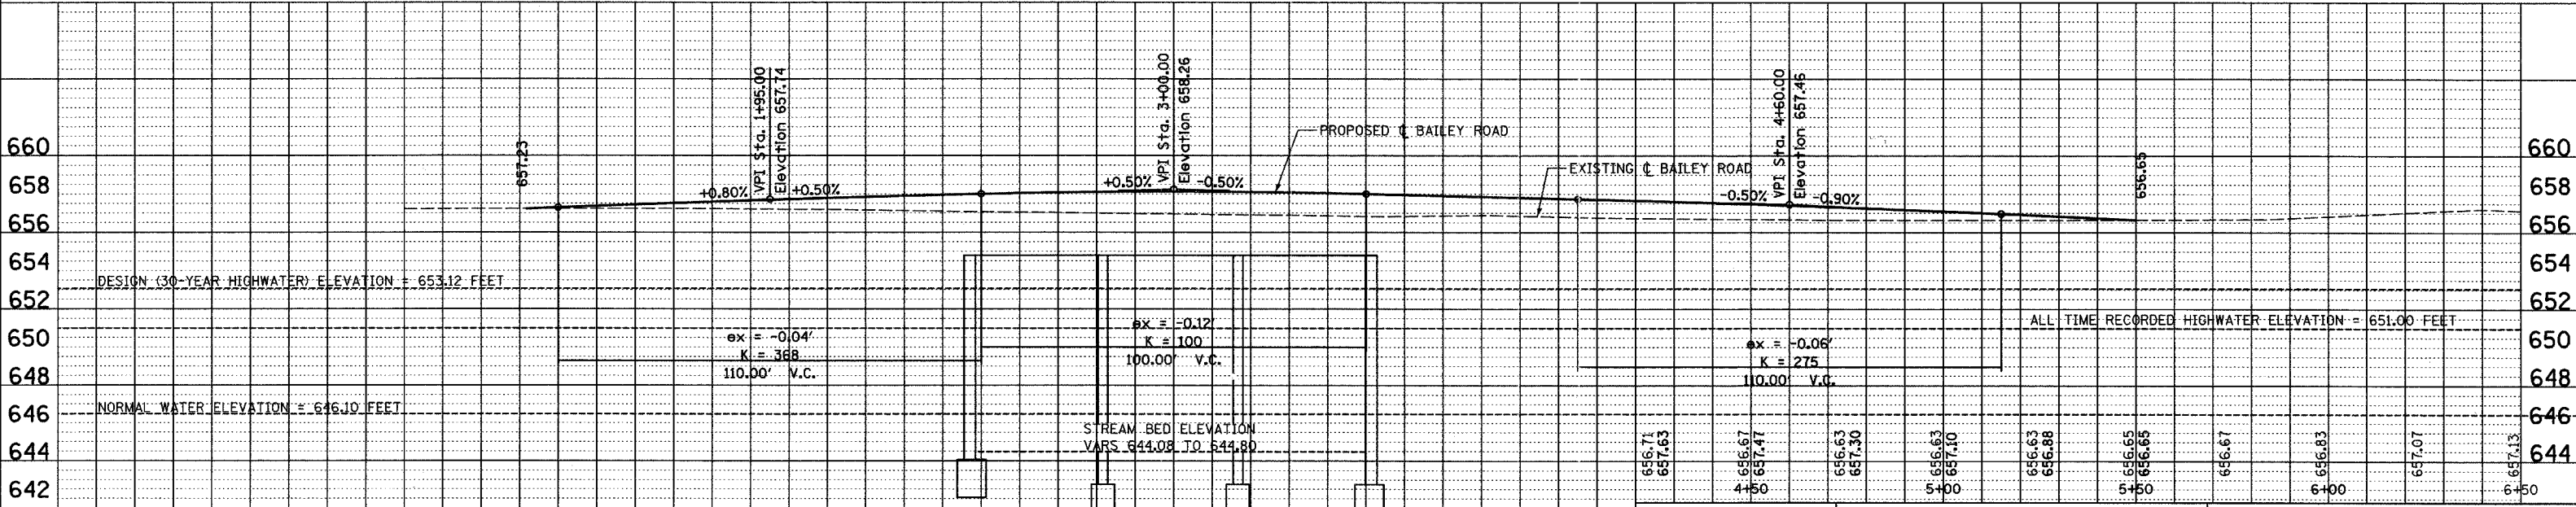

- NOTES**
- SEE ELECTRICAL PLANS FOR ADDITIONAL PROPOSED WORK.
  - ALL CURB TRANSITIONS SHALL BE 10' UNLESS NOTED OTHERWISE.
  - HOT-MIX ASPHALT BINDER COURSE IL-19.0, N70 BEGINS AT END OF BUTT JOINT.

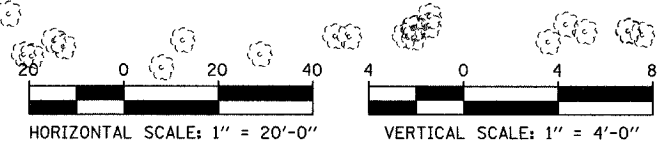

<b>REVISIONS</b> NAME DATE		<b>BRIDGE REHABILITATION          BAILEY ROAD OVER          WEST BRANCH OF THE DUPAGE RIVER</b>	City of  <b>Naperville</b>
<b>PROPOSED PLAN AND PROFILE</b>			
DRAWN: RTM CHECKED: SP		SHEET NO. <b>15</b>	
APPROVED:		DATE: JULY 13, 2007	
SCALE: HORIZ. 1"=20'-0" VERT. 1"=4'-0"		JOB NO.: C-91-062-04 PROJECT NO.: BHM-8003(343)	
CONSULTANT <b>TYLIN INTERNATIONAL</b>			