
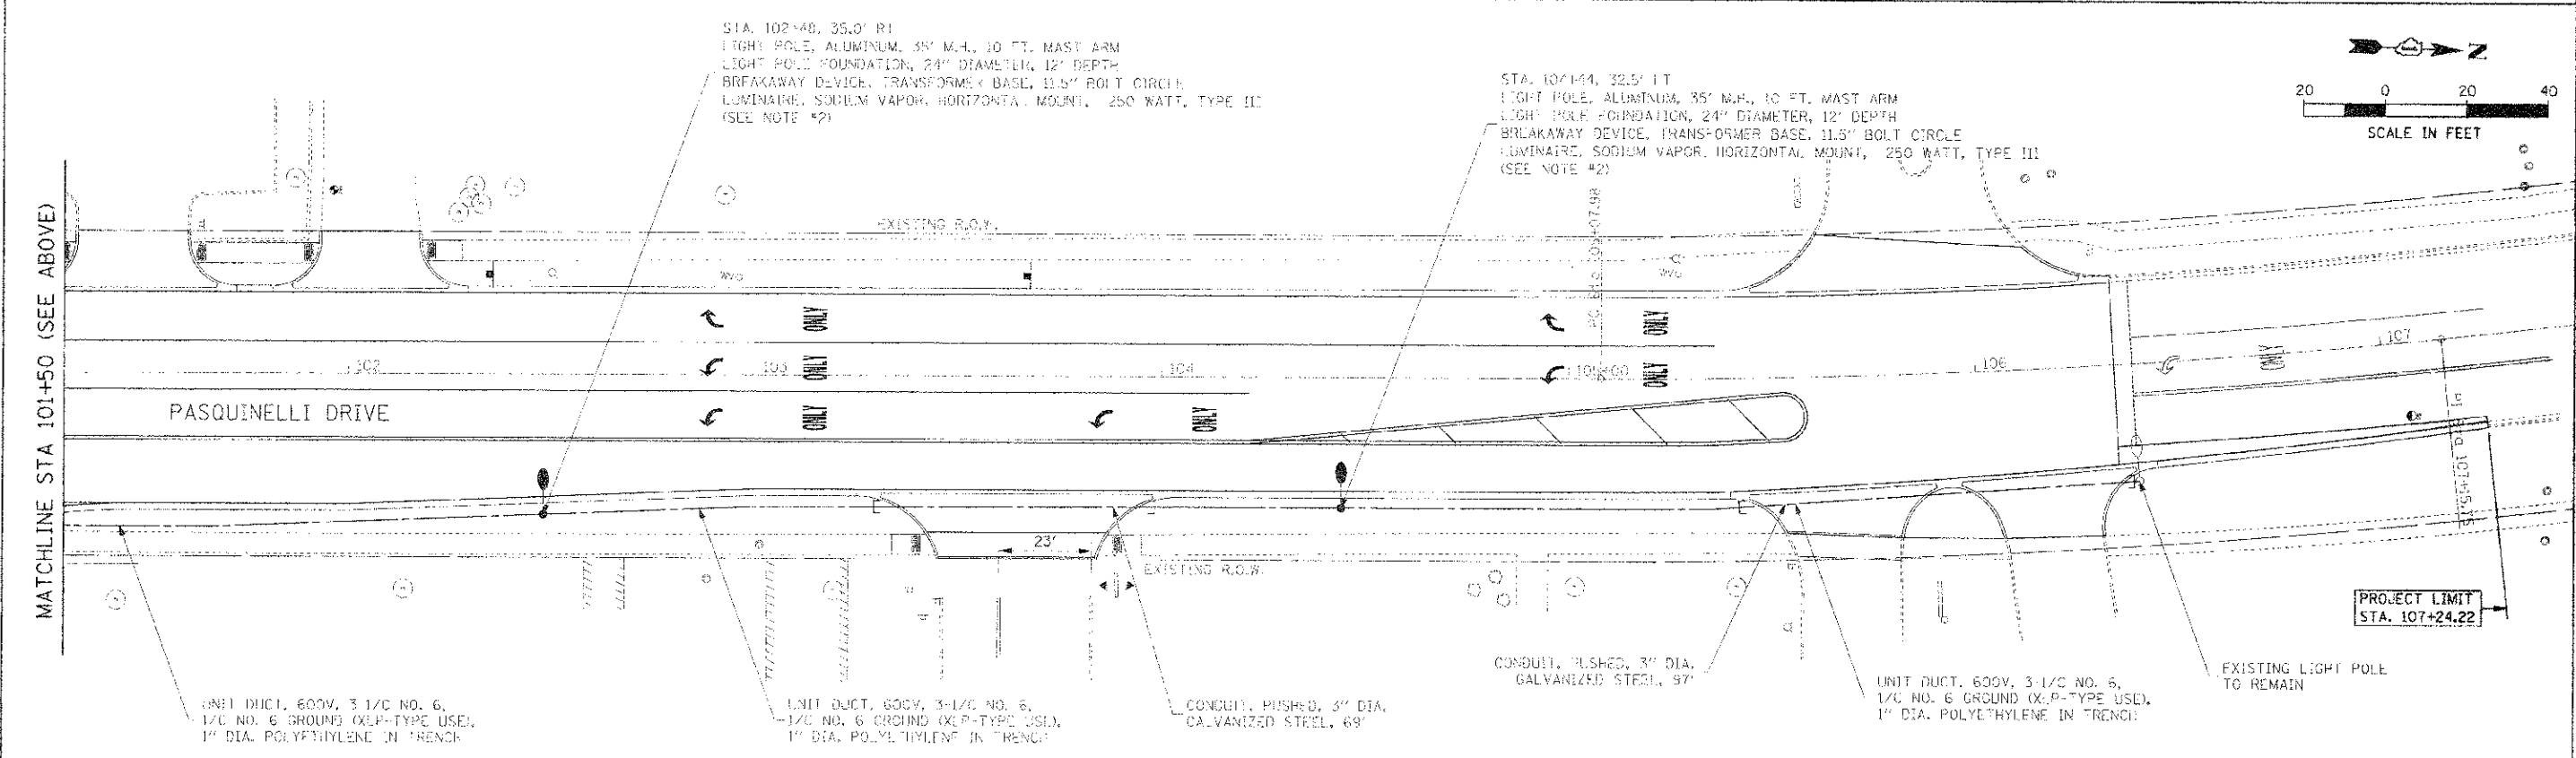


PROJECT FILE: 00000000  
 NOTE: 9000  
 DATE: 03/28/11

PROJECT FILE: 00000000  
 NOTE: 9000  
 DATE: 03/28/11

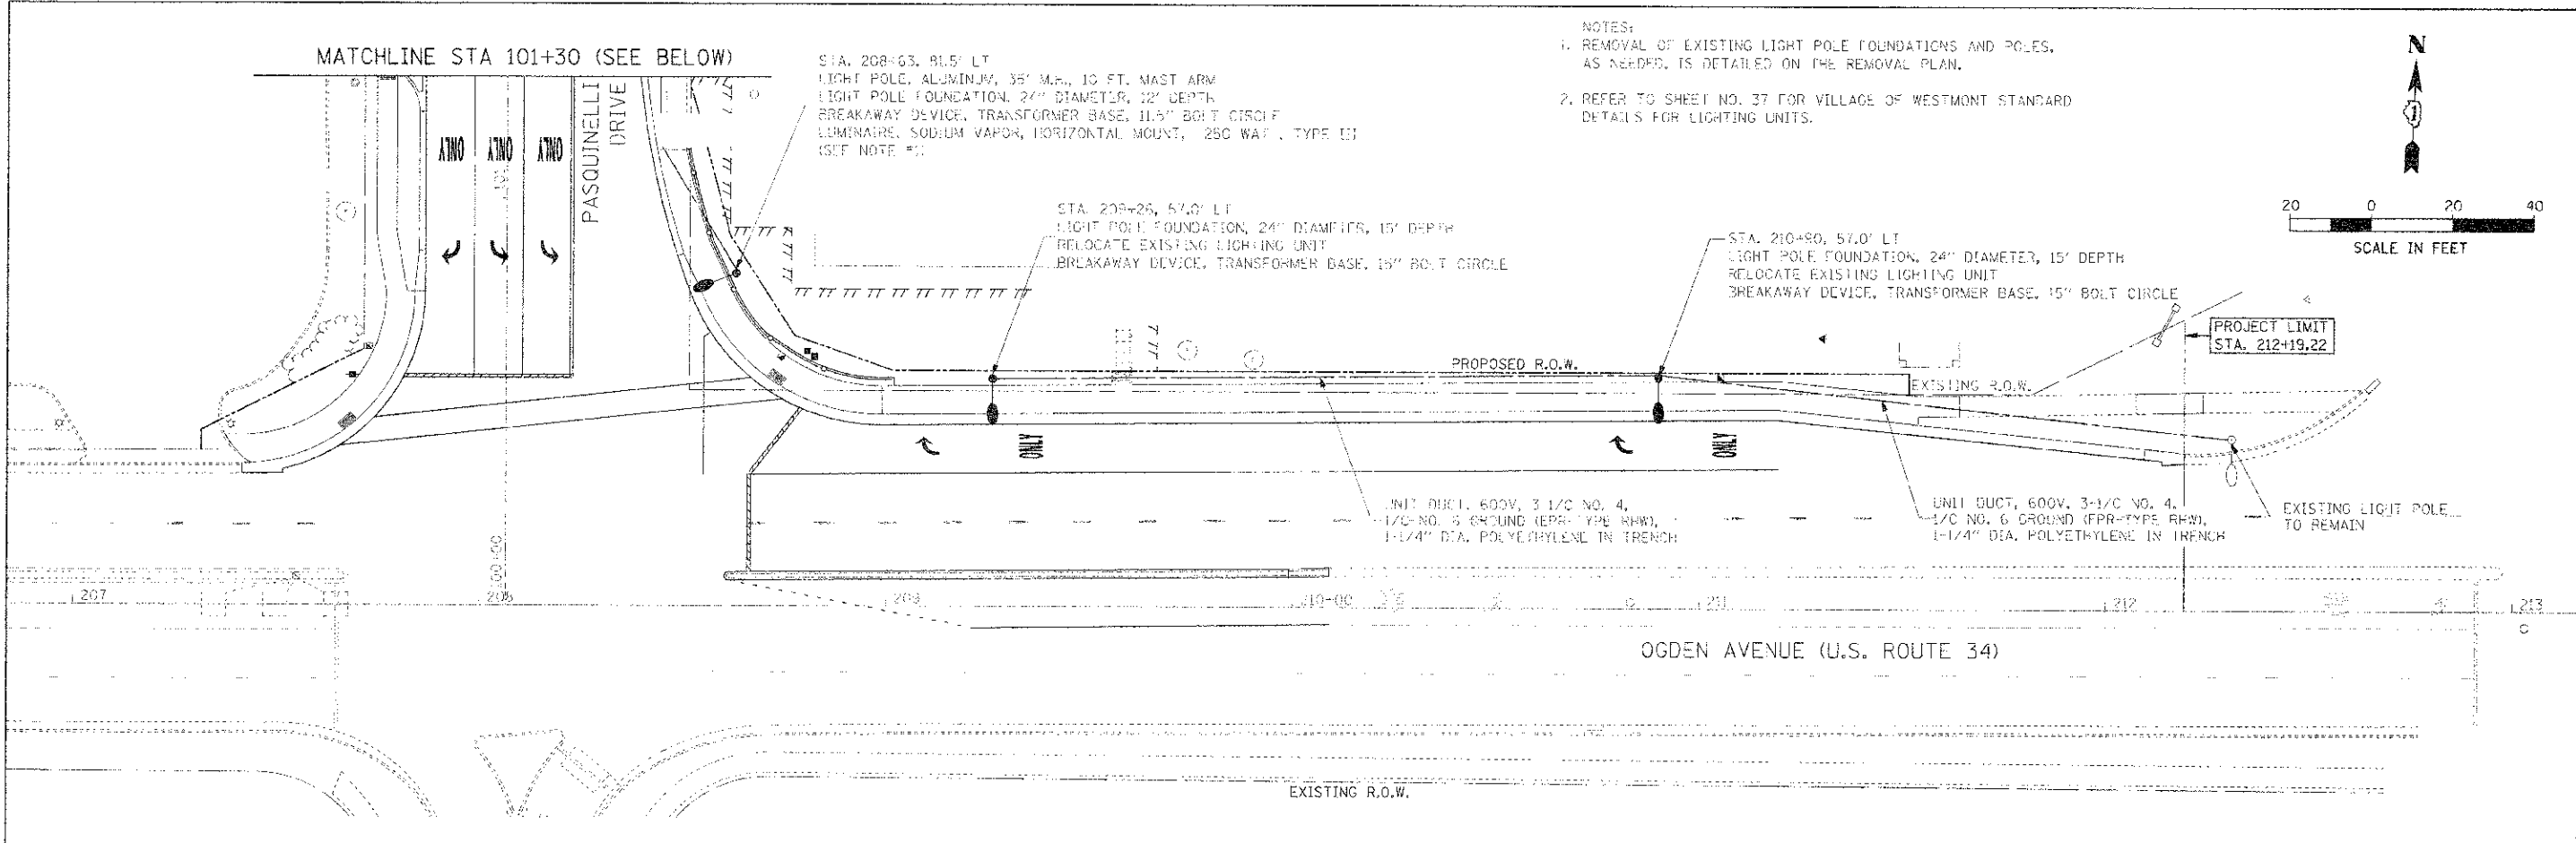

	1431 OPUS PLACE, SUITE 400 DOWNERS GROVE, IL 60515 PHONE: (630) 724-3200 FAX: (630) 724-3201 WEB: WWW.BURNSMCD.COM	USER NAME: JMT FILE NAME: 0-FILE PLOT SCALE: AS SHOWN PLOT DATE: 03/28/11	DESIGNED: JMT DRAWN: JMT CHECKED: MAP DATE: 03/28/11	REVISED: JMT REVISED: JMT REVISED: JMT REVISED: JMT	<b>STATE OF ILLINOIS</b> <b>DEPARTMENT OF TRANSPORTATION</b>	<b>PASQUINELLI DRIVE RECONSTRUCTION</b> <b>PROPOSED LIGHTING PLAN</b>	FULL R.T.E.: 3002 SECTION: 00-0083-00-PV COUNTY: DUPAGE TOTAL SHEETS: 73 SHEET NO.: 38 CONTRACT NO.: 63579
	SCALE: 1"=20' SHEET NO. 1 OF 1 SHEETS STA. 100+00.00 TO STA. 107+25.00					ILLINOIS FED. AID PROJECT	