



F.A.I. RTE.	SECTION	COUNTY	TOTAL SHEETS	SHEET NO.
90/94		COOK	312	95
STA. 4436+75		TO STA. 4441+50		
FED. ROAD DIST. NO. 1 ILLINOIS FED. AID PROJECT				
60A62 • (19)9.15, 2021-922 PT1 & PT2) R-1				

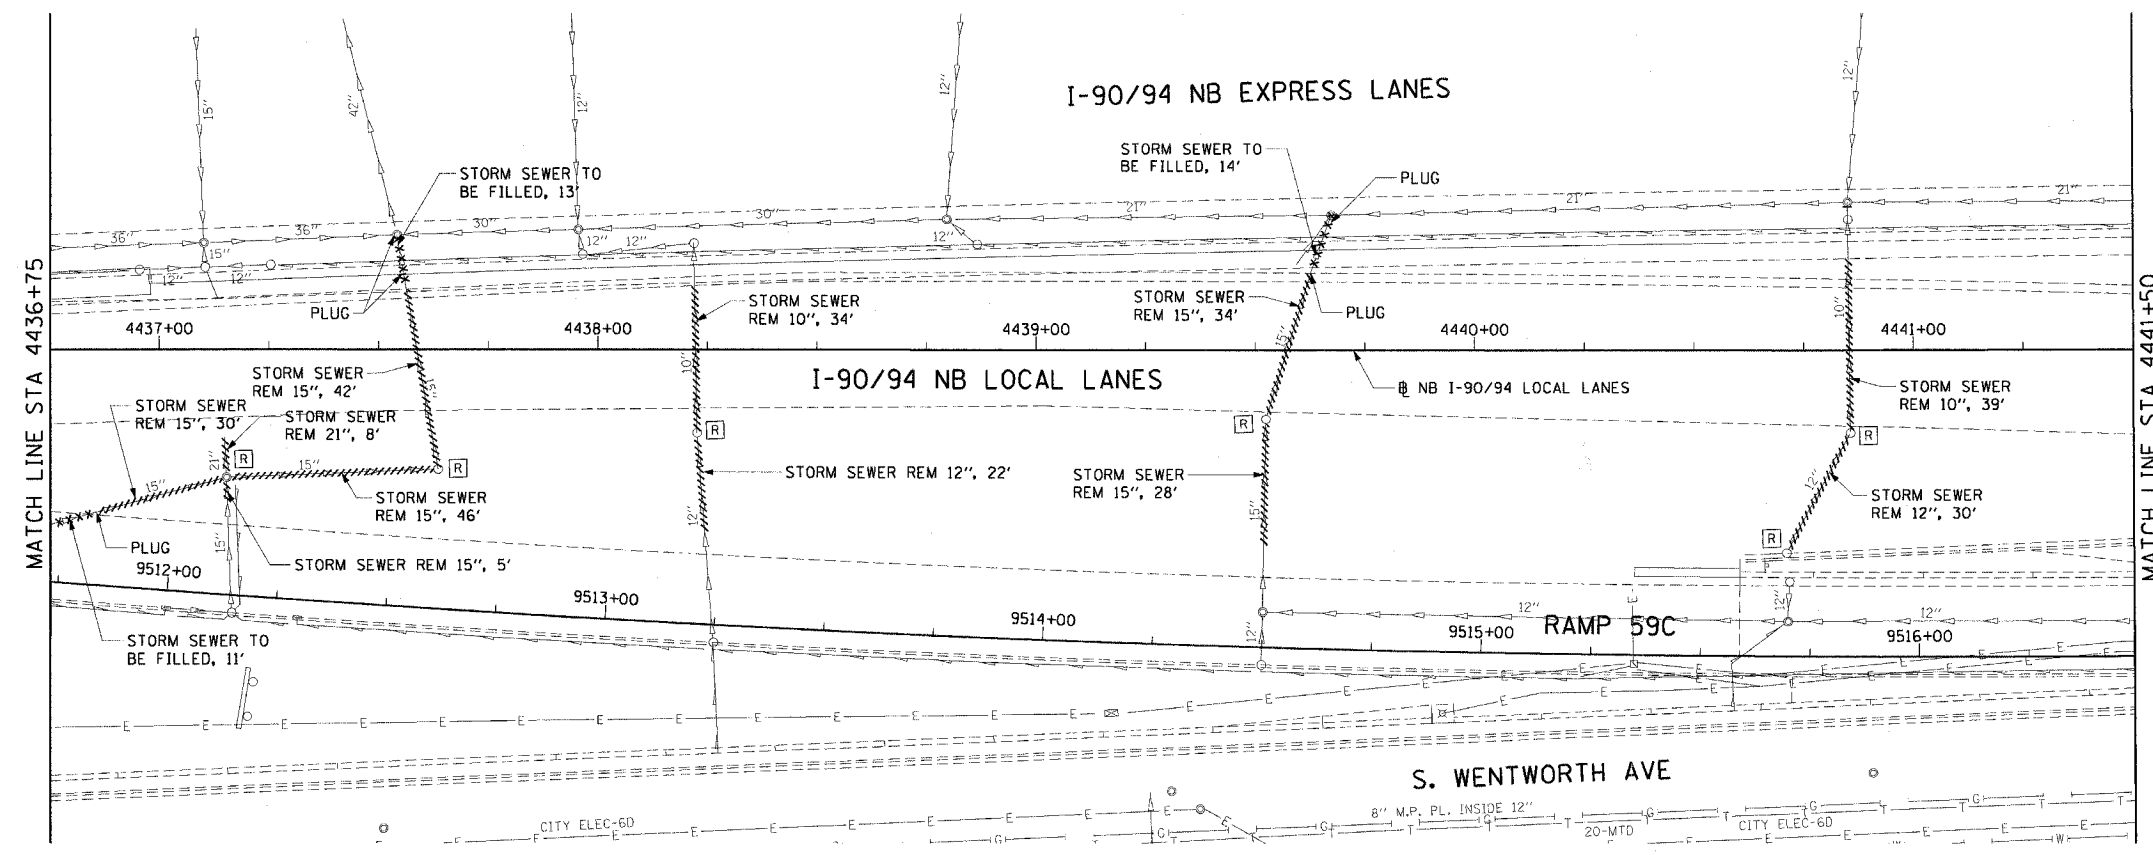

- LEGEND: EXISTING**
- INLET
 - o CATCH BASIN
 - o MANHOLE
 - STORM SEWER
 - - - COMBINED SEWER
 - PIPE UNDERDRAIN
 - [R] STRUCTURE TO BE REMOVED
 - [AD] STRUCTURE TO BE ADJUSTED
 - //// STORM SEWER REMOVAL
 - //// COMBINED SEWER REMOVAL
 - //// WATER MAIN REMOVAL
 - ***** ABANDON EXISTING PIPE

EXISTING CONDITIONS AND REMOVAL

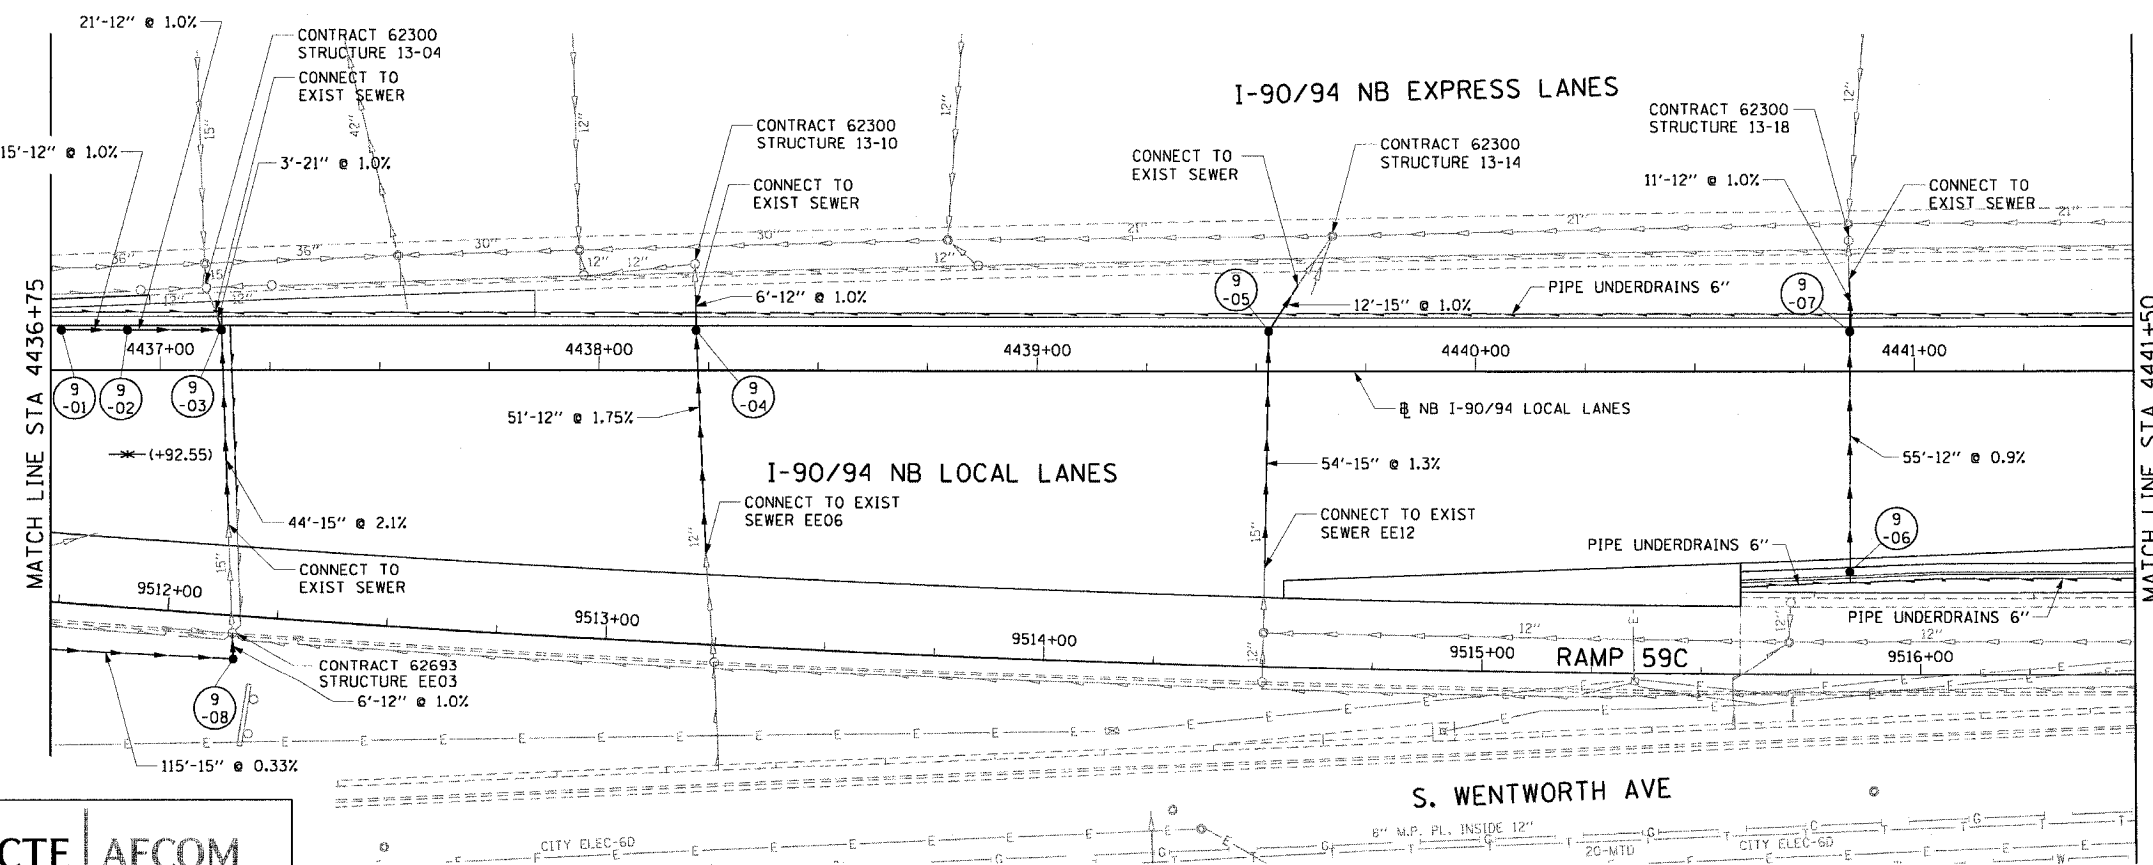

- LEGEND: PROPOSED**
- INLET
 - o CATCH BASIN
 - o MANHOLE
 - STORM SEWER
 - PIPE UNDERDRAIN
 - PROPOSED SWALE
 - HIGH POINT
 - LOW POINT
 - (XX-01) PROPOSED STRUCTURE
- NOTES:**
- SEE DRAINAGE SCHEDULES FOR STRUCTURE, PIPE AND UNDERDRAIN INFORMATION.
 - THE LOCATION OF DRAINAGE STRUCTURES AND PIPES CONSTRUCTED IN PREVIOUS CONTRACTS IS BASED OFF OF CONTRACT PLAN DRAWINGS. THE CONTRACTOR MUST VERIFY LIMITS OF PREVIOUS CONSTRUCTION IN THE FIELD.

CTE | AECOM

REVISIONS	
NAME	DATE

ILLINOIS DEPARTMENT OF TRANSPORTATION
 F.A.I. 90/94 (DAN RYAN EXPRESSWAY)
 63RD STREET TO GARFIELD BLVD (NB LOCAL LANES)
DRAINAGE AND UTILITY PLANS

SCALE: 1"=20'
 DATE: June 9, 2006

DRAWN BY: NJH
 CHECKED BY: RMC

P:\90468\9094\9094-chnr-18 & 19\9094\chnr-18\drainage and utility plans\du090202.dwg 9/17/06