


F.A.I. RTE.	SECTION	COUNTY	TOTAL SHEETS	SHEET NO.
90/94	*	COOK	247	99
STA.		TO STA.		
FED. ROAD DIST. NO. 1		ILLINOIS FED. AID PROJECT		
60A63		* (1919.15, 2021-922 PT1 & PT2) R-2		

SIGN DETAIL

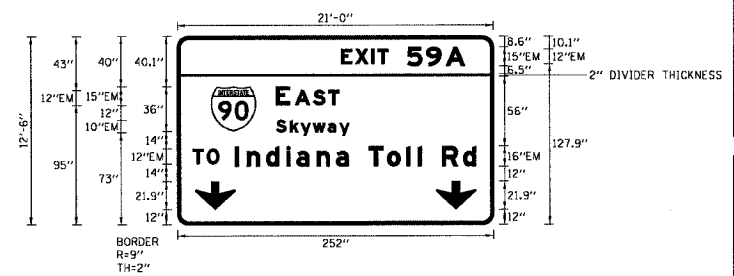


SIGN NUMBER	ISO161094R058.3 LT		
WIDTH x HEIGHT	21'-0" x 12'-6"		
BORDER WIDTH	2"		
CORNER RADIUS	9"		
MOUNTING	OVERHEAD		
BACKGROUND	TYPE: REFLECTIVE		
LEGEND/BORDER	TYPE: REFLECTIVE		
	COLOR: GREEN		
	COLOR: WHITE		

SYMBOL	X	Y	WID	HT
MI_1	26.7	73.9	36	36
AROWN	14.1	12	32	21.9
AROWN	206.1	12	32	21.9

DIMENSIONS ARE IN INCHES, TENTHS LETTER LOCATIONS ARE PANEL EDGE TO LOWER LEFT CORNER

LETTER POSITIONS (X)										LENGTH SERIES, SIZE						
E	X	I	T	S	9	A				98.7	EM12, EM15					
130.6	141.9	154.8	159.6	183.4	198.5	214.4										
E	A	S	T							50.3	EM15, EM12					
78.7	93.7	108.2	120.2													
S	k	y	w	a	y					58.5	EM10/7.5					
78.7	89.9	98.2	108.1	120	129.1											
T	O									21.3	EM12					
12	23.4															
I	n	d	I	a	n	a	T	o	l	I	R	d	192.2	EM16/12		
45.8	55.4	70.6	86.9	94.9	111.2	126.3	136.5	152.5	167.3	182.7	191.9	194.8	210.8	227.8		

SIGN DETAIL

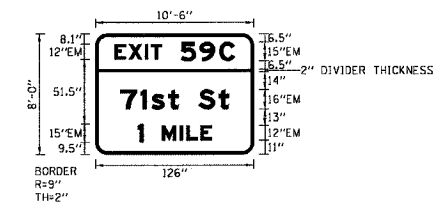


SIGN NUMBER	ISO161094R058.3 RT		
WIDTH x HEIGHT	10'-6" x 8'-0"		
BORDER WIDTH	2"		
CORNER RADIUS	9"		
MOUNTING	OVERHEAD		
BACKGROUND	TYPE: REFLECTIVE		
LEGEND/BORDER	TYPE: REFLECTIVE		
	COLOR: GREEN		
	COLOR: WHITE		

SYMBOL	X	Y	WID	HT

DIMENSIONS ARE IN INCHES, TENTHS LETTER LOCATIONS ARE PANEL EDGE TO LOWER LEFT CORNER

LETTER POSITIONS (X)										LENGTH SERIES, SIZE	
E	X	I	T	S	9	C				95.7	EM12, EM15
15.2	26.4	39.3	44.1	67.9	83	98.9					
7	I	s	t		S	t				86.5	EM16/12
19.8	35.8	44.7	58	66.1	82.1	98.2					
1	M	I	L	E						59.1	EM15, EM12
33.4	52.9	67	72.4	83.7							

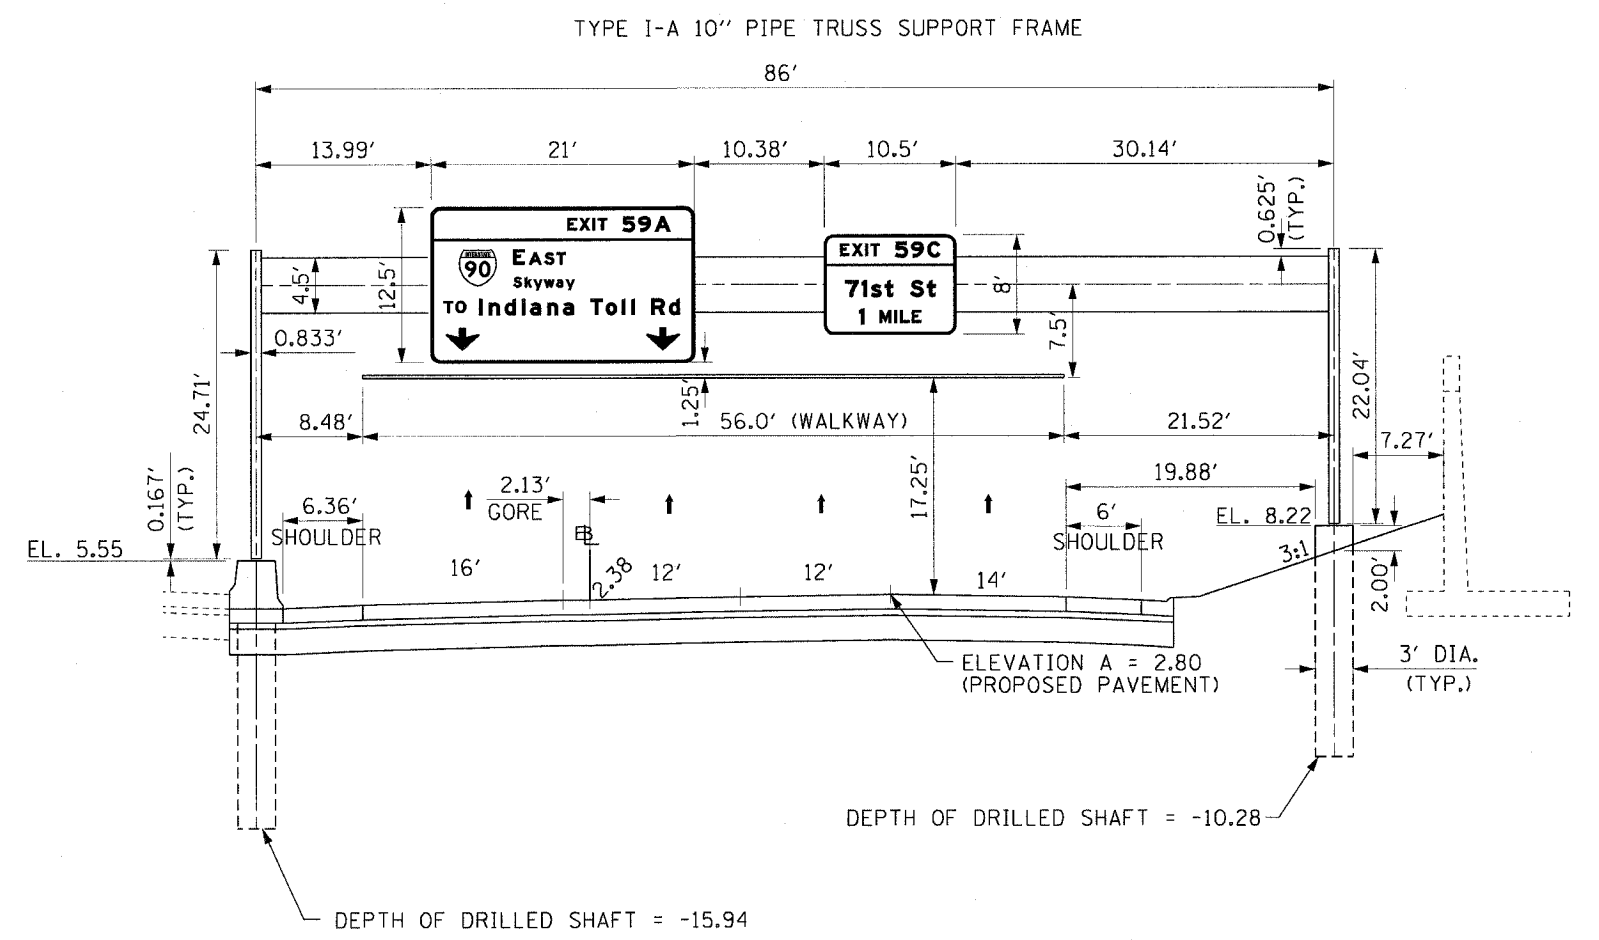

ISO161094R058.3  
MOUNTING DETAIL  
PROPOSED OVERHEAD SIGN STRUCTURE  
STA 3444+50.00 S.B. I-90/94  
LOOKING SOUTH

NOTES:

1. PROPOSED PAVEMENT FOR LOCAL LANES IS SHOWN FOR INFORMATION ONLY.
2. REFER TO LIGHTING PLANS FOR ORIENTATION AND LOCATION OF THE CONDUIT EMBEDDED IN THE OVERHEAD SIGN FOUNDATIONS.



REVISIONS	
NAME	DATE

OSS-1  
ILLINOIS DEPARTMENT OF TRANSPORTATION  
F.A.I. 90/94 (DAN RYAN EXPRESSWAY)  
63RD STREET TO GARFIELD BLVD (SB LOCAL LANES)  
PERMANENT SIGN PANEL MOUNTING DETAILS  
PROPOSED OVERHEAD SIGN STRUCTURE  
STA. 3444+50.00  
SCALE: NONE DRAWN BY: JSS  
DATE: June 9, 2006 CHECKED BY: MJP

6/27/2006 10:58:15 AM P:\P\040603\N\08\CHRS 18 & 19\SYM\CONTR\BAS\Signing\SS\90A02\2458.rvt