


F.A.I. RTE.	SECTION	COUNTY	TOTAL SHEETS	SHEET NO.
94/90		COOK	588	256
STA.		TO STA.		
FED. ROAD DIST. NO.		ILLINOIS	FED. AID PROJECT	
62303		*(2021-922 PT2 ETC 2324.6-1P1R-11		

SIGN DETAIL

1:100

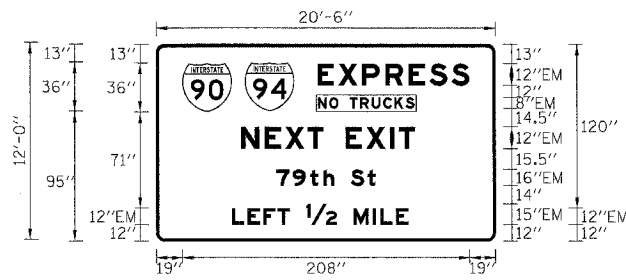

SIGN NUMBER	IS0161094R056.47 LT
WIDTH x HGHT.	20'-6" x 12'-0"
BORDER WIDTH	2"
CORNER RADIUS	9"
MOUNTING	Overhead
BACKGROUND	TYPE: Reflective
	COLOR: Green
LEGEND/BORDER	TYPE: Reflective
	COLOR: White

SYMBOL	X	Y	WID	HT
M1_1	19	95	36	36
M1_1	64.2	95	36	36

Panel Style:guide_exp_advance_b.ssi
Dimensions are in inches.tenths


Letter locations are panel edge to lower left corner

LETTER POSITIONS (X)

LETTER POSITIONS (X)										LENGTH	SERIESIZE
E	X	P	R	E	S	S					EM12
117.1	132.2	149.3	166.1	183	198	214.1				110.1	
N	O		T	R	U	C	K	S			EM8
117.1	125.6	132.2	140.2	147.7	156.1	164.6	172.6	180.8		70.2	
N	E	X	T		E	X	I	T			EM12
61.6	78.4	93.5	109.5	121.2	137.2	152.3	169.4	175.8		126	
7	9	t	h		S	t					EM1612
86.6	98.7	111.4	121.2	128.8	140.8	152.9				72.4	
L	E	F	T	I	M	I	L	E			EM12/EM15
54.7	66	77.3	87.8	108.5	142.5	152.1	166.6	179.2		145.6	

SIGN DETAIL

1:100

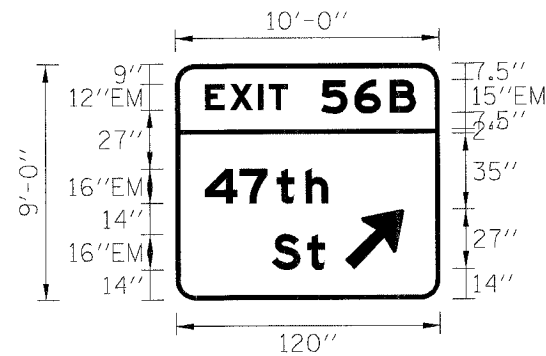

SIGN NUMBER	IS0161094R056.47 RT
WIDTH x HGHT.	10'-0" x 9'-0"
BORDER WIDTH	2"
CORNER RADIUS	9"
MOUNTING	Overhead
BACKGROUND	TYPE: Reflective
	COLOR: Green
LEGEND/BORDER	TYPE: Reflective
	COLOR: White

SYMBOL	X	Y	WID	HT
ARMED	76.8	14	22.3	35.1

Panel Style:guide_exp_advance_b.ssi
Dimensions are in inches.tenths


Letter locations are panel edge to lower left corner

LETTER POSITIONS (X)

LETTER POSITIONS (X)										LENGTH	SERIESIZE
E	X	I	T	5	6	B					EM12,EM15
13.5	24.8	37.6	42.4	66.3	81.4	97.4				96	
4	7	t	h		S	t					EM1612
13.1	28.9	45.9	58.9	69.2						57.2	
S	t										EM1612
48.5	59.6									24.2	

SIGN DETAIL

1:100

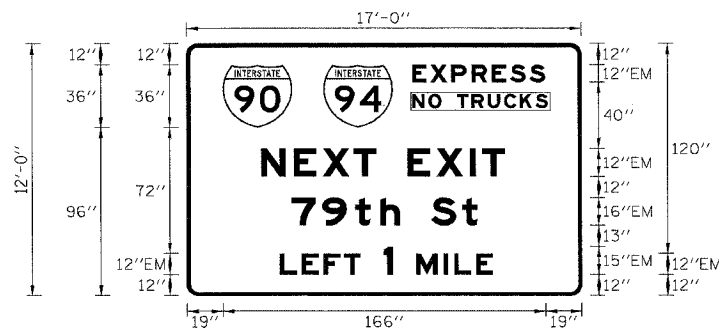

SIGN NUMBER	IS0161094R056.02 LT
WIDTH x HGHT.	17'-0" x 12'-0"
BORDER WIDTH	2"
CORNER RADIUS	9"
MOUNTING	Overhead
BACKGROUND	TYPE: Reflective
	COLOR: Green
LEGEND/BORDER	TYPE: Reflective
	COLOR: White

SYMBOL	X	Y	WID	HT
M1_1	19	96	36	36
M1_1	70.6	96	36	36

Panel Style:guide_exp_advance_b.ssi
Dimensions are in inches.tenths


Letter locations are panel edge to lower left corner

LETTER POSITIONS (X)

LETTER POSITIONS (X)										LENGTH	SERIESIZE
E	X	P	R	E	S	S					EM12
116.6	126	136.7	147.2	157.8	167.2	177.2				68.8	
N	O		T	R	U	C	K	S			EM8
116.6	125.1	131.7	139.7	147.2	155.6	164.1	172.1	180.2		70.2	
N	E	X	T		E	X	I	T			EM12
38.3	55.2	70.3	86.3	98	114	129.1	146.1	152.6		126	
7	9	t	h		S	t					EM1612
53.8	69.9	86.8	99.9	110.1	126.1	142.3				96.5	
L	E	F	T	I	M	I	L	E			EM12,EM15
47.9	59.2	70.5	80.9	101.7	118.5	132.6	138	149.3		110.2	

SIGN DETAIL

1:100

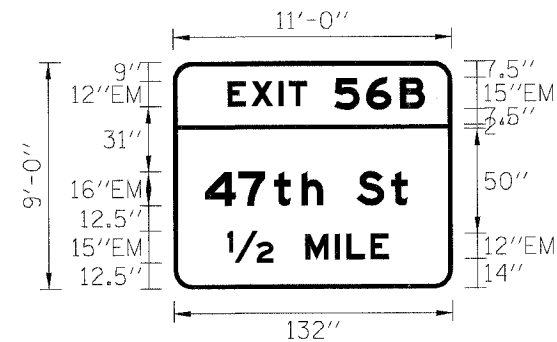

SIGN NUMBER	IS0161094R056.02 CN
WIDTH x HGHT.	11'-0" x 9'-0"
BORDER WIDTH	2"
CORNER RADIUS	9"
MOUNTING	Overhead
BACKGROUND	TYPE: Reflective
	COLOR: Green
LEGEND/BORDER	TYPE: Reflective
	COLOR: White

SYMBOL	X	Y	WID	HT

Panel Style:guide_exp_advance_b.ssi
Dimensions are in inches.tenths

Letter locations are panel edge to lower left corner

LETTER POSITIONS (X)

LETTER POSITIONS (X)										LENGTH	SERIESIZE
E	X	I	T	5	6	B					EM12,EM15
25.7	36.9	49.8	54.6	76.3	91.4	107.3				93.6	
4	7	t	h		S	t					EM1612
14.7	30.5	47.4	60.5	70.8	86.7	102.9				96.3	
I	M	I	L	E							EM15,EM12
25.2	62.2	76.3	81.7	93						76.6	



REVISIONS	
NAME	DATE
ADDENDUM 2	8/04/06

ILLINOIS DEPARTMENT OF TRANSPORTATION
F.A.I. 90/94 (DAN RYAN EXPRESSWAY)
GARFIELD BLVD TO 31ST STREET (SB LOCAL LANES)
SIGN PANEL DETAILS

SCALE: 1"=50'
DATE: 06/09/06
DRAWN BY: RV
CHECKED BY: AS

SGN-06

8/14/2006 4:03:34 PM