


EXISTING PLAN
PROPOSED PLAN

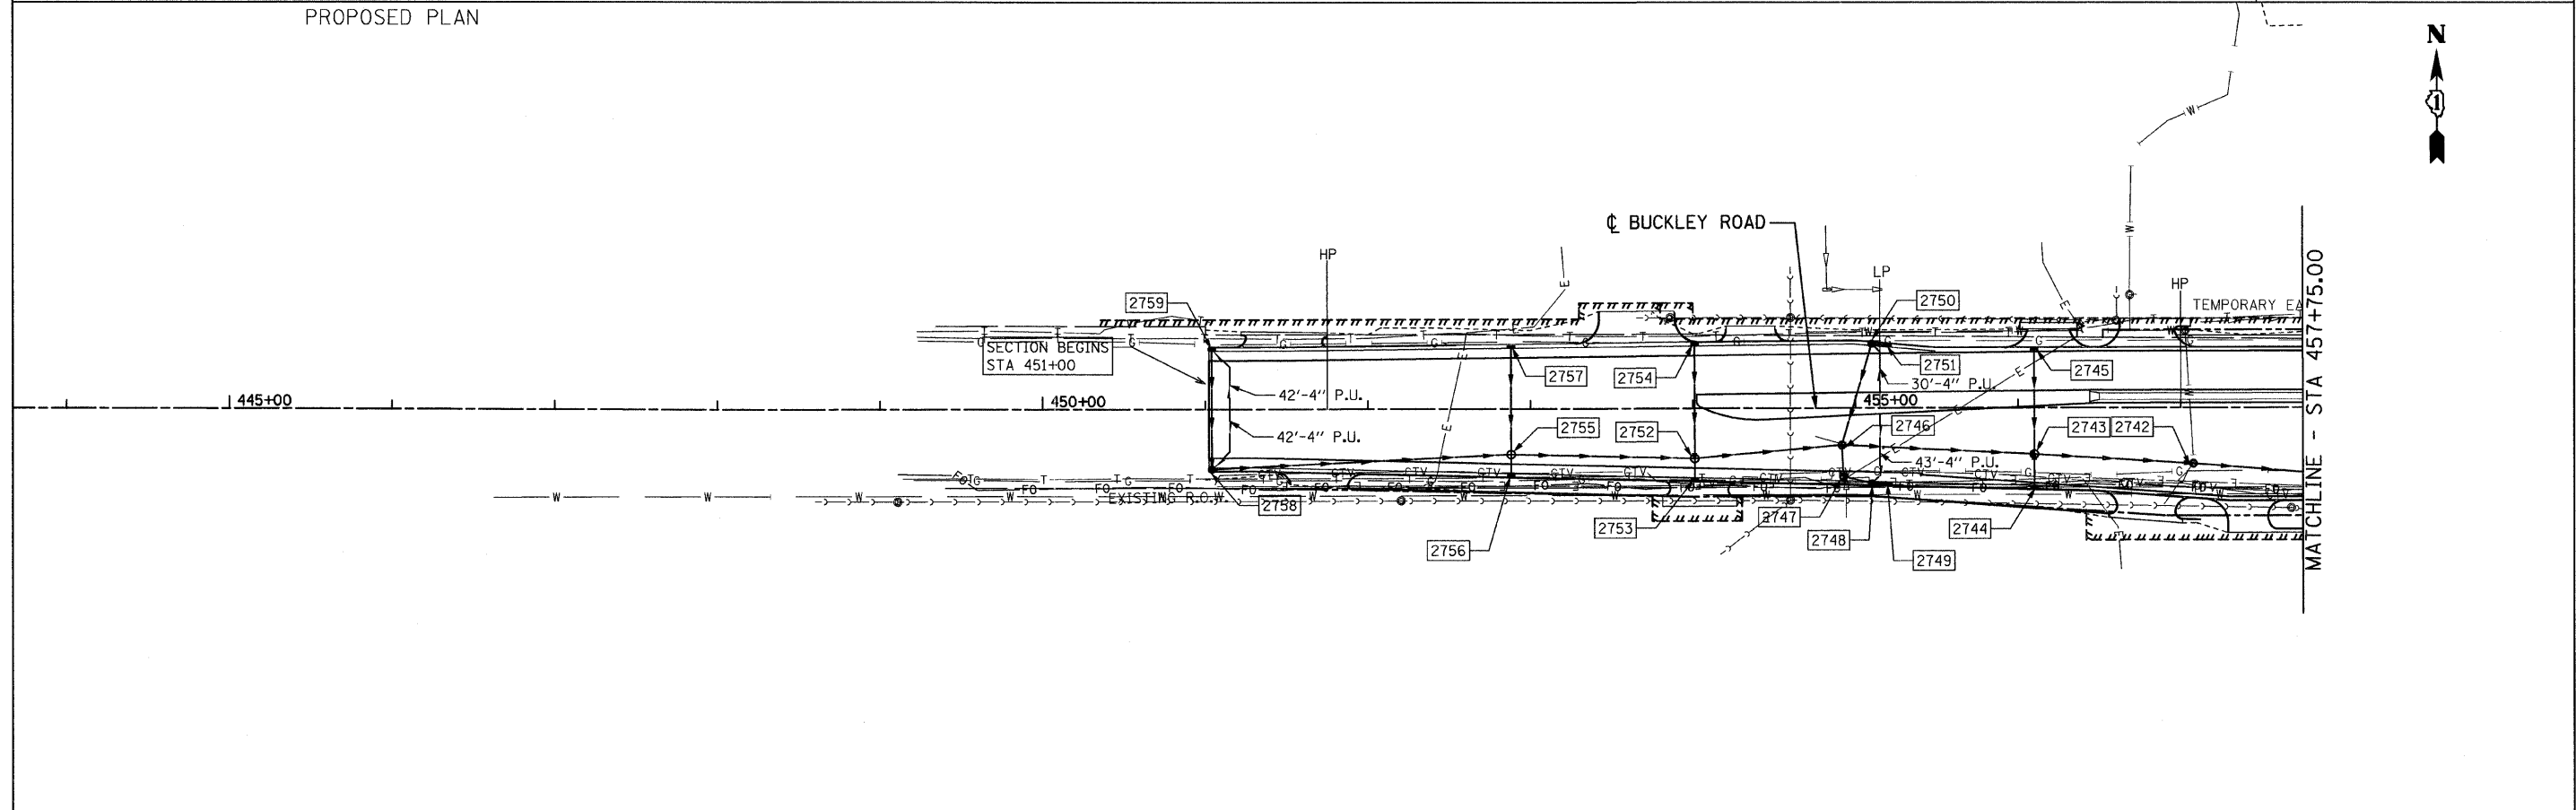

FILE NAME = u:\182981\cadd sheets\sh-t-drain09.dgn	USER NAME = IDOT	DESIGNED - EJM	REVISED -	STATE OF ILLINOIS DEPARTMENT OF TRANSPORTATION	DRAINAGE AND UTILITY PLAN IL RTE 137 (BUCKLEY RD)	F.A.P. RTE. 330	SECTION 128R-3	COUNTY LAKE	TOTAL SHEETS 518	SHEET NO. 102		
PLOT SCALE = 50.0000' / IN.	CHECKED - GFL	REVISIONS	SCALE: 1" = 50'			SHEET NO. OF SHEETS	STA. 444+90.00 TO STA. 457+75.00	ILLINOIS FED. AID PROJECT		CONTRACT NO. 60953		
PLOT DATE = 8/11/2011	DATE - 4/30/2011	REVISIONS										