
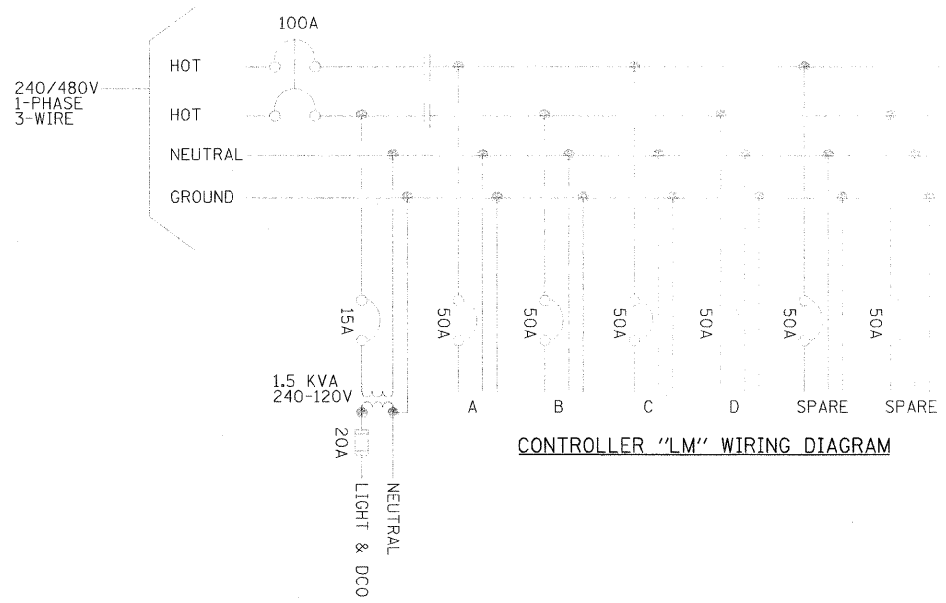


PANEL SCHEDULE AND LOAD TABULATION
LIGHTING CONTROLLER LM
 240 / 480 VOLTS 1-PHASE, 3-WIRE
 MAIN BREAKER: 100A

CIRCUIT	BREAKER TRIP AMPS	KW		AMPS
		BLACK	RED	
A	50	-	3.3	13.9
B	50	3.8	-	15.9
C	50	-	2.4	9.9
D	50	2.4	-	9.9
SPARE	50			
SPARE	50			
SUBTOTAL		6.2	5.7	--
TOTAL		11.9		24.8

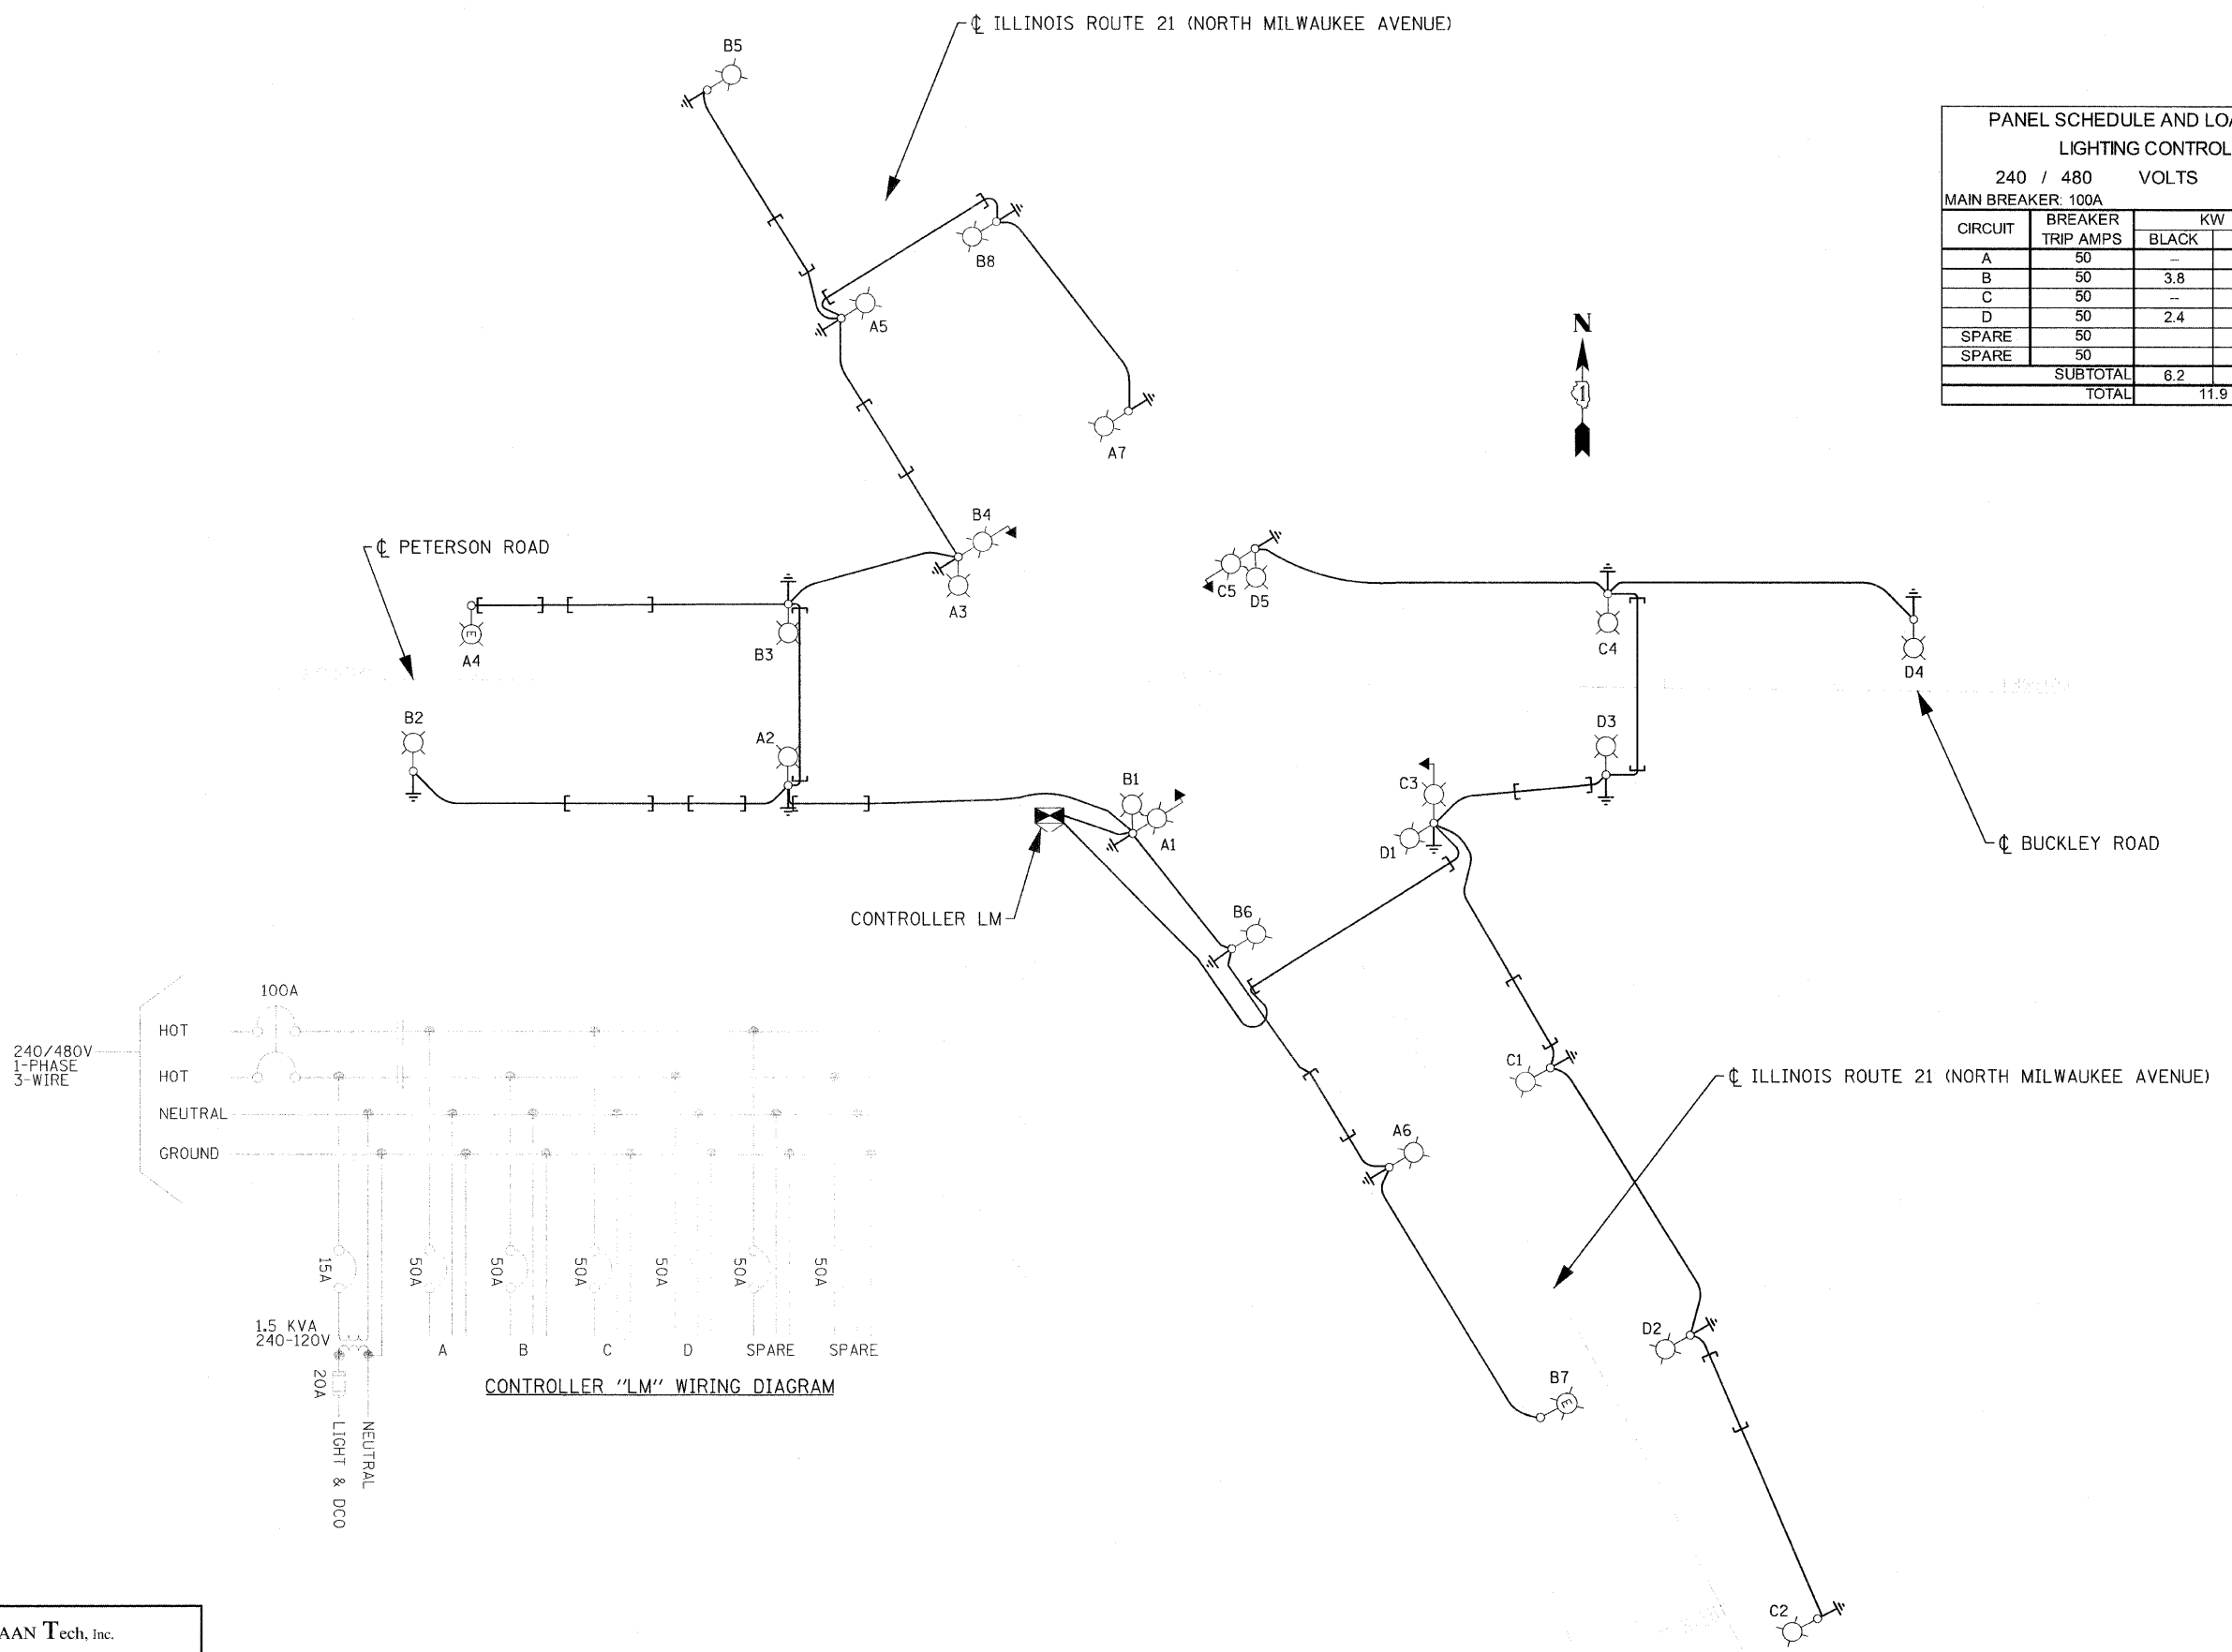

SPAAN Tech, Inc.
 311 South Wacker Drive, Suite 2400
 Chicago, IL 60606
 Phone: 312.277.8800
 Fax: 312.277.8808
 www.spaan-tech.com

LT-05.dgn	USER NAME = Darlan Longmire	DESIGNED - TCM	REVISED -
STI - PDF.plt		DRAWN - TCM	REVISED -
7/6/2011 3:10:15 PM	PLDT SCALE = 50.000000' / in.	CHECKED - TCM	REVISED -
	SpaanTech - By LineWeight - grayscale.tbl	DATE - 04/13/11	REVISED -

STATE OF ILLINOIS
DEPARTMENT OF TRANSPORTATION

ILLINOIS ROUTE 21 AND ILLINOIS ROUTE 137
WIRING DIAGRAM

SCALE: NONE SHEET NO. OF SHEETS STA. TO STA.

F.A.P. RTE.	SECTION	COUNTY	TOTAL SHEETS	SHEET NO.
330	128R-3	LAKE	517	233
CONTRACT NO. 60953				
ILLINOIS FED. AID PROJECT				

LT-05