
 
 

 


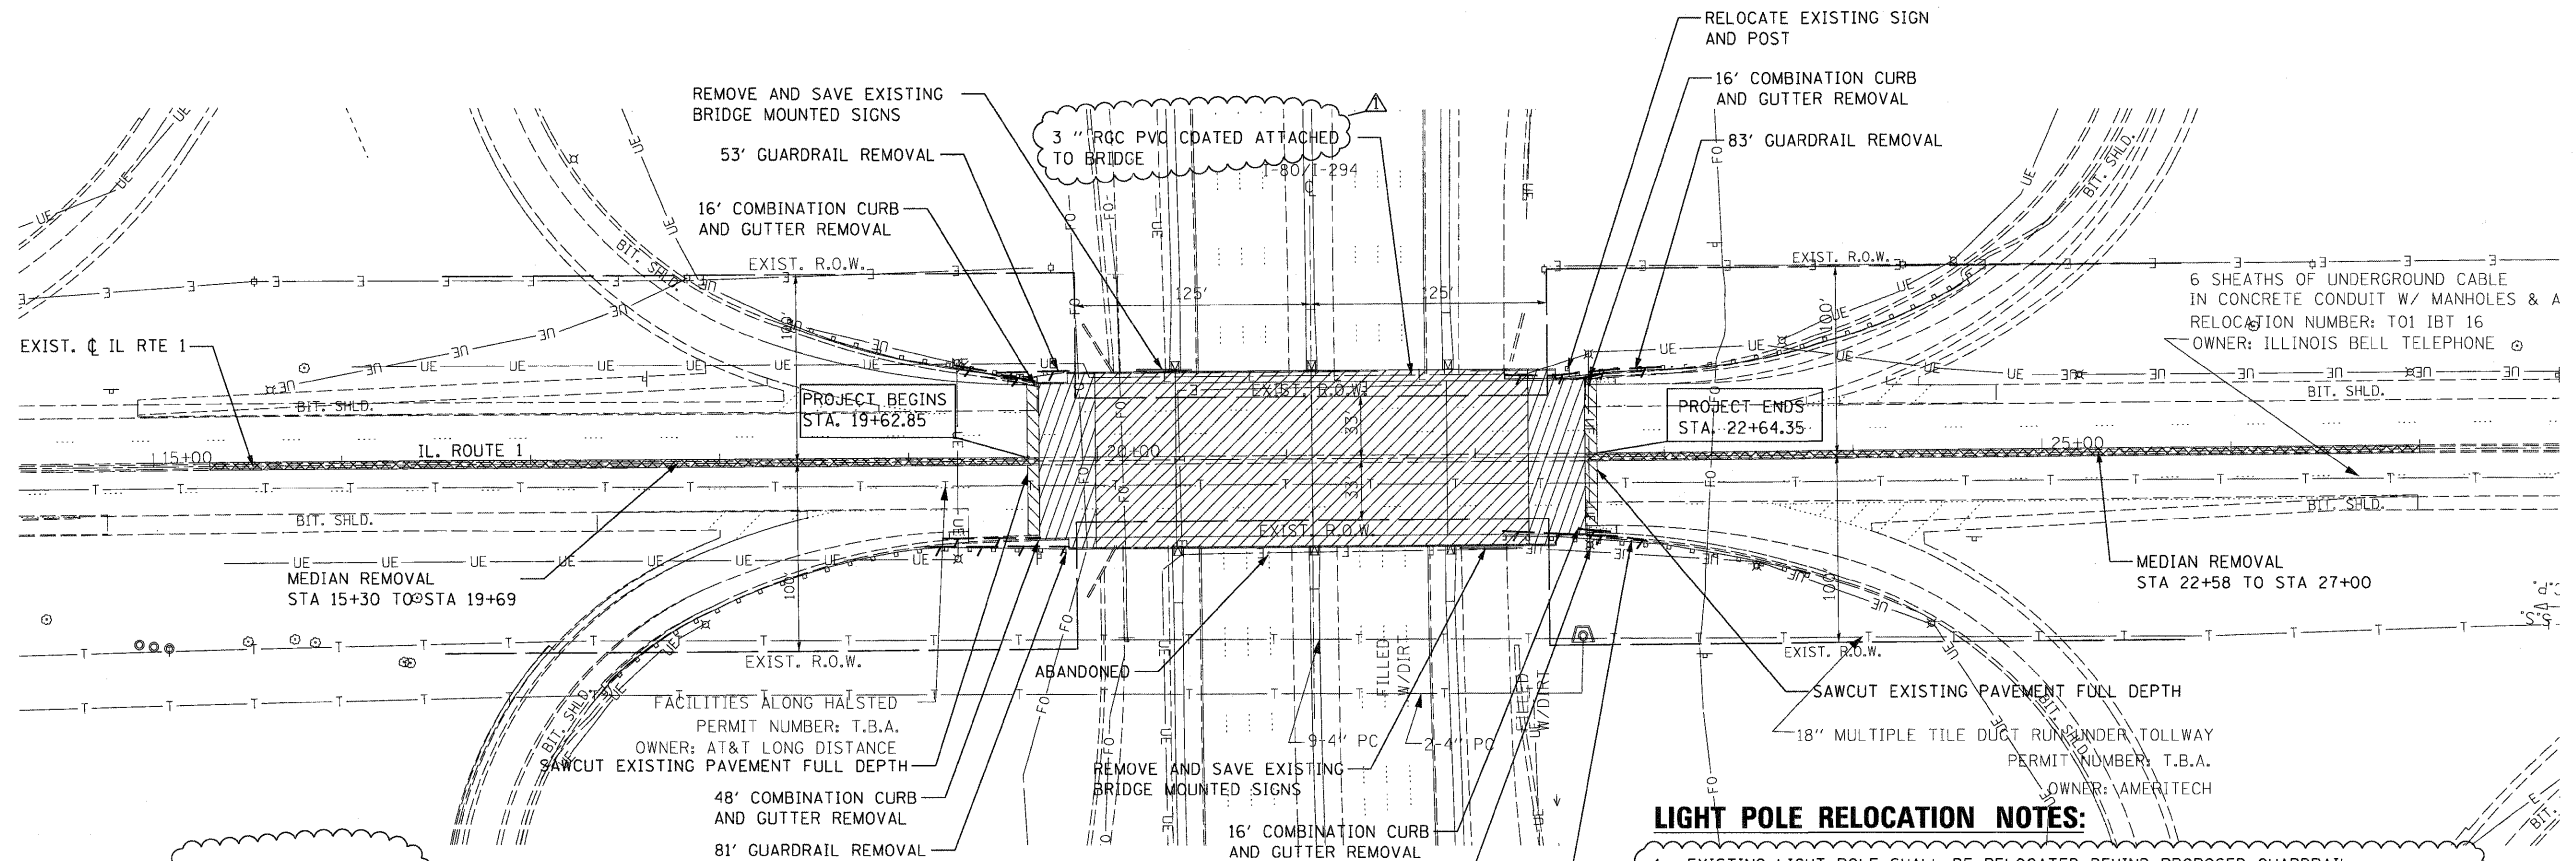
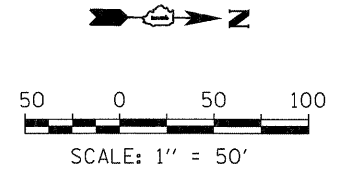


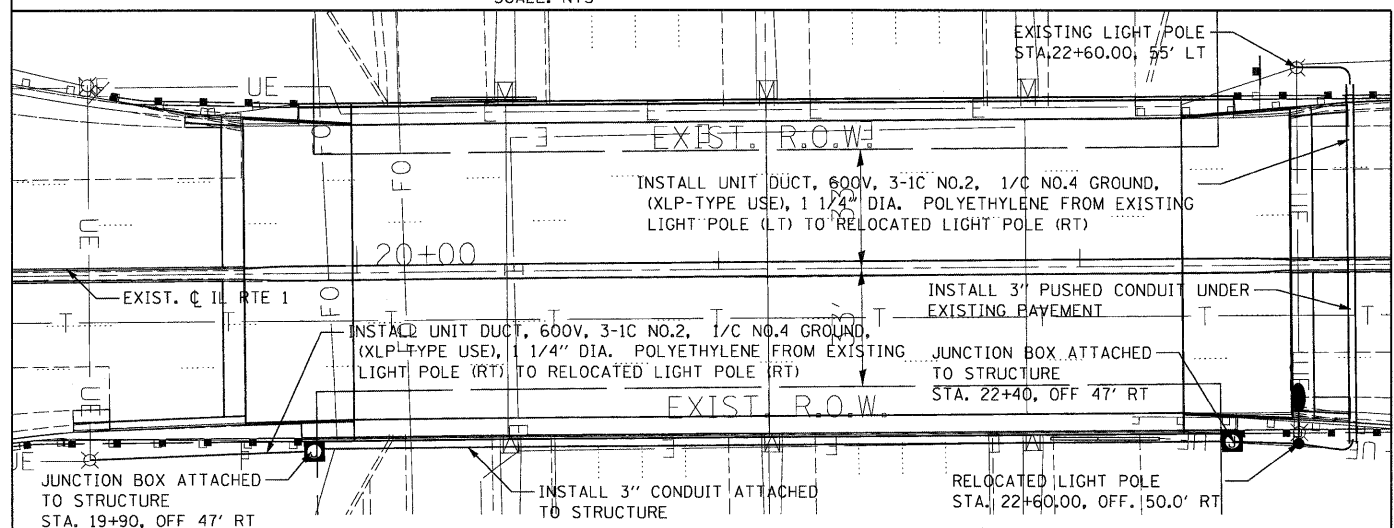
LEGEND:

-  BRIDGE APPROACH SLAB REMOVAL
-  SUPERSTRUCTURE REMOVAL (SEE STRUCTURAL PLANS)
-  PAVEMENT REMOVAL
-  PAVED SHOULDER REMOVAL
-  GUARDRAIL REMOVAL
-  MEDIAN REMOVAL
-  CURB AND GUTTER REMOVAL



LIGHTING PLAN

SCALE: NTS



LIGHT POLE RELOCATION NOTES:

1. EXISTING LIGHT POLE SHALL BE RELOCATED BEHIND PROPOSED GUARDRAIL, TO LOCATION STA. 22+60 OFFSET 50' RT, OR AS DIRECTED BY THE ENGINEER.
2. RELOCATED POLE TO BE RECONNECTED TO EXISTING CONTROLLER AND TO THE SAME CIRCUIT AS EXISTING.
3. NEW SYSTEM SHALL BE PUT IN PLACE TO MAINTAIN EXISTING LIGHTING BEFORE RELOCATION OF EXISTING LIGHTING POLE AND AT THE END OF STAGE I CONSTRUCTION.
4. THE CONTRACTOR SHALL VERIFY LOCATIONS OF UNDERGROUND UTILITIES BEFORE ANY WORK BEGINS. THE CONTRACTOR SHALL CONTACT THE ELECTRICAL MAINTENANCE OFFICE AT (847) 221-3079.
5. WORK SHALL CONFORM TO THE LATEST IDOT AND IDOT DISTRICT 1 STANDARDS, SUPPLEMENTAL SPECIFICATIONS AND THE NATIONAL ELECTRICAL CODE.
6. RELOCATION OF EXISTING TRAFFIC SIGN ATTACHED TO LIGHT POLE SHALL BE INCLUDED IN THE COST OF LIGHT POLE RELOCATION.
7. LIGHT POLE FOUNDATION SHALL BE CONCRETE, 24" DIAMETER. THE CONTRACTOR SHOULD VERIFY THE BOLT CIRCLE DIAMETER OF THE POLE BEFORE SETTING THE NEW FOUNDATION.
8. EXISTING LIGHTING SYSTEM ALONG IL 1 (HALSTED STREET) TO BE MAINTAINED DURING CONSTRUCTION. SEE SPECIAL PROVISIONS FOR MORE INFORMATION.
9. FOR ADDITIONAL PROPOSED CONDUIT LOCATION SEE PLAN AND PROFILE SHEET.

FILE NAME = 62099CRM01.DGN	USER NAME = helsted	DESIGNED - PK	REVISED - 09/01/2011
PLOT SCALE = 50.000' / IN.	CHECKED - RPI	DRAWN - GAP	REVISED -
PLOT DATE = 9/1/2011	DATE - 07/01/2011	REVISIONS	REVISED -

**STATE OF ILLINOIS
DEPARTMENT OF TRANSPORTATION**

**ILLINOIS RTE 1 OVER TRI-STATE I-80 / I-294
EXISTING AND REMOVAL PLAN
LIGHTING PLAN**

F.A.P. RTE.	SECTION	COUNTY	TOTAL SHEETS	SHEET NO.
876	2001-001BR	COOK	62	10
CONTRACT NO. 62099				
FED. ROAD DIST. NO. 1 ILLINOIS FED. AID PROJECT				

SCALE: 1"=50' SHEET NO. OF SHEETS STA. TO STA.