



TYPICAL SPLICE DETAIL
N.T.S.

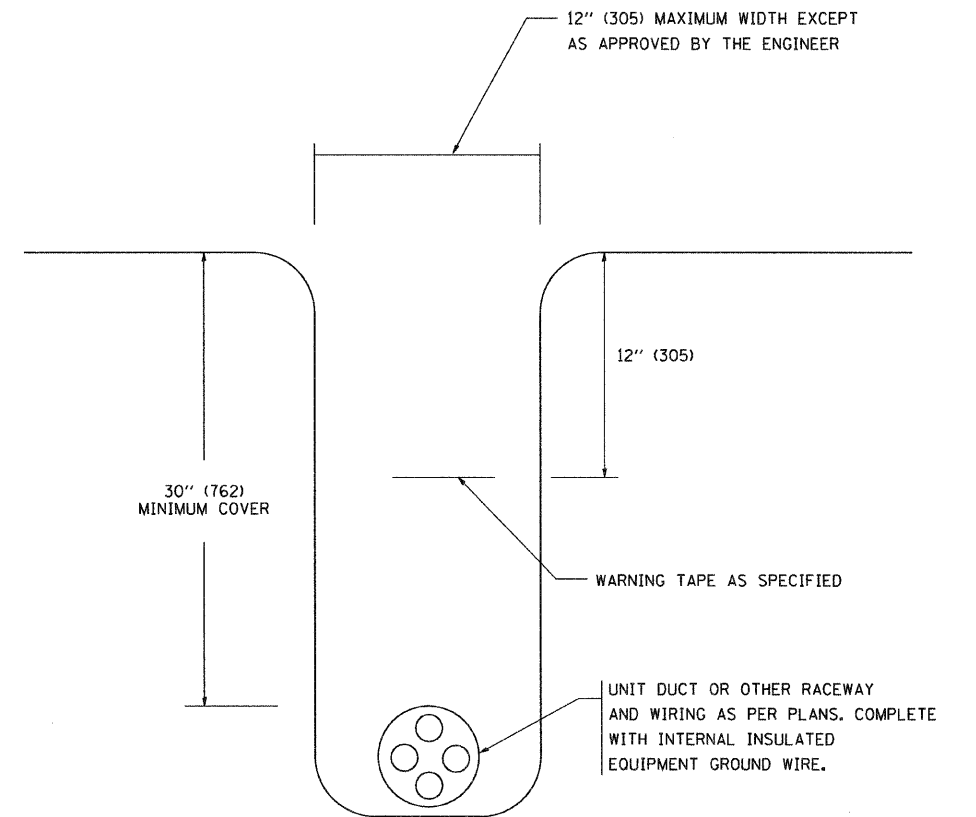

TYPICAL WIRING IN TRENCH DETAIL
N.T.S.

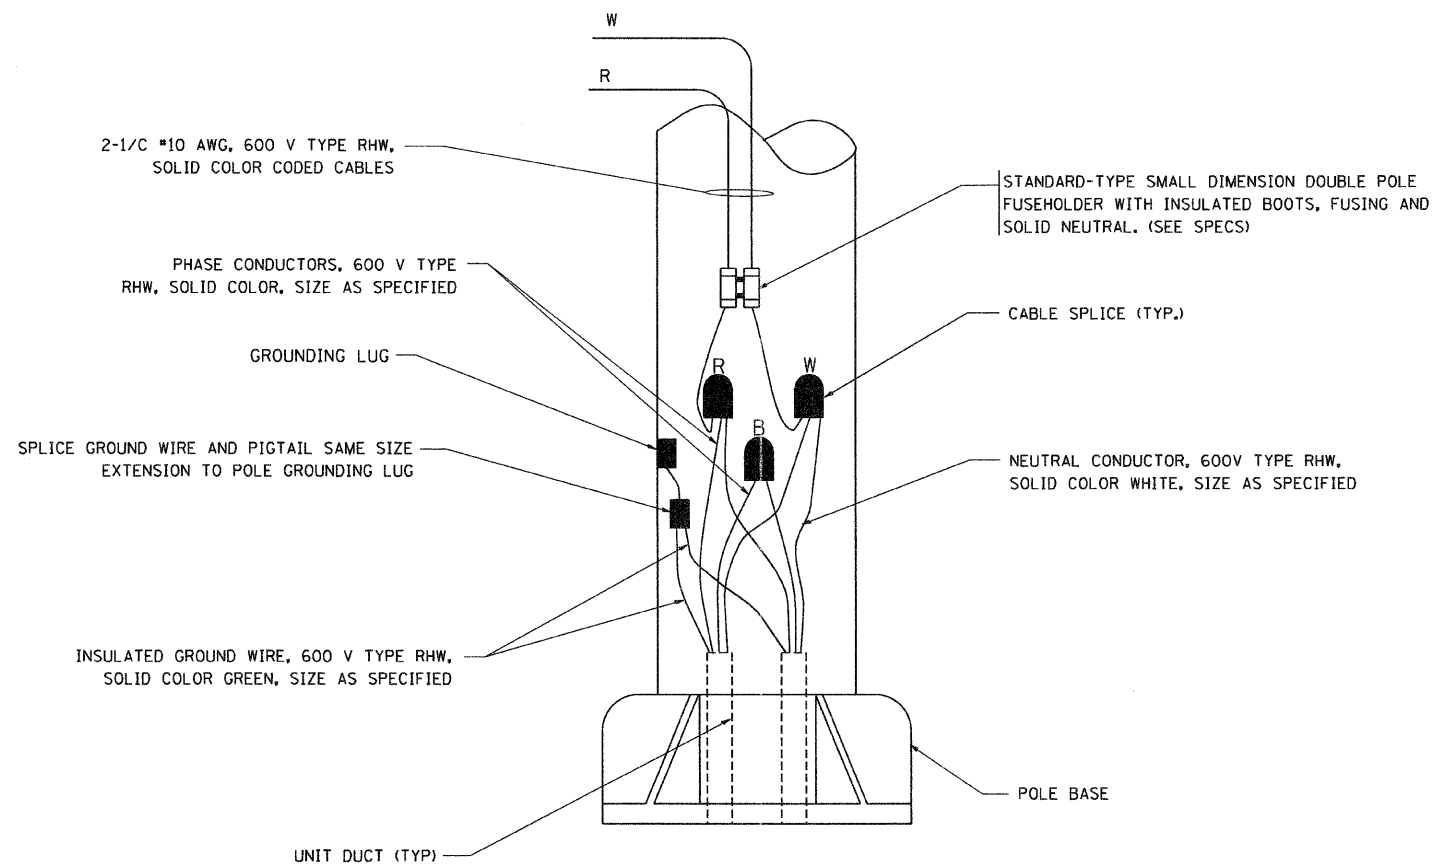

POLE WIRING DETAIL
N.T.S.

FILE NAME = W:\diststd\22x34\be782.dgn	USER NAME = goglianobt	DESIGNED -	REVISED - 08-08-03	STATE OF ILLINOIS DEPARTMENT OF TRANSPORTATION	MISC. ELECTRICAL DETAILS SHEET A			F.A.P. RTE. 876	SECTION 2001-001-BR	COUNTY COOK	TOTAL SHEETS 62	SHEET NO. 52B
	PLOT SCALE = 50,000' / IN.	DRAWN -	REVISED -					BE-702	CONTRACT NO. 62099			
	PLOT DATE = 1/4/2008	CHECKED -	REVISED -					FED. ROAD DIST. NO. 1 ILLINOIS FED. AID PROJECT				
	DATE -	REVISED -	SCALE: NONE SHEET NO. 1 OF 1 SHEETS STA. TO STA.									

Added Sheet 9-B-11