



TYPICAL SPLICE DETAIL
N.T.S.

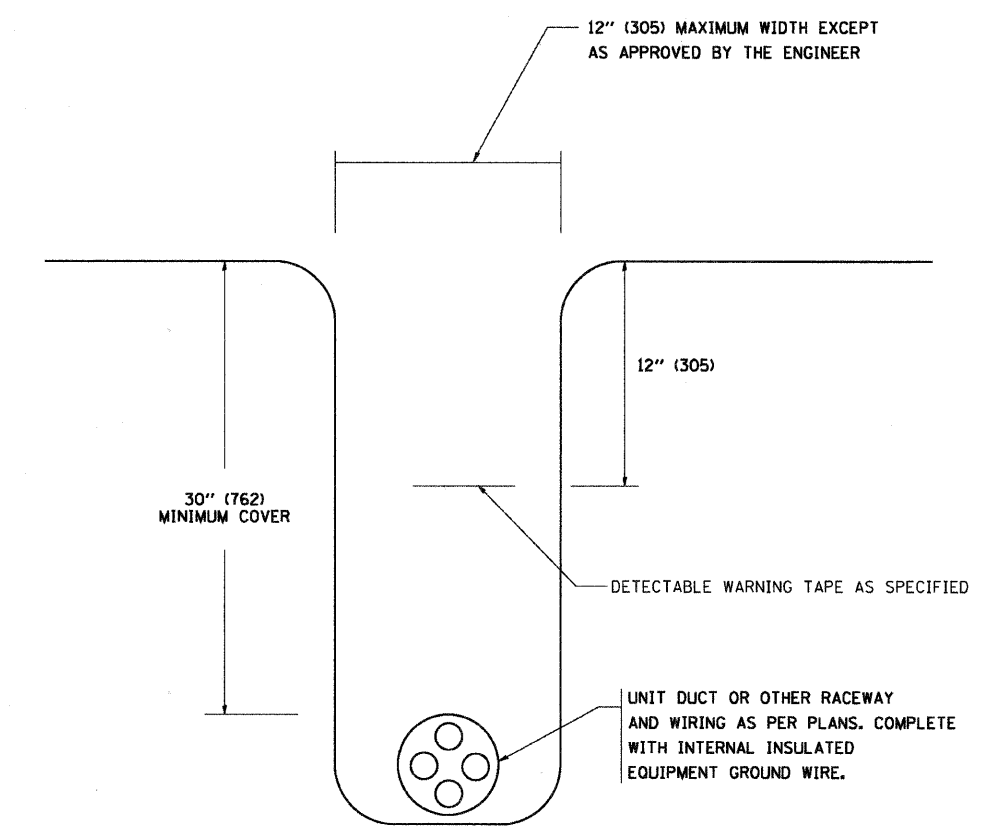

TYPICAL WIRING IN TRENCH DETAIL
N.T.S.

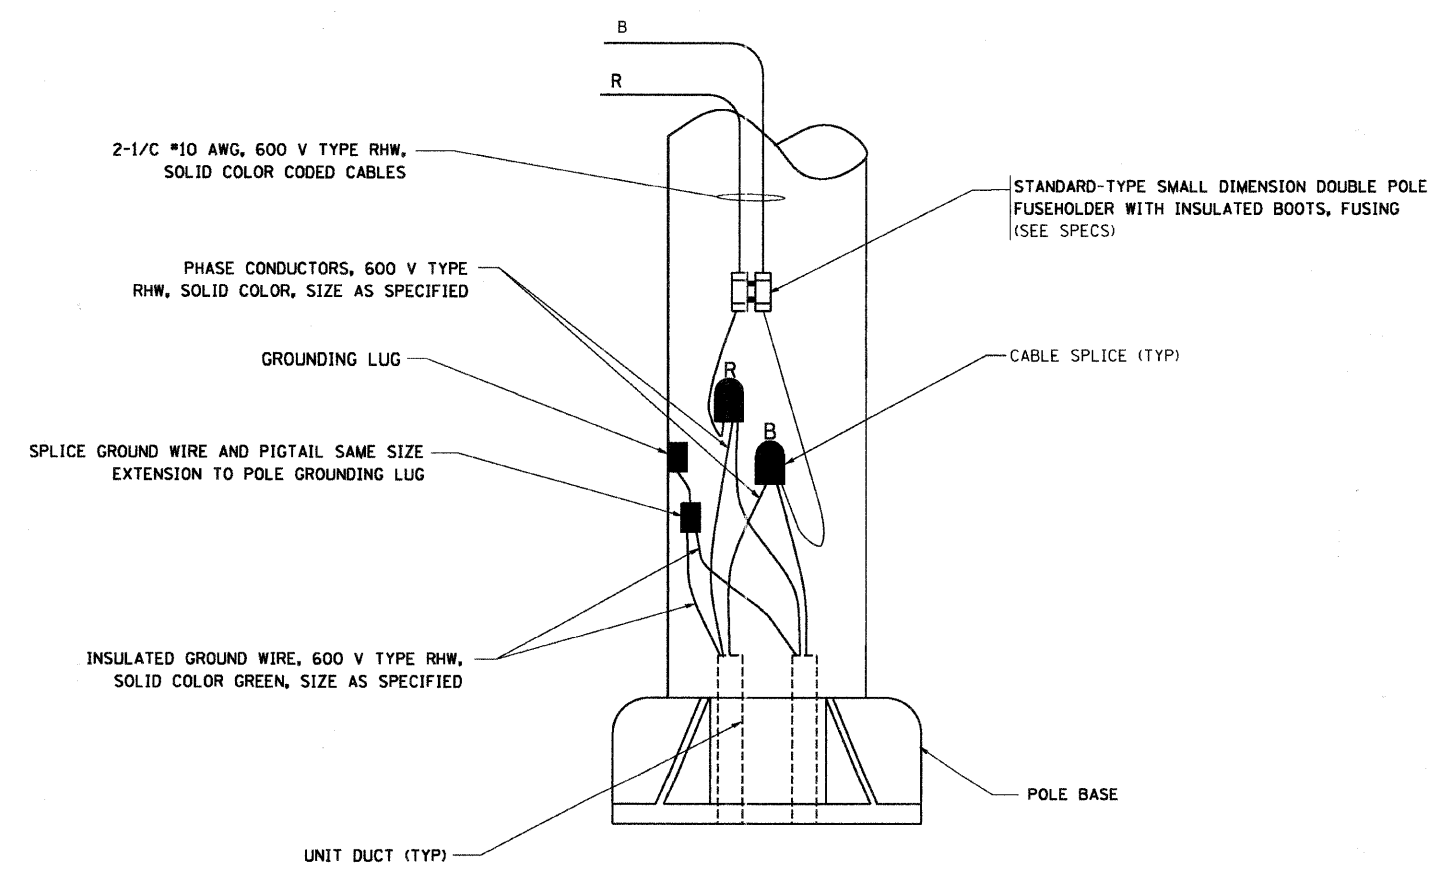

POLE WIRING DETAIL
N.T.S.

FILE NAME = W:\distatd\22x34\be782.dgn	USER NAME = goglieno	DESIGNED -	REVISED - 08-08-03	STATE OF ILLINOIS DEPARTMENT OF TRANSPORTATION	MISC. ELECTRICAL DETAILS SHEET A		F.A.U. RTE.	SECTION	COUNTY	TOTAL SHEETS	SHEET NO.
	PLOT SCALE = 50,000' / IN.	DRAWN -	REVISED -				2678	09-00171-00-CH	DUPAGE	85	56
	PLOT DATE = 1/4/2008	CHECKED -	REVISED -				CONTRACT NO. 63610		FED. ROAD DIST. NO. 1 (ILLINOIS) FED. AID PROJECT		
				SCALE: NONE	SHEET NO. 1 OF 1 SHEETS	STA.	TO STA.				