
 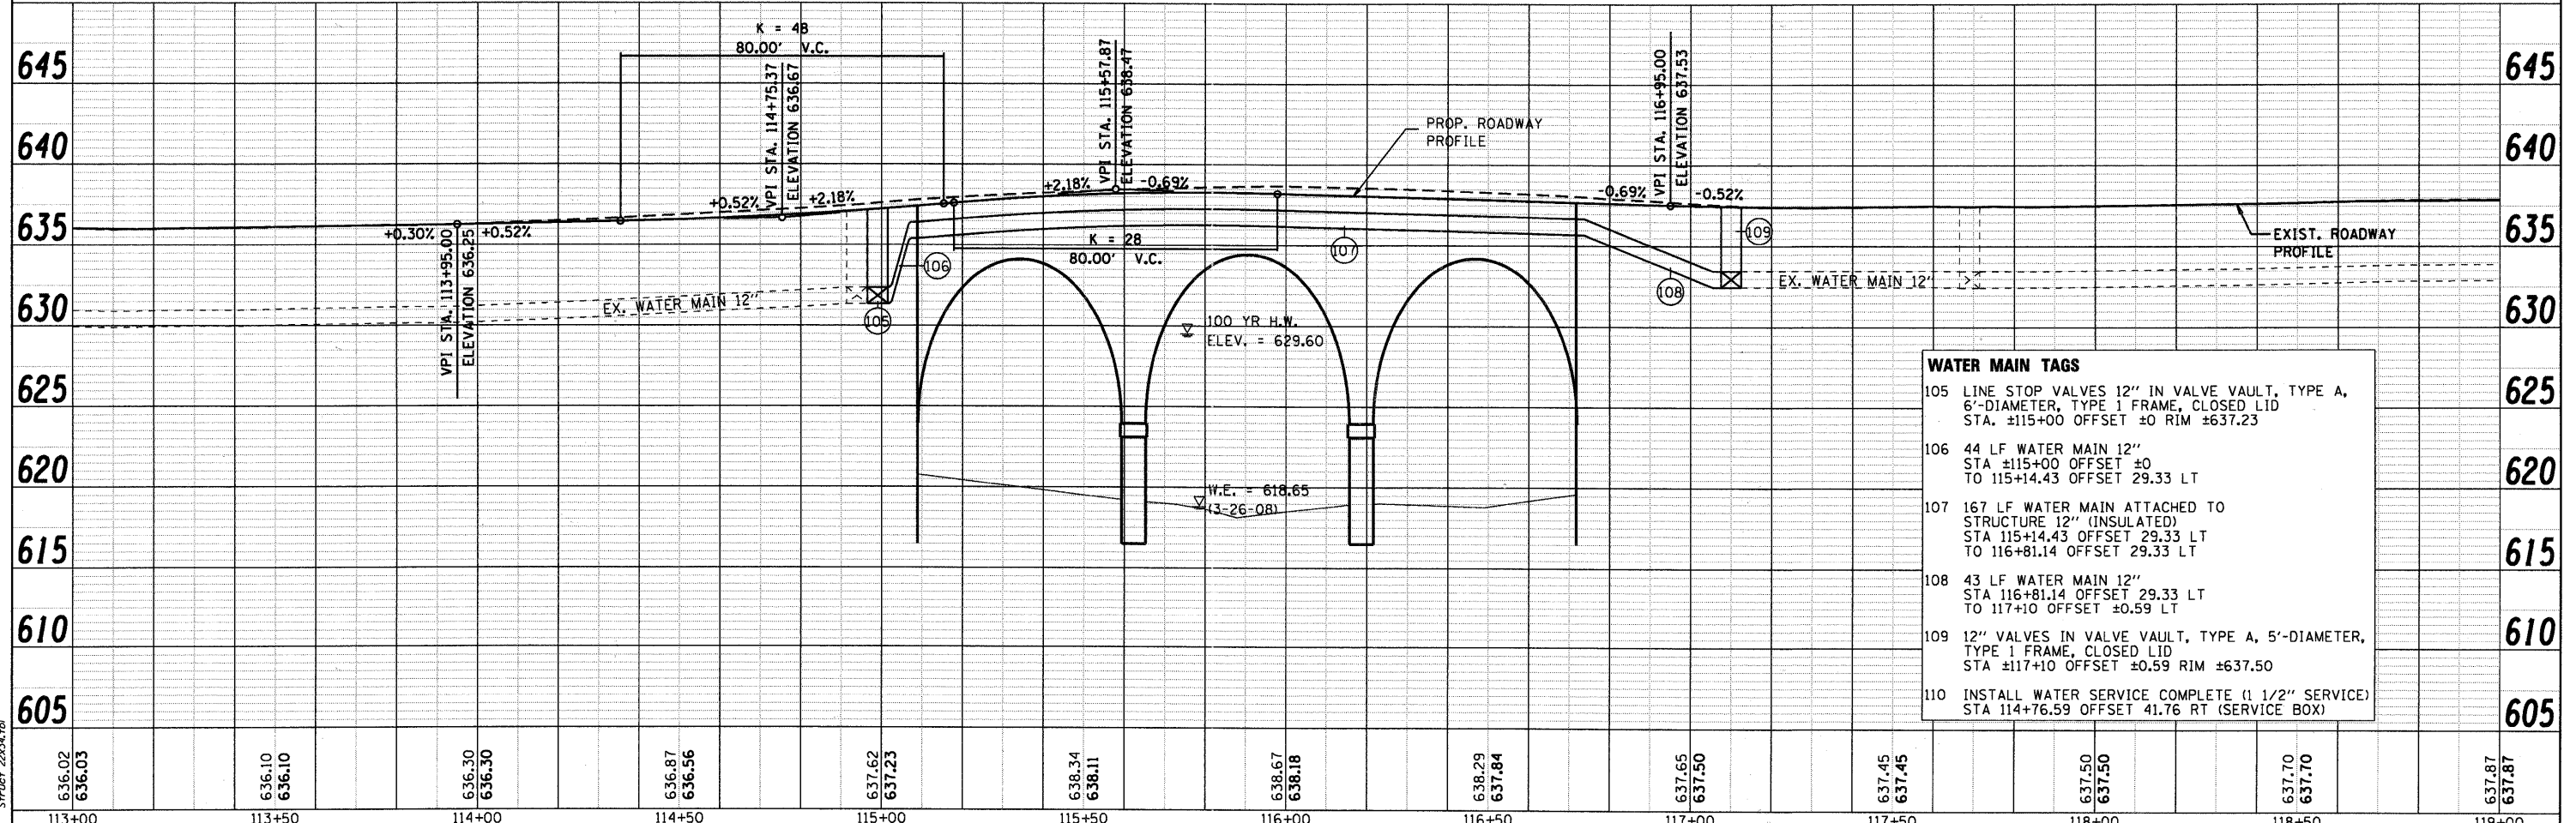



NOTE:
SEE WATER MAIN DETAILS SHEET 26

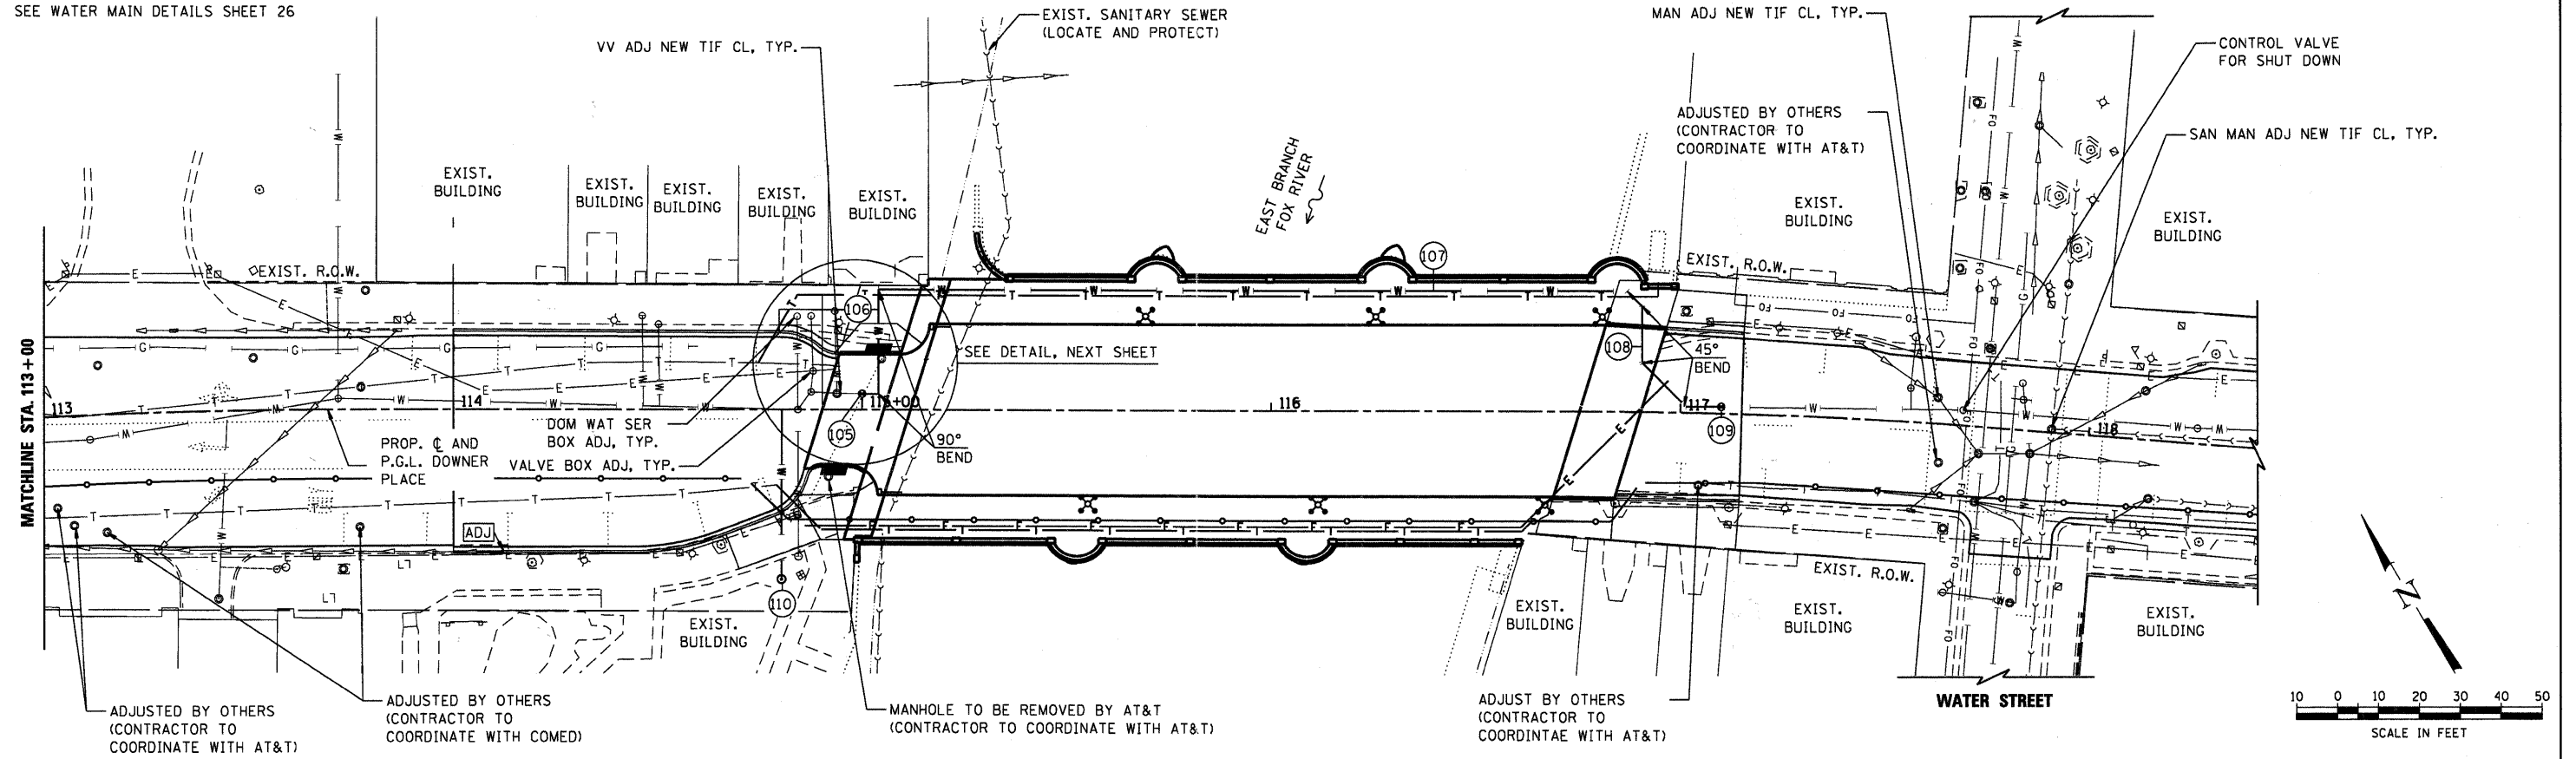

WATER MAIN TAGS	
105	LINE STOP VALVES 12" IN VALVE VAULT, TYPE A, 6'-DIAMETER, TYPE 1 FRAME, CLOSED LID STA. ±115+00 OFFSET ±0 RIM ±637.23
106	44 LF WATER MAIN 12" STA ±115+00 OFFSET ±0 TO 115+14.43 OFFSET 29.33 LT
107	167 LF WATER MAIN ATTACHED TO STRUCTURE 12" (INSULATED) STA 115+14.43 OFFSET 29.33 LT TO 116+81.14 OFFSET 29.33 LT
108	43 LF WATER MAIN 12" STA 116+81.14 OFFSET 29.33 LT TO 117+10 OFFSET ±0.59 LT
109	12" VALVES IN VALVE VAULT, TYPE A, 5'-DIAMETER, TYPE 1 FRAME, CLOSED LID STA ±117+10 OFFSET ±0.59 RIM ±637.50
110	INSTALL WATER SERVICE COMPLETE (1 1/2" SERVICE) STA 114+76.59 OFFSET 41.76 RT (SERVICE BOX)

COMPANY NAME: HRGreen
 PROJECT CONTACT: Michael G. Harrold
 CLIENT: City of Aurora
 FILE NAME: 86890472-uttl1-pnp02.dgn
 PLOT DRIVER: pnp02.dgn
 PEN TABLE: Struct 22x34.tbl

636.02 636.03	636.10 636.10	636.30 636.30	636.87 636.56	637.62 637.23	638.34 638.11	638.67 638.18	638.29 637.84	637.65 637.50	637.45 637.45	637.50 637.50	637.70 637.70	637.87 637.87
113+00	113+50	114+00	114+50	115+00	115+50	116+00	116+50	117+00	117+50	118+00	118+50	119+00



USER NAME = whood	DESIGNED - JPG	REVISED -
FILE NAME = 86890472-uttl1-pnp02.dgn	DRAWN - WJH	REVISED -
PLOT SCALE = 1"=20'	CHECKED - MGH	REVISED -
PLOT DATE = 7/26/2011	DATE - 7/26/11	REVISED -

CITY OF AURORA

UTILITY PLAN AND PROFILE
DOWNER PLACE

SCALE: 1"=20' SHEET NO. 2 OF 2 SHEETS STA. 107+00 TO STA. 113+00

F.A.U. RTE.	SECTION	COUNTY	TOTAL SHEETS	SHEET NO.
	07-00264-00-BR	KANE	164	25
CONTRACT NO. 63620			FED. ROAD DIST. NO. 2 [ILLINOIS] FED. AID PROJECT	