

STATE OF ILLINOIS
DEPARTMENT OF TRANSPORTATION
DIVISION OF HIGHWAYS

PLANS FOR PROPOSED FEDERAL AID HIGHWAY

F. A. P. NO.	SECTION	COUNTY	TOTAL SHEETS	SHEET NO.
348	06-00054-00-LT	COOK	19	1
STA. SEE MAP BELOW TO STA. SEE MAP BELOW				
FED. ROAD DIST. NO. 1 ILLINOIS FED. AID PROJECT ARR - 0001(808)				

CONTRACT #63477


INDEX OF SHEETS

1. COVER SHEET
2. SUMMARY OF QUANTITIES
- 3.-9. STREET LIGHTING PLANS
- 10.-11. SINGLE LINE WIRING DIAGRAM
- 12.-17. DETAIL DRAWINGS
18. IDOT DISTRICT 1 DETAIL BE 305
19. IDOT DISTRICT 1 DETAIL TC 22

STATE STANDARDS

- | | |
|-----------|--|
| 000001-05 | STANDARD SYMBOLS, ABBREVIATIONS AND PATTERNS |
| 701501-05 | URBAN LANE CLOSURE, 2L, 2W, UNDIVIDED |
| 701606-06 | URBAN LANE CLOSURE, MULTILANE, 2W, WITH MOUNTABLE MEDIAN |
| 701701-06 | URBAN LANE CLOSURE, MULTILANE INTERSECTION |
| 701801-04 | LANE CLOSURE, MULTILANE 1W OR 2W CROSSWALK OR SIDEWALK CLOSURE |
| 701901-01 | TRAFFIC CONTROL DEVICES |


STREET LIGHTING
HARLEM AVENUE IL. 43(FAP 348)
71ST STREET TO 93RD STREET
PROJECT NO.: ARA- 00D1(808)
SECTION NO.: 06-00054-00-LT
VILLAGE of BRIDGEVIEW,
COOK COUNTY
C-91-068-10

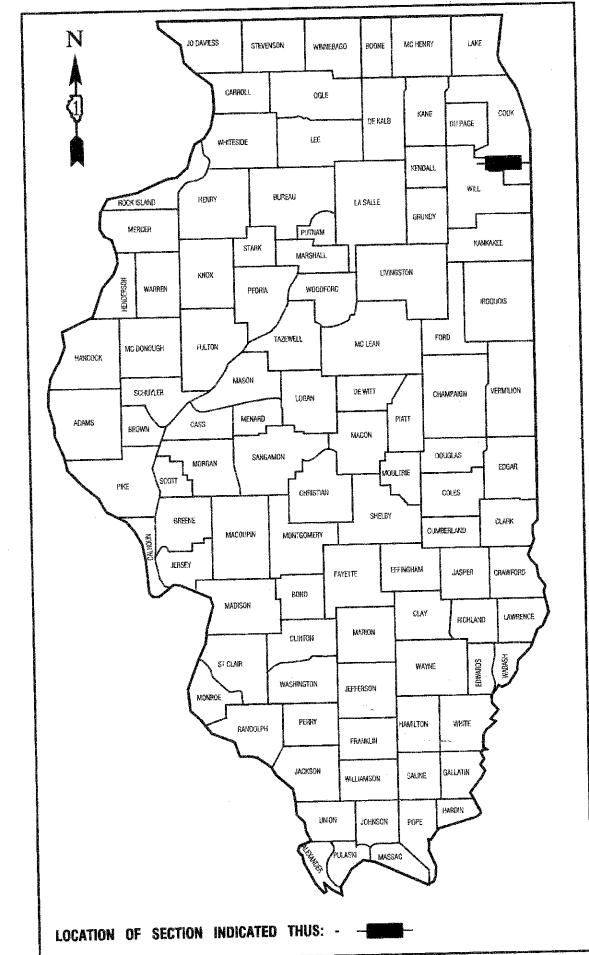

HARLEM AVENUE URBAN ARTERIAL
ADT=42,050 (2009)
=45,000 (2030)
DESIGN SPEED=40 MPH
SPEED LIMIT= 35 MPH

SCALES

PLAN -	1"=50'
PROFILE HORIZ. -	1"=50'
PROFILE VERT. -	1"=5'
CROSS SECTIONS -	1"=10'

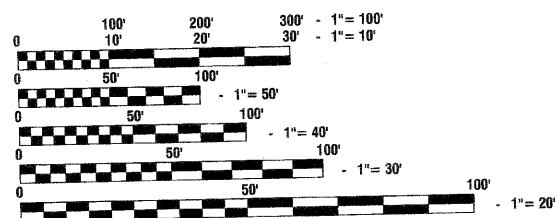


FULL SIZE PLANS HAVE BEEN PREPARED USING STANDARD ENGINEERING SCALES, REDUCED SIZED PLANS WILL NOT CONFORM TO STANDARDS, IN MAKING MEASUREMENTS ON REDUCED PLANS, THE ABOVE SCALES MAY BE USED.

J. U. L. I. E.
JOINT UTILITY LOCATION INFORMATION FOR EXCAVATION
1-800-892-0123 or 811

CONTRACT NO. 63477

BEGIN PROJECT
HARLEM AVENUE STA 354+00

END PROJECT
HARLEM AVENUE STA 500+90

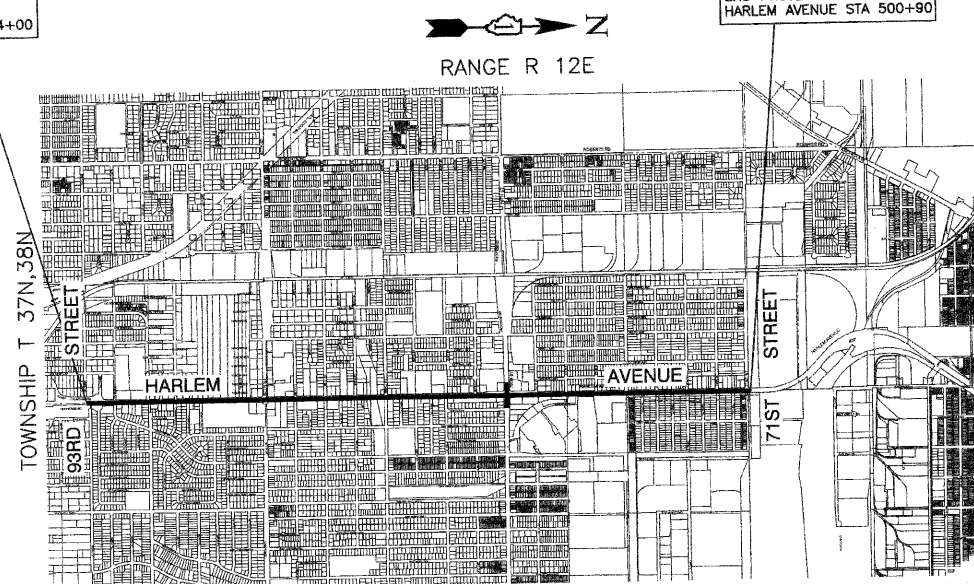

LOCATION MAP

- INDICATES PROPOSED IMPROVEMENT
GROSS LENGTH=14,690 FEET=2.78 MILES
NET LENGTH=14,690 FEET=2.78 MILES

STATE OF ILLINOIS DEPARTMENT OF TRANSPORTATION
DIVISION OF HIGHWAYS

Approved 7-16-2010
Steve Luber
President, Village of Bridgeview

Passed AUGUST 24, 2010
Charles A. ...
District 1 Engineer of Local Roads & Streets

Released for Bid
Based on Limited
Review AUGUST 24, 2010
Diane M. O'Keefe
Deputy Director of Highways, Region 1 Engineer

PRINTED BY THE AUTHORITY OF
THE STATE OF ILLINOIS

PREPARED BY OR UNDER THE
DIRECT SUPERVISION OF:

Edward J. ...
7-19-2010



LICENSE EXPIRES: 11/30/11

PROGRAM AND OFFICE ENGINEER: CHARLES F. RIDDLE, P.E., 847-705-4406 SCHAUMBURG, IL
CONSULTANTS: ROBINSON ENGINEERING, LTD. 708-331-6700