


ROADWAY LIGHTING POLE

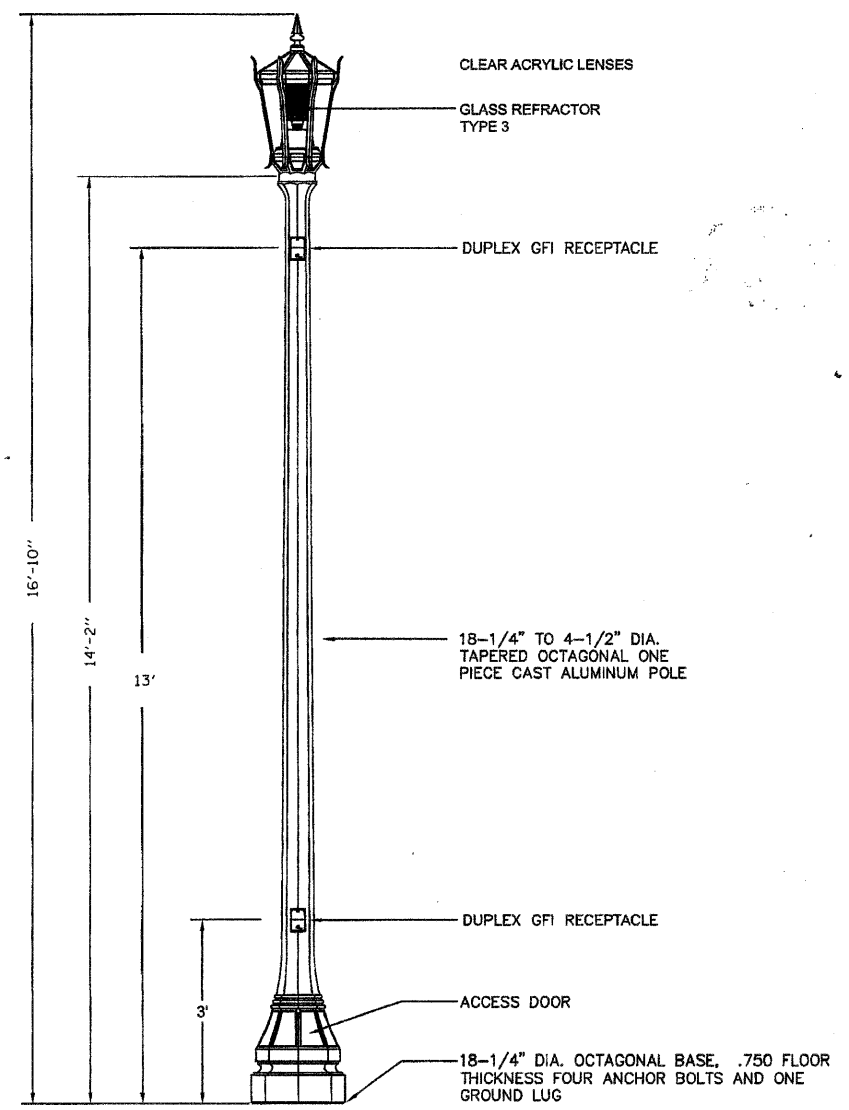

PEDESTRIAN LIGHTING POLE

LUMINAIRE SCHEDULE						
SYMBOL	LABEL	QTY	DESCRIPTION	LAMP	POLE/BASE	
	STREET LIGHTS	20	CAST, ALUMINUM HOUSING CLEAR, ASYMMETRIC GLASS REFRACTOR	250 WATT HPS WITH 27,500 INITIAL DELIVERED LUMENS OR 200 WATT HPS WITH 21,400 INITIAL DELIVERED LUMENS, SEE WIRING PLAN, SHEET 49.	CAST ALUMINUM 27' HEIGHT, 8" OCTAGONAL POLE 32" H., 26" W. DECORATIVE BASE	
	PEDESTRIAN LIGHTS	12	CAST, ALUMINUM HOUSING CLEAR, ASYMMETRIC GLASS REFRACTOR	100 WATT HPS WITH 16,000 INITIAL DELIVERED LUMENS	CAST ALUMINUM 16' HEIGHT, 5" OCTAGONAL POLE 18" WIDE DECORATIVE BASE	



EXPIRES: 11/30/2011

Thomas Memminger
 THOMAS MEMMINGER
 ELECTRICAL ENGINEER

8/11/2010
 DATE

FILE NAME = #FILE#	USER NAME = #USER#	DESIGNED - TM	REVISED -
		DRAWN - RAH	REVISED -
	PLOT SCALE = #SCALE#	CHECKED - TM	REVISED -
	PLOT DATE = 8/11/2010	DATE -	REVISED -

STATE OF ILLINOIS
 DEPARTMENT OF TRANSPORTATION

MISCELLANEOUS ELECTRICAL DETAILS C

SCALE: N.T.S. SHEET NO. 31 OF 49 SHEETS STA. TO STA.

F.A. RTE.	SECTION	COUNTY	TOTAL SHEETS	SHEET NO.
N/A	05-00017-00-FP	SCHUYLER	49	31
FED. ROAD DIST. NO.		ILLINOIS FED. AID PROJECT		

CONTRACT NO. 93541