
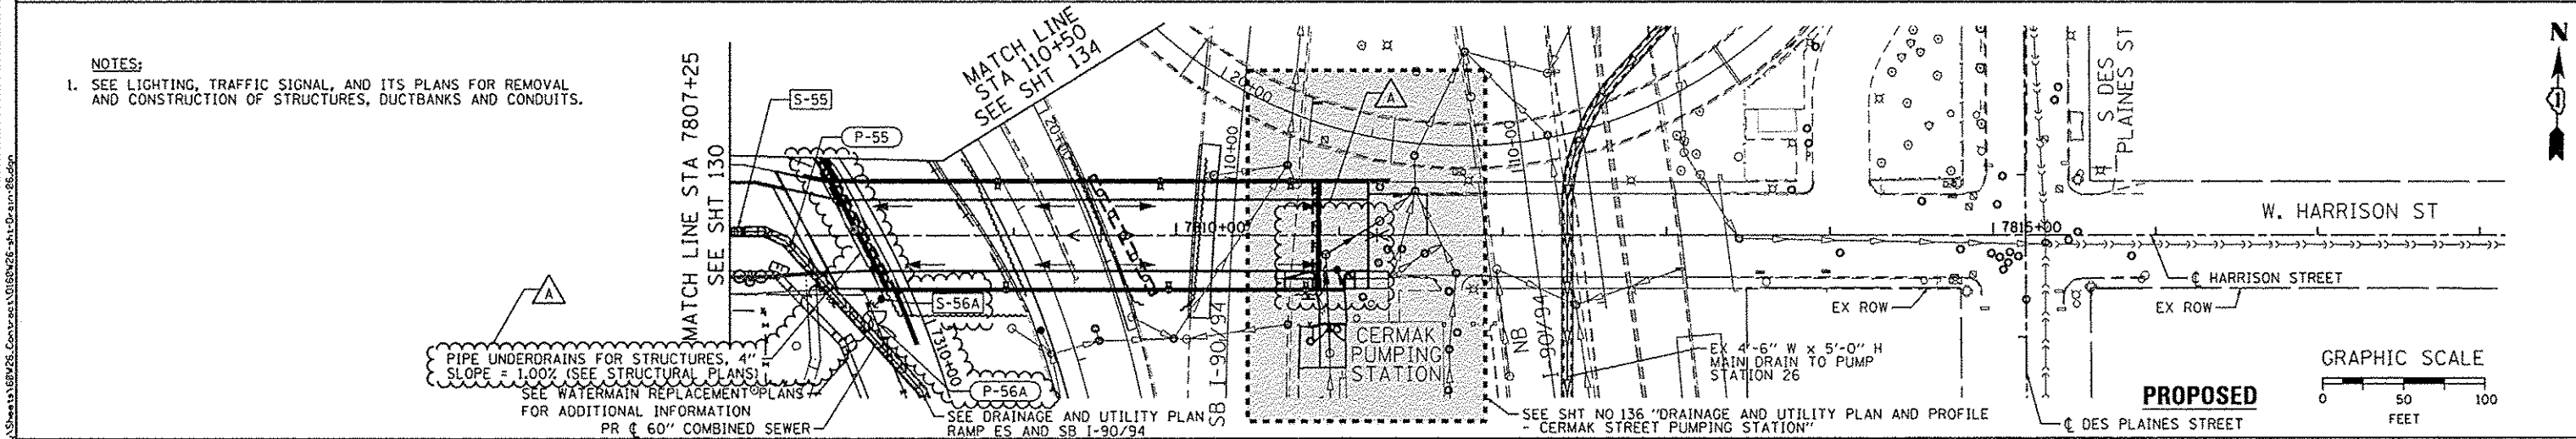


DATE	
BY	
PLANNED	
REVISIONS	
NO.	
DATE	
BY	
DESCRIPTION	
NO.	
DATE	
BY	
DESCRIPTION	
NO.	


DATE	
BY	
PLANNED	
REVISIONS	
NO.	
DATE	
BY	
DESCRIPTION	
NO.	
DATE	
BY	
DESCRIPTION	
NO.	

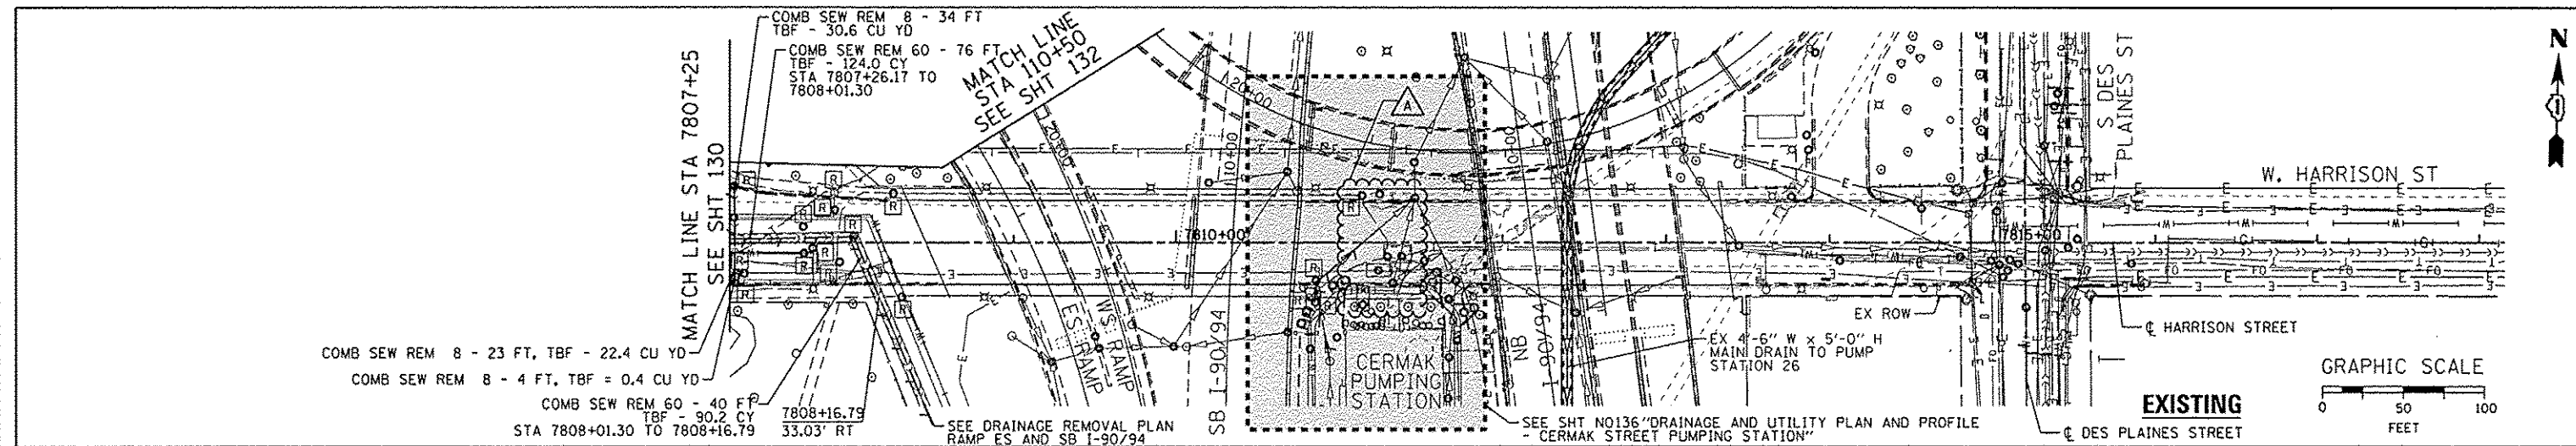

NOTES:  
 1. SEE LIGHTING, TRAFFIC SIGNAL, AND ITS PLANS FOR REMOVAL AND CONSTRUCTION OF STRUCTURES, DUCTBANKS AND CONDUITS.

PIPE UNDERDRAINS FOR STRUCTURES, 4" SLOPE = 1.00% (SEE STRUCTURAL PLANS)  
 SEE WATERMAIN REPLACEMENT PLANS FOR ADDITIONAL INFORMATION  
 PR 60" COMBINED SEWER

NOTES:  
 EXISTING UTILITIES SHOWN ARE FOR LATERAL REFERENCE ONLY. THE CONTRACTOR IS RESPONSIBLE FOR IDENTIFYING ALL EXISTING SEWERS AND UTILITIES PRIOR TO CONSTRUCTION. THE CONTRACTOR SHALL REFER TO THE UTILITY LOCATION PLANS FOR ADDITIONAL INFORMATION.

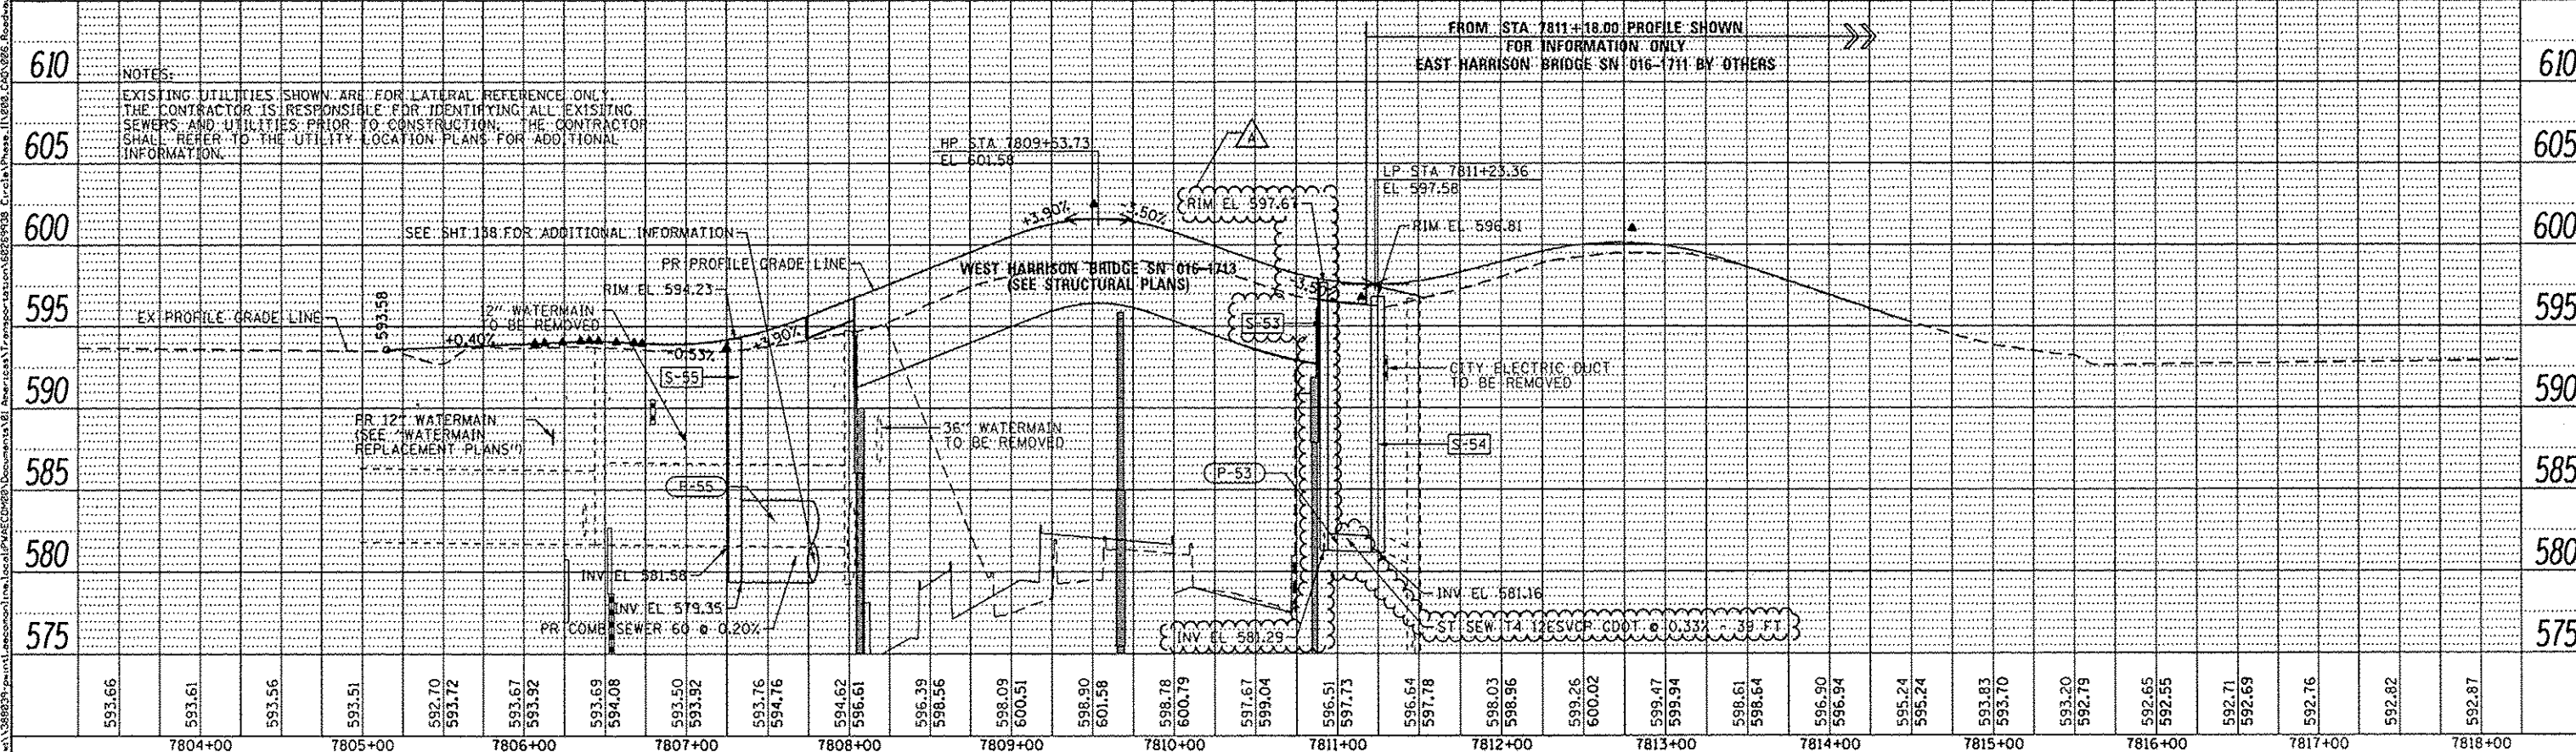

593.66	593.61	593.56	593.51	592.70	593.72	593.67	593.92	593.69	594.08	593.50	593.92	593.76	594.76	594.62	596.61	596.39	598.56	598.09	600.51	598.90	601.58	598.78	600.79	597.67	599.04	596.51	597.73	596.64	597.78	598.03	598.96	599.26	600.02	599.47	599.94	598.61	598.64	596.90	596.94	595.24	595.24	593.83	593.70	593.20	592.79	592.65	592.55	592.71	592.69	592.76	592.82	592.87
7804+00		7805+00		7806+00		7807+00		7808+00		7809+00		7810+00		7811+00		7812+00		7813+00		7814+00		7815+00		7816+00		7817+00		7818+00																								



0160W26-shr-Drain-06.dgn  
 USER NAME = chiuo  
 PLOT SCALE = 50.0000 / in.  
 PLOT DATE = 10/13/2013

DESIGNED - AFC/MSJ  
 DRAWN - AFC/DMS  
 CHECKED - DBM  
 DATE - 09/15/13

REVISED - 10/15/2013  
 REVISED -  
 REVISED -  
 REVISED -

STATE OF ILLINOIS  
 DEPARTMENT OF TRANSPORTATION

DRAINAGE AND UTILITY PLAN AND PROFILE  
 HARRISON STREET

SCALE: 1"=50' SHEET 6 OF 10 SHEETS STA. TO STA.

F.A.I. RTE.	SECTION	COUNTY	TOTAL SHEETS	SHEET NO.
90/94/290	2013-008R	COOK	559	135
CONTRACT NO. 60W26			ILLINOIS FED. AID PROJECT	