


NEW 11,205 WATTS  
OLD 10,523 WATTS

ATLAS NO. N-23  
GROUP NO. 12  
(30) 341 WATT HPS @ 240V  
(5) 195 WATT HPS @ 240V

c:\pwworking\ae.com\00\myer.sc\20130826\160266-sht-1-light-08.dgn  
10/15/2013 12:04:49 PM

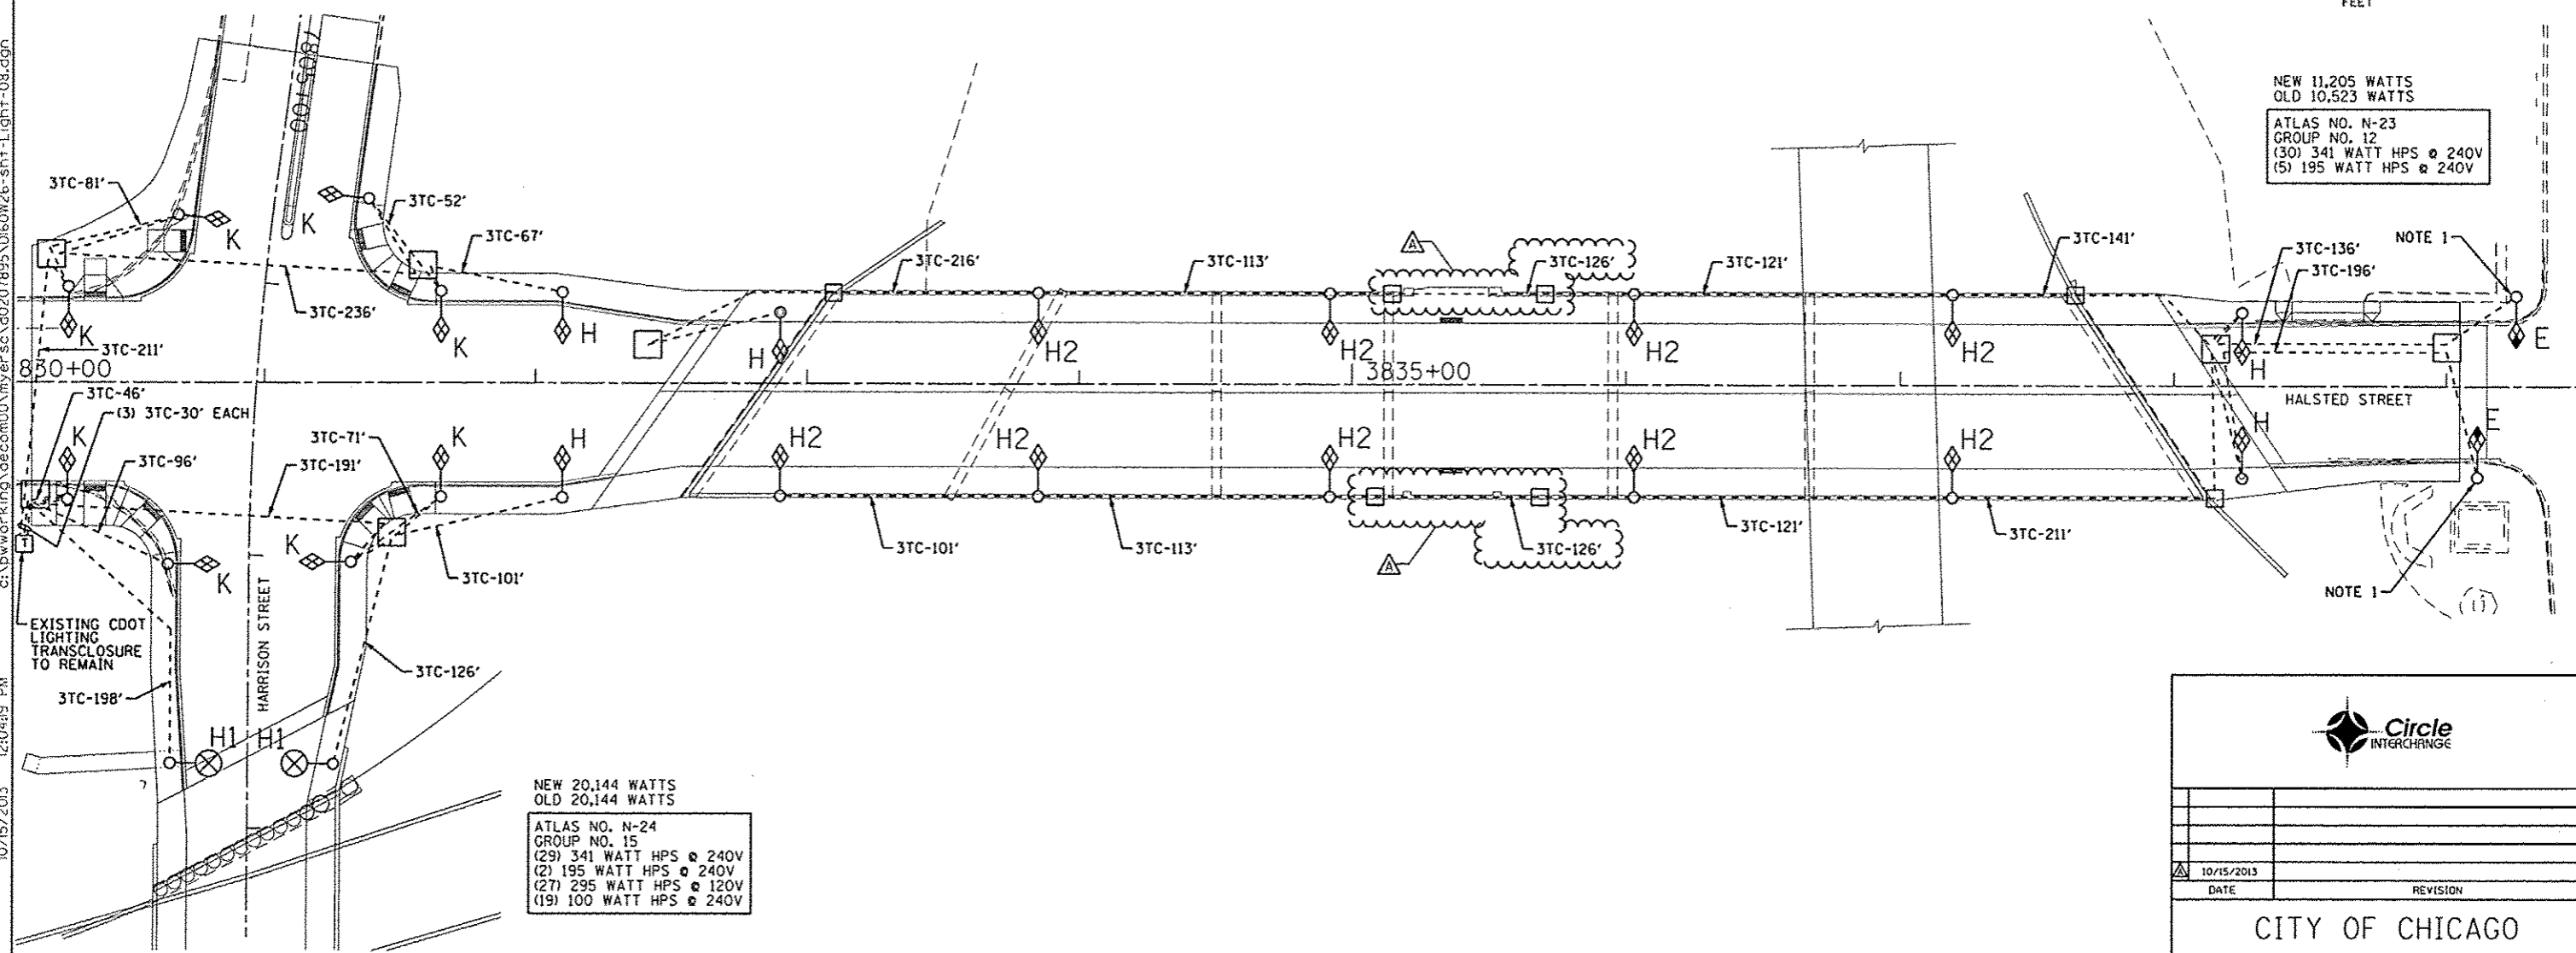

NEW 20,144 WATTS  
OLD 20,144 WATTS

ATLAS NO. N-24  
GROUP NO. 15  
(29) 341 WATT HPS @ 240V  
(2) 195 WATT HPS @ 240V  
(27) 295 WATT HPS @ 120V  
(19) 100 WATT HPS @ 240V

EXISTING CDOT LIGHTING TRANSCLUSURE TO REMAIN

**NOTES:**

1. SPLICE NEW CABLES TO EXISTING LIGHTING CIRCUITS LOCATED IN EXISTING POLE.

- "H" INSTALL CDOT FURNISHED STEEL POLE, LUMINAIRE, MAST ARM, POLE BASE, FINIAL AND ALL ASSOCIATED COMPONENTS PER DRAWING NOS. 930, 930A, 930B, 930C AND 931.
- "H1" INSTALL CDOT FURNISHED STEEL POLE, LUMINAIRE, MAST ARM AND BALLAST HOUSING BASE PER DRAWING NOS. 808 AND 785.
- "H2" INSTALL CDOT FURNISHED "RETROFIT" LIGHTING UNIT INCLUDING STEEL POLE, MAST ARM, LUMINAIRE AND ALL ASSOCIATED COMPONENTS PER DRAWING NOS. 762, 837 AND 931.
- "K" INSTALL CDOT FURNISHED MAST ARM AND LUMINAIRE ON A TRAFFIC SIGNAL/LIGHT COMBINATION POLE PER DRAWING NOS. 930, 930C AND 931. SEE TRAFFIC SIGNAL PLANS FOR POLE LOCATIONS.

FOR CONDUIT AND FOUNDATION PLANS SEE DRAWING NOS. E-07 AND E-10.  
FOR LIGHTING REMOVAL PLANS SEE DRAWING NO. E-09.



10/15/2013		REVISION
<b>CITY OF CHICAGO</b>		
DEPARTMENT OF TRANSPORTATION DIVISION OF ENGINEERING		
<b>AECOM</b>		
WORK ORDER NO.	DATE	
COST ALLOCATION ACCOUNT		
APPROPRIATION ACCOUNT	MATERIAL	
	LABOR	
HALSTED STREET LIGHTING CABLE AND EQUIPMENT INSTALLATION PLAN		
<b>CITY OF CHICAGO</b>		
DEPT. OF TRANSPORTATION DIVISION OF ELECTRICAL OPERATIONS		
DRAFTSMAN: CAM	CHIEF DRAFTSMAN: WDS	ENGINEER: WDS
SUPERVISING ENGINEER/ELEC. DESIGN ENGR. WDS		<b>E-08</b>
ENGINEER OF ELECTRICITY:		
GEN'L SUPT. OF ELECTRICITY:		
DEPUTY COMMISSIONER:		
SIZE: 22"   34"	SCALE: 1" = 30'	DATE: 9/15/13
DATE: 09/15/13	DWG. NO.:	
C.D.O.T. PROJECT NO.:	8 OF 22	