


F.A.P. RTE.	SECTION	COUNTY	TOTAL SHEETS	SHEET NO.
668		SANGAMON	354	148
STA. 5+250	TO STA. 5+910			
FED. ROAD DIST. NO.	ILLINOIS	FED. AID PROJECT		
CONTRACT NO. 72501				


TYPICAL PAVEMENT MARKING LEGEND

- | | |
|--|---|
| ① MODIFIED URETHANE PM 125 (5) (9.14M SKIP-3.05M DASH, YELLOW) | ⑨ MODIFIED URETHANE PM 300 (12) CHEVRONS & DIAGONALS (WHITE) |
| ② MODIFIED URETHANE PM 125 (5) SOLID (YELLOW) | ⑩ PREF. PL. TYPE B INLAID PM 125 (5) (9.14M SKIP-3.05M DASH, WHITE) |
| ③ MODIFIED URETHANE PM 125 (5) SOLID (DOUBLE-YELLOW) | ⑪ PREF. PL. TYPE B INLAID PM 600 (24) STOP BAR (WHITE) |
| ④ MODIFIED URETHANE PM 300 (12) DIAGONAL (YELLOW) | ⑫ PREF. PL. TYPE B INLAID PM LETTERS AND SYMBOLS |
| ⑤ MODIFIED URETHANE PM 125 (5) SOLID (WHITE) | ⑬ GROOVING FOR RECESSED PAVEMENT MARKING 152 (6) |
| ⑥ MODIFIED URETHANE PM 150 (6) SOLID (WHITE) | ⑭ GROOVING FOR RECESSED PAVEMENT MARKING 178 (7) |
| ⑦ MODIFIED URETHANE PM 150 (6) (1.83M SKIP-0.61M DASH, WHITE) | ⑮ GROOVING FOR RECESSED PAVEMENT MARKING 229 (9) |
| ⑧ MODIFIED URETHANE PM 200 (8) SOLID (WHITE) | ⑯ GROOVING FOR RECESSED PAVEMENT MARKING 330 (13) |

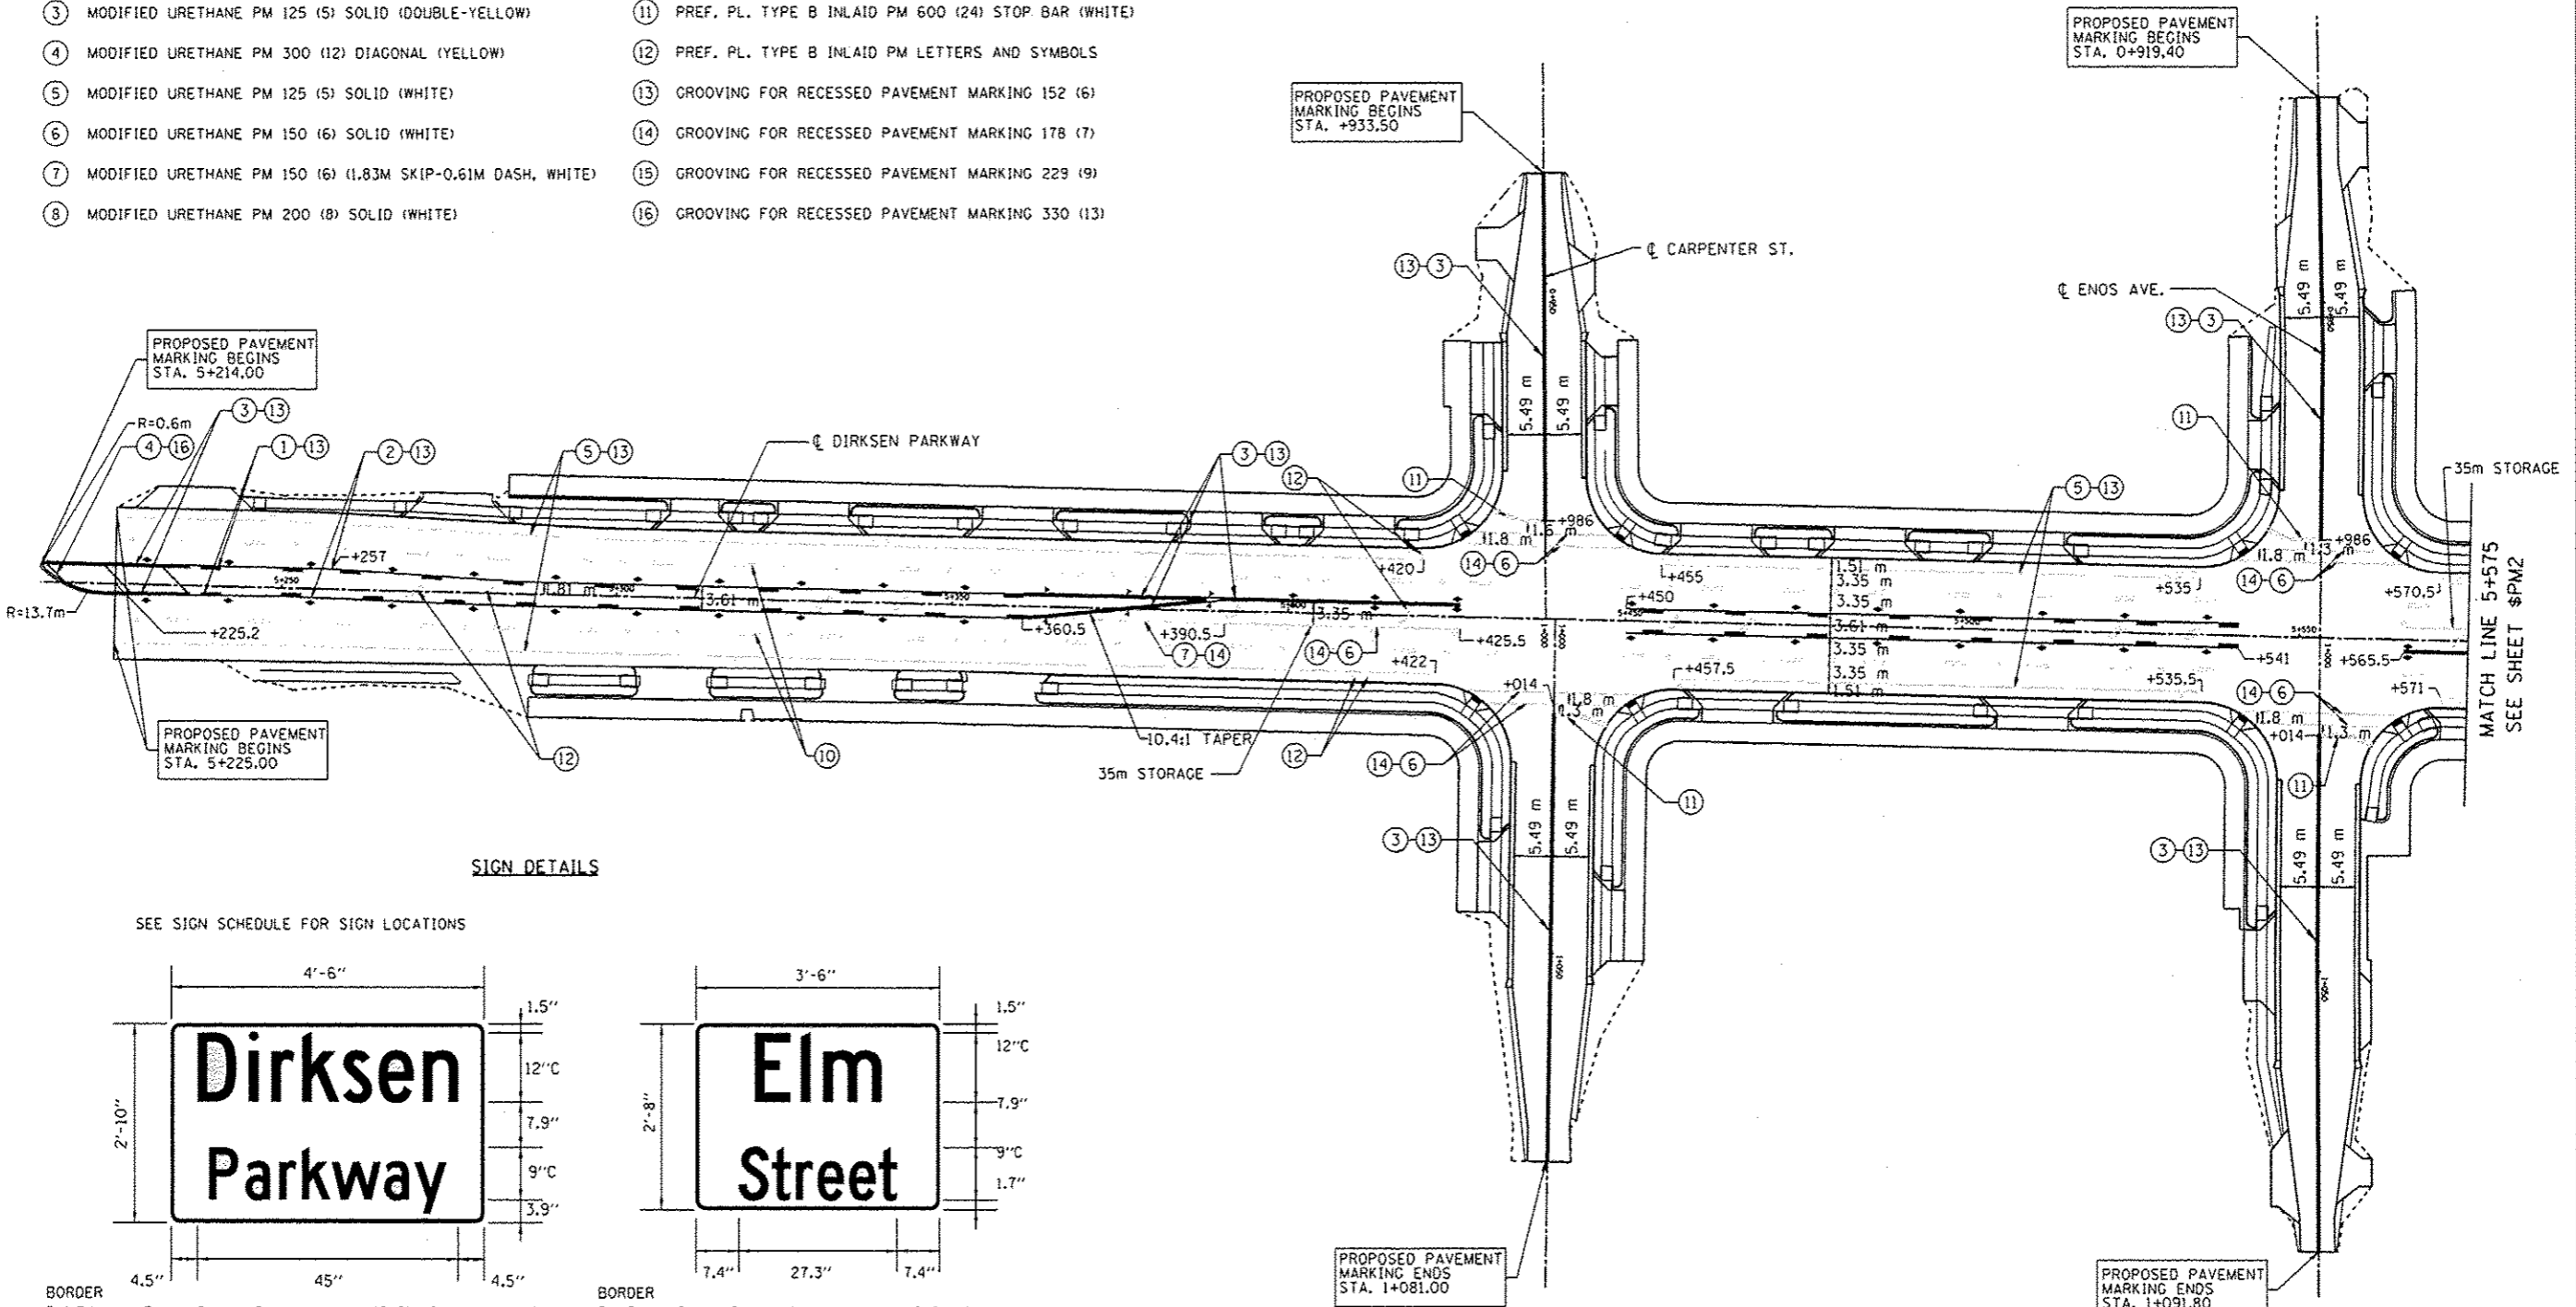


SIGN DETAILS

SEE SIGN SCHEDULE FOR SIGN LOCATIONS

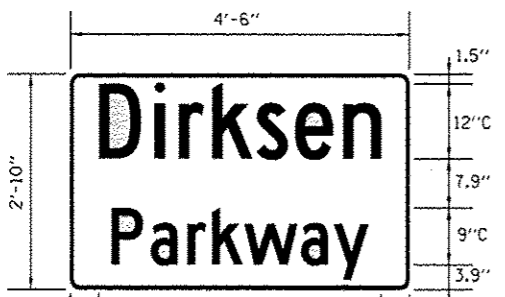

BORDER R=1.5" TH=0.5" Panel Style: Street Name 12-9in.Overhead.ssi M.U.T.C.D.: 2009 Edition

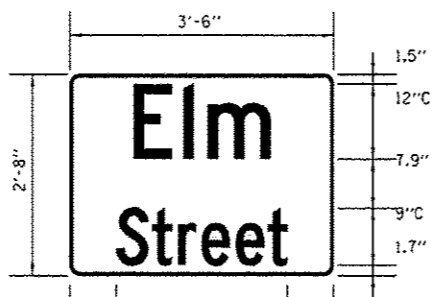


BORDER R=1.5" TH=0.5" Panel Style: Street Name 12-9in.Overhead.ssi M.U.T.C.D.: 2009 Edition

TYPICAL PAVEMENT MARKERS LEGEND

- ◀ ONE-WAY CRYSTAL MARKER - 24.4M CTS. (TYP.)
- ◀ ONE-WAY AMBER MARKER - 12.2M CTS. (TYP.)
- ◆ TWO-WAY AMBER MARKER - 12.2M CTS. (TYP.)

NOTE:

 ALL PROPOSED PAVEMENT MARKINGS SHALL CONFORM TO THE "DISTRICT 6 PAVEMENT MARKING STANDARDS".



REVISIONS	
NAME	DATE

ILLINOIS DEPARTMENT OF TRANSPORTATION
 PAVEMENT MARKINGS AND SIGN DETAILS
 F.A.P. ROUTE 668 (DIRKSEN PARKWAY)
 SECTION 28R-1
 SANGAMON COUNTY

SCALE 1 : 500
 DATE 06/2013
 DRAWN BY RK
 CHECKED BY FML