
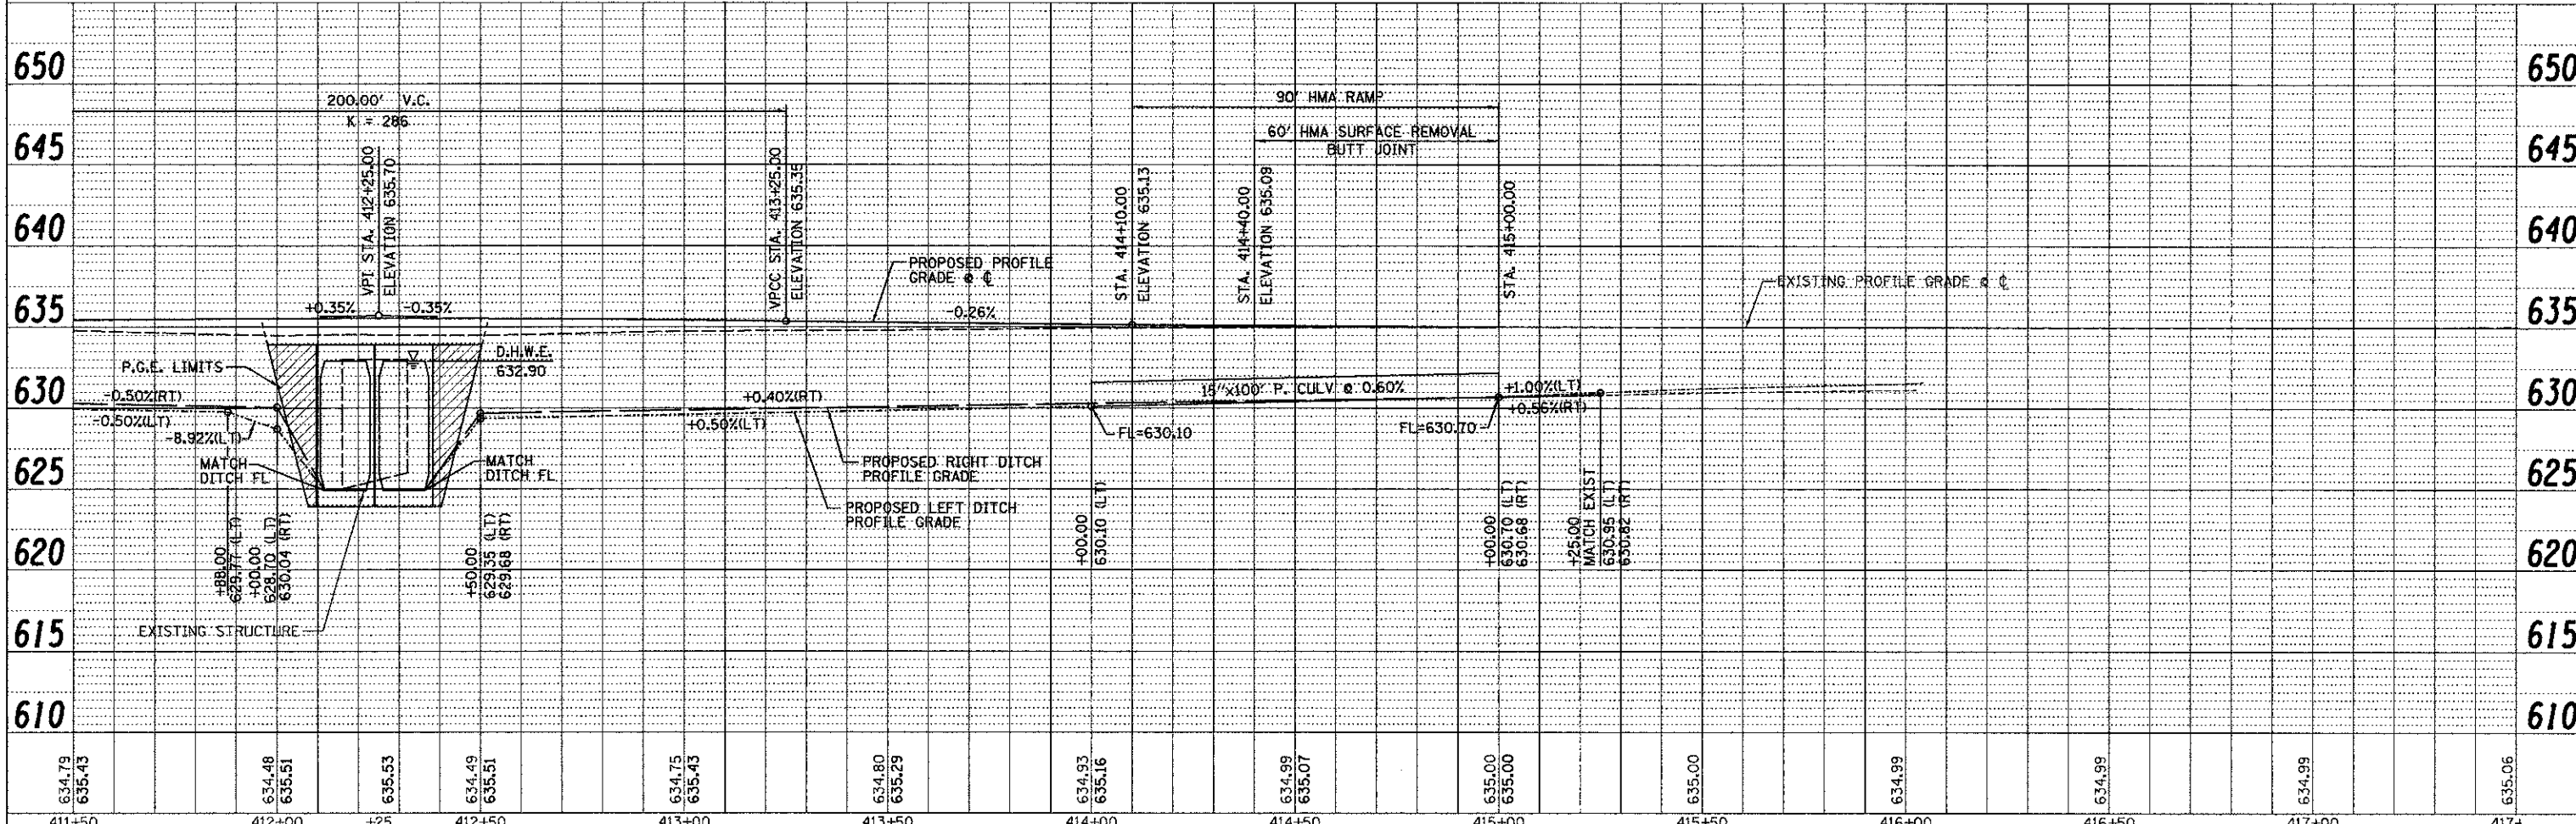


DATE: \_\_\_\_\_  
 BY: \_\_\_\_\_  
 SURVEYED \_\_\_\_\_  
 PLAN \_\_\_\_\_  
 NOTE BOOK \_\_\_\_\_  
 NO. \_\_\_\_\_

DATE: \_\_\_\_\_  
 BY: \_\_\_\_\_  
 SURVEYED \_\_\_\_\_  
 PROFILE \_\_\_\_\_  
 NOTE BOOK \_\_\_\_\_  
 NO. \_\_\_\_\_

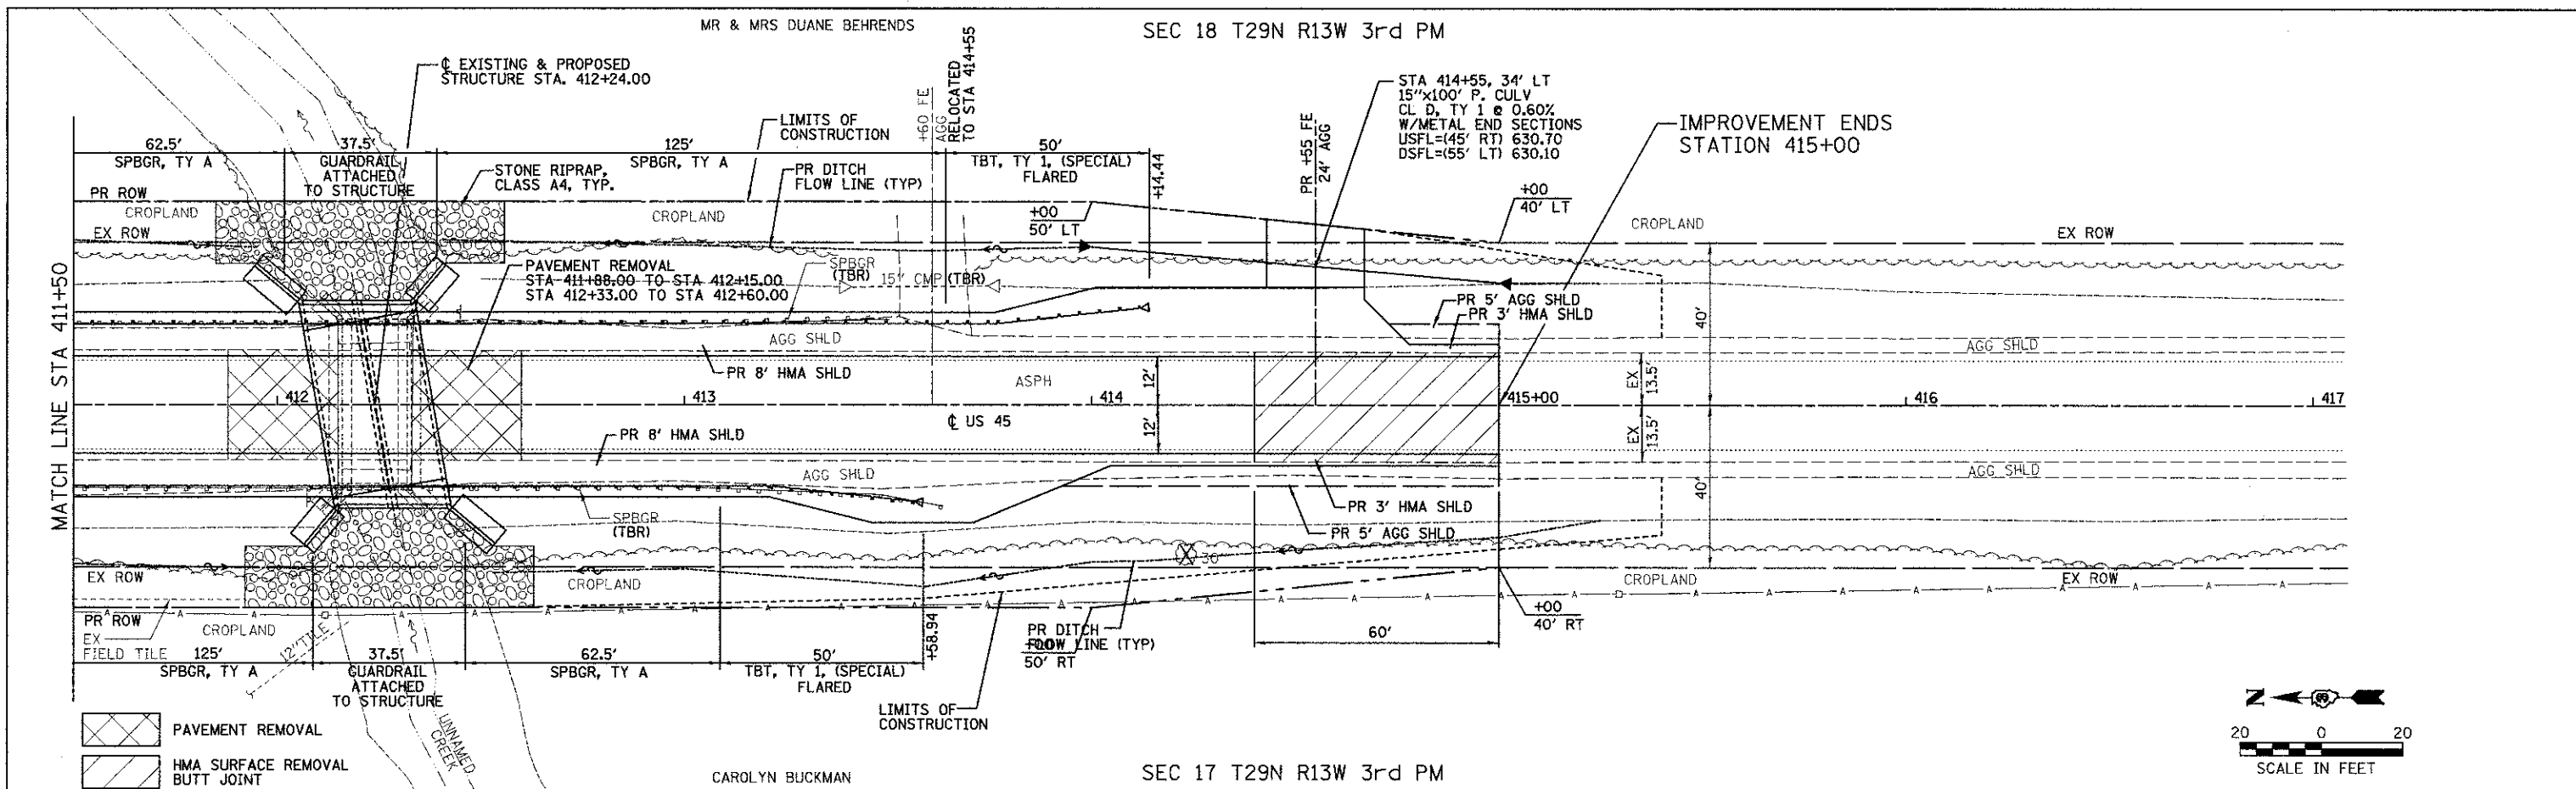

FILE NAME: #FILE#	USER NAME: #USER#	DESIGNED: JML	REVISED: -	<b>STATE OF ILLINOIS DEPARTMENT OF TRANSPORTATION</b>	<b>PLAN AND PROFILE</b>	F.A.P. RTE. 840	SECTION 138 BR-3	COUNTY IROQUOIS	TOTAL SHEETS 28	SHEET NO. 10		
PLOT SCALE: #SCALE#	CHECKED: JML	DATE: 07-27-11	REVISED: -			SCALE: _____	SHEET NO. _____	OF _____	SHEETS _____	STA. _____	TO STA. _____	CONTRACT NO. 66971
PLOT DATE: #DATE#	DATE: 07-27-11	REVISED: -	REVISED: -			FED. ROAD DIST. NO. 3 ILLINOIS FED. AID PROJECT						
FARNSWORTH GROUP, INC. CONSULTING ENGINEERS - 2709 MCGRAW DRIVE BLOOMINGTON, ILLINOIS 61704 (309) 663-8435 / (309) 663-1571 FAX 24-8320												