



ALL KEYED NOTES APPLY TO THIS SHEET ONLY.

KEYED NOTES:

1. 2" CONDUIT, 2*4 AND 1*4 GND FOR CIRCUIT LC2-14.
2. 2" CONDUIT, 2*6 AND 1*6 GND FOR CIRCUIT LC2-16.

NOTES:

1. STATIONS AND OFFSETS SHOWN ON THIS SHEET ARE TO THE CENTER OF HANDHOLE AND LIGHT POLE FOUNDATIONS.
2. COORDINATE INSTALLATION OF UNDERGROUND CONDUIT AND LIGHT FIXTURES WITH ALL EXISTING UNDERGROUND SYSTEMS AND PROPOSED LANDSCAPE FEATURES AND PLANTINGS.
3. SEE IRRIGATION PLAN FOR UNDERGROUND CONDUIT AND PIPING. COORDINATE INSTALLATION OF UNDERGROUND UTILITIES.
4. 'F' DESIGNATIONS OF LIGHT FIXTURES SHOWN ON LIGHTING DETAILS SHEET.

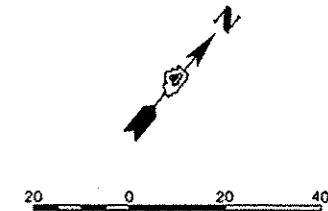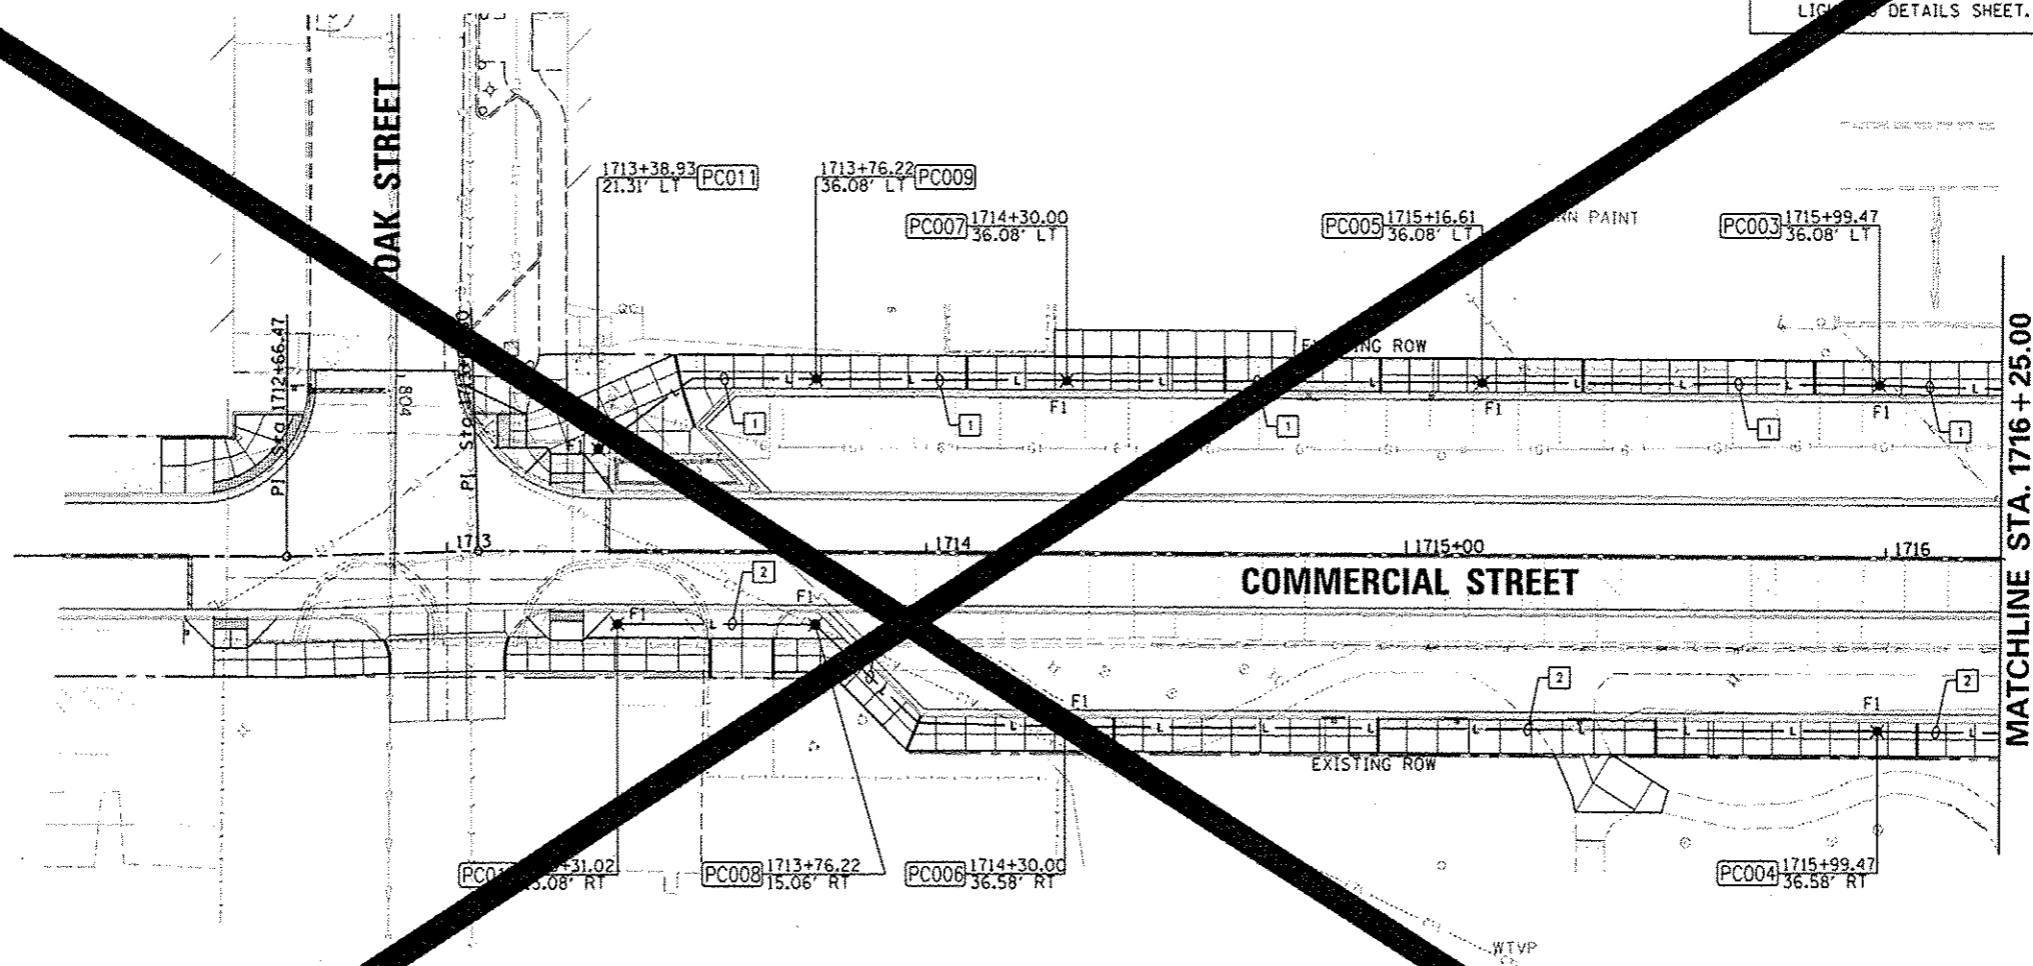

| | | | |
|--|------------------------|------------|-----------|
| FILE NAME * | USER NAME * | DESIGNED - | REVISED - |
| c:\pwise\work\do_not_delete\dms73316\041 | manak01390 | JDE | |
| | FILE NAME * | DRAWN - | REVISED - |
| | l0155-shs-light036.dgn | TMT | |
| | | CHECKED - | REVISED - |
| | | BMS | |
| | | DATE - | REVISED - |
| | | 7/18/12 | |
| | | | |

STATE OF ILLINOIS
DEPARTMENT OF TRANSPORTATION

COMMERCIAL STREET
LIGHTING PLAN

SCALE: 1"=20' SHEET NO. OF SHEETS STA. 1713+00.00 TO STA. 1716+25.00

| | | | | |
|------------------|---------|--------|-------------------------------------|-----------|
| F.A.U. RTE. | SECTION | COUNTY | TOTAL SHEETS | SHEET NO. |
| 12-00356-01-PV | PEORIA | 362 | | |
| CONTRACT NO. 126 | | | ILLINOIS FED. AID PROJECT TIG-50931 | |