



ALL KEYED NOTES APPLY TO THIS SHEET ONLY.

KEYED NOTES:

1. PORTLAND CEMENT CONCRETE 81400100 - HANDHOLE IDOT STANDARD 814001-02. GROUND HANDHOLE PER IDOT STANDARD 873001-02.
2. 2" CONDUIT, 2\*6 AND 1\*6 GND FOR CIRCUIT LC2-8 AND 2\*6 AND 1\*6 GND FOR CIRCUIT LC2-16.
3. 2" CONDUIT, 2\*6 AND 1\*6 GND FOR CIRCUIT LC2-12.
4. 2" CONDUIT, 2\*6 AND 1\*6 GND FOR CIRCUIT LC2-8.
5. 2" CONDUIT, 2\*6 AND 1\*6 GND FOR CIRCUIT LC2-14 AND 2\*6 AND 1\*6 GND FOR CIRCUIT LC2-16.
6. 2" CONDUIT, 2\*6 AND 1\*6 GND FOR CIRCUIT LC2-16.
7. 2" CONDUIT, 2\*6 AND 1\*6 GND FOR CIRCUIT LC2-14.
8. COIL 6' OF CONDUCTORS FOR CIRCUIT LC2-14 IN HANDHOLE, TAPE ENDS AND LABEL FOR FUTURE.
9. COIL 6' OF CONDUCTORS FOR CIRCUIT LC2-16 IN HANDHOLE, TAPE ENDS AND LABEL FOR FUTURE.

NOTES:

1. STATIONS AND OFFSETS SHOWN ON THIS SHEET ARE TO THE CENTER OF HANDHOLE AND LIGHT POLE FOUNDATIONS.
2. COORDINATE INSTALLATION OF UNDERGROUND CONDUIT AND LIGHT FIXTURES WITH ALL EXISTING UNDERGROUND SYSTEMS AND PROPOSED LANDSCAPE FEATURES AND PLANTINGS.
3. SEE IRRIGATION PLANS FOR UNDERGROUND CONDUIT AND PIPING. COORDINATE INSTALLATION OF UNDERGROUND FACILITIES.
4. 'F' DESIGNATIONS OF LIGHT FIXTURES SHOWN ON LIGHTING DETAILS SHEET.

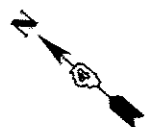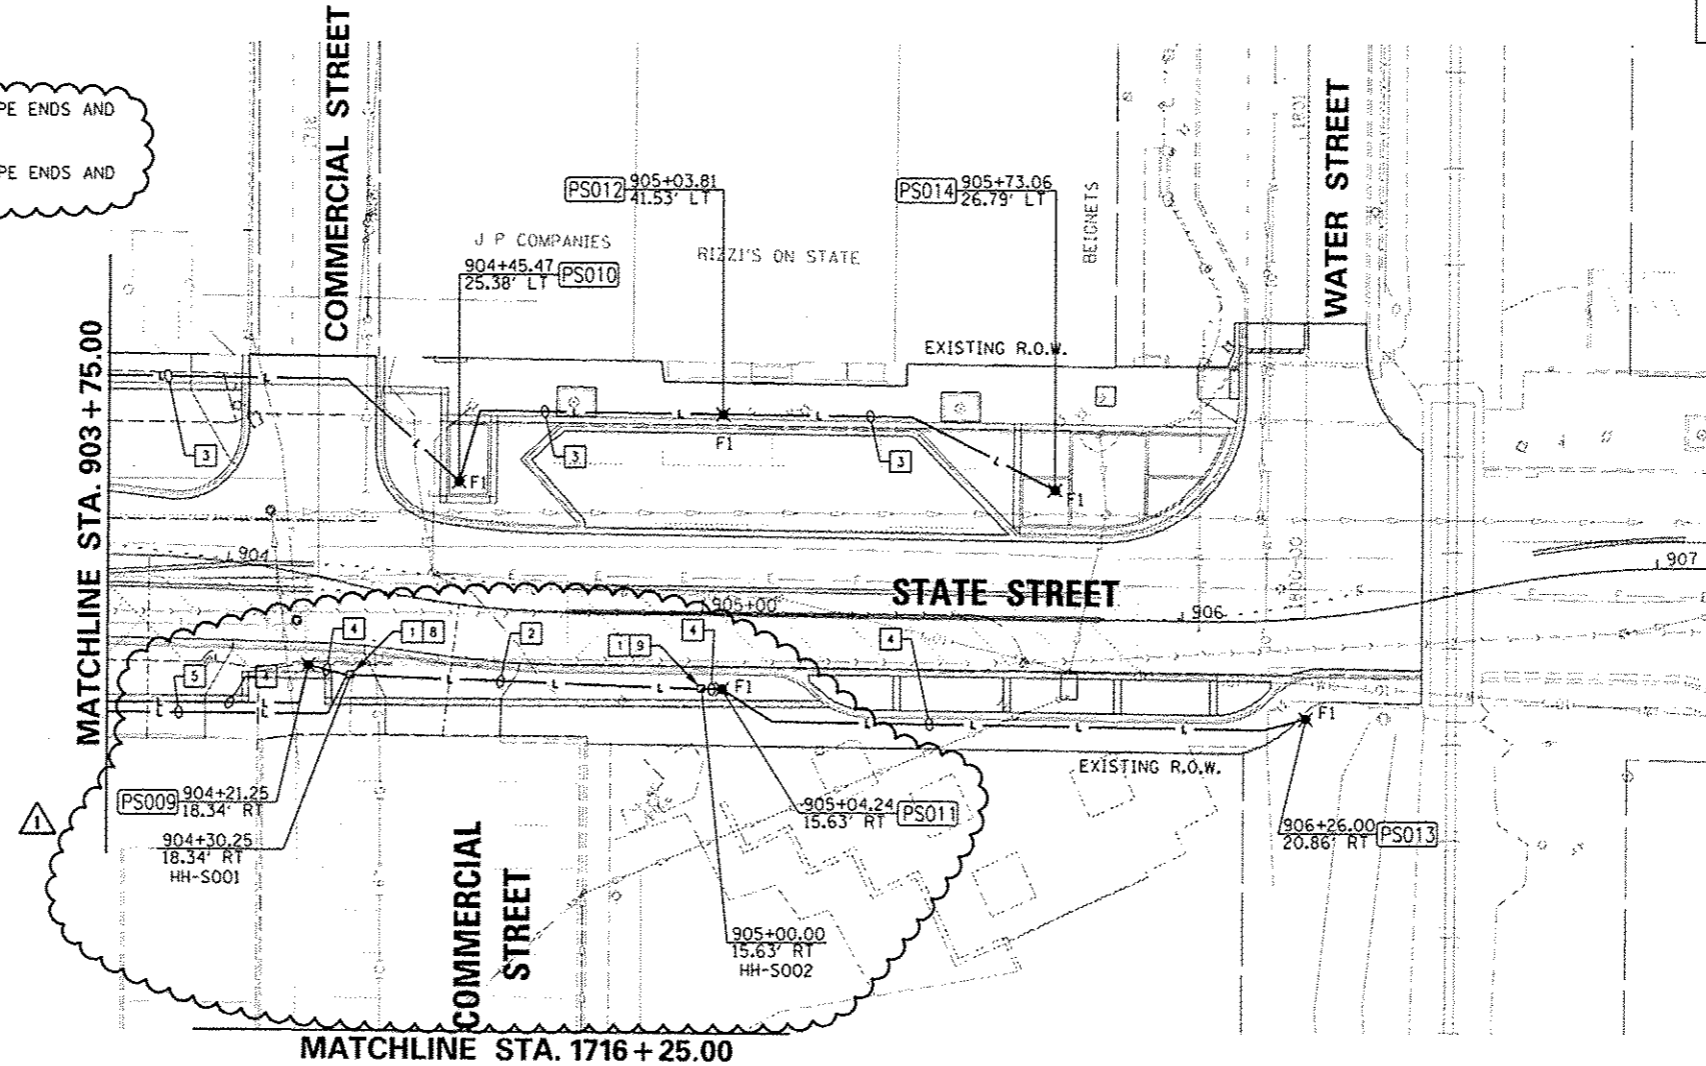

**Farnsworth GROUP**  
 7707 N. KNOXVILLE AVE, SUITE 100  
 PEORIA, ILLINOIS 61614  
 (309) 699-3887 / (309) 699-8820 Fax  
 www.fg.com

FILE NAME : c:\pwise\work\do_not_delete\dms70316\041	USER NAME : dms000070	DESIGNED : JDE	REVISED : 10/24/12
	PLT SCALE : 39.9999' = 1" = 10'	DRAWN : TMT	REVISED : -
	PLT DATE : 10/23/2012	CHECKED : BMS	REVISED : -
		DATE : 10/24/2012	REVISED : -

STATE OF ILLINOIS  
 DEPARTMENT OF TRANSPORTATION

STATE STREET  
 LIGHTING PLAN

SCALE: 1"=20' SHEET NO. OF SHEETS STA. 903+75.00 TO STA. 906+50.00

F.A.U. RTE.	SECTION	COUNTY	TOTAL SHEETS	SHEET NO.
0013	12-00356-01-PV	PEORIA	519	369
CONTRACT NO. 89626				

ILLINOIS FED. AID PROJECT TIG-509315B1