

ALL KEYED NOTES APPLY TO THIS SHEET ONLY.

KEYED NOTES:

1. PORTLAND CEMENT CONCRETE 81400100 - HANDHOLE IDOT STANDARD 814001-02. GROUND HANDHOLE PER IDOT STANDARD 873001-02.
2. 2" CONDUIT, 2\*6 AND 1\*6 GND FOR CIRCUIT LC4-8 AND 2\*6 AND 1\*6 GND FOR CIRCUIT LC4-10.
3. 2" CONDUIT, 2\*6 AND 1\*6 GND FOR CIRCUIT LC4-3.
4. 2" CONDUIT, 2\*6 AND 1\*6 GND FOR CIRCUIT LC4-4.
5. LIGHTING CONTROLLER, BASE MOUNTED, 240V, 200 AMP, \*LC4.
6. 2" CONDUIT, 2\*6 AND 1\*6 GND FOR CIRCUIT LC4-2.
7. 2" CONDUIT, 2\*6 AND 1\*6 GND FOR CIRCUIT LC4-1.
8. 2" CONDUIT, 2\*6 AND 1\*6 GND FOR CIRCUIT LC4-1 AND 2\*6 AND 1\*6 GND FOR CIRCUIT LC4-3.

KEYED NOTES (CONTINUED):



9. 2" CONDUIT, 2\*6 AND 1\*6 GND FOR CIRCUIT LC4-2 AND 2\*6 AND 1\*6 GND FOR CIRCUIT LC4-4.
10. 2" CONDUIT, 2\*6 AND 1\*6 GND FOR CIRCUIT LC4-5.
11. 2" CONDUIT, 2\*6 AND 1\*6 GND FOR CIRCUIT LC4-6.
12. 2" CONDUIT, 2\*6 AND 1\*6 GND FOR CIRCUIT LC4-7 AND 2\*4 AND 1\*4 GND FOR CIRCUIT LC4-9.
13. 3" CONDUIT, 2\*6 AND 1\*6 GND FOR CIRCUIT LC4-1 AND 2\*6 AND 1\*6 GND FOR CIRCUIT LC4-3 AND 2\*6 AND 1\*6 GND FOR CIRCUIT LC4-5 AND 2\*6 AND 1\*6 GND FOR CIRCUIT LC4-7 AND 2\*4 AND 1\*4 GND FOR CIRCUIT LC4-9.
14. 3" CONDUIT, 2\*6 AND 1\*6 GND FOR CIRCUIT LC4-1 AND 2\*6 AND 1\*6 GND FOR CIRCUIT LC4-2 AND 2\*6 AND 1\*6 GND FOR CIRCUIT LC4-3 AND 2\*6 AND 1\*6 GND FOR CIRCUIT LC4-4 AND 2\*6 AND 1\*6 GND FOR CIRCUIT LC4-5 AND 2\*6 AND 1\*6 GND FOR CIRCUIT LC4-7 AND 2\*4 AND 1\*4 GND FOR CIRCUIT LC4-9.

KEYED NOTES (CONTINUED):

15. SEE MAST ARM LOADING DIAGRAMS FOR TRAFFIC CONTROL DEVICES MOUNTED TO THIS POLE.
16. COIL 6' WIRE FOR CIRCUIT LC4-4 IN HANDHOLE. TAPE ENDS AND LABEL FOR FUTURE EXTENSION.

NOTES:

1. STATIONS AND OFFSETS SHOWN ON THIS SHEET ARE TO THE CENTER OF HANDHOLE AND LIGHT POLE FOUNDATIONS.
2. COORDINATE INSTALLATION OF UNDERGROUND CONDUIT AND LIGHT FIXTURES WITH ALL EXISTING UNDERGROUND SYSTEMS AND PROPOSED LANDSCAPE FEATURES AND PLANTINGS.
3. SEE IRRIGATION PLANS FOR UNDERGROUND CONDUIT AND PIPING. COORDINATE INSTALLATION OF UNDERGROUND FACILITIES.
4. UTILITY SERVICE FROM AMEREN TO LC4 IS CURRENTLY BEING REVIEWED BY AMEREN AND WILL BE COORDINATED WITH SUCCESSFUL CONTRACTOR.
5. 'F' DESIGNATIONS OF LIGHT FIXTURES SHOWN ON LIGHTING DETAILS SHEET.

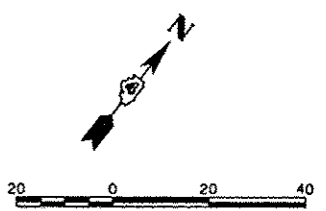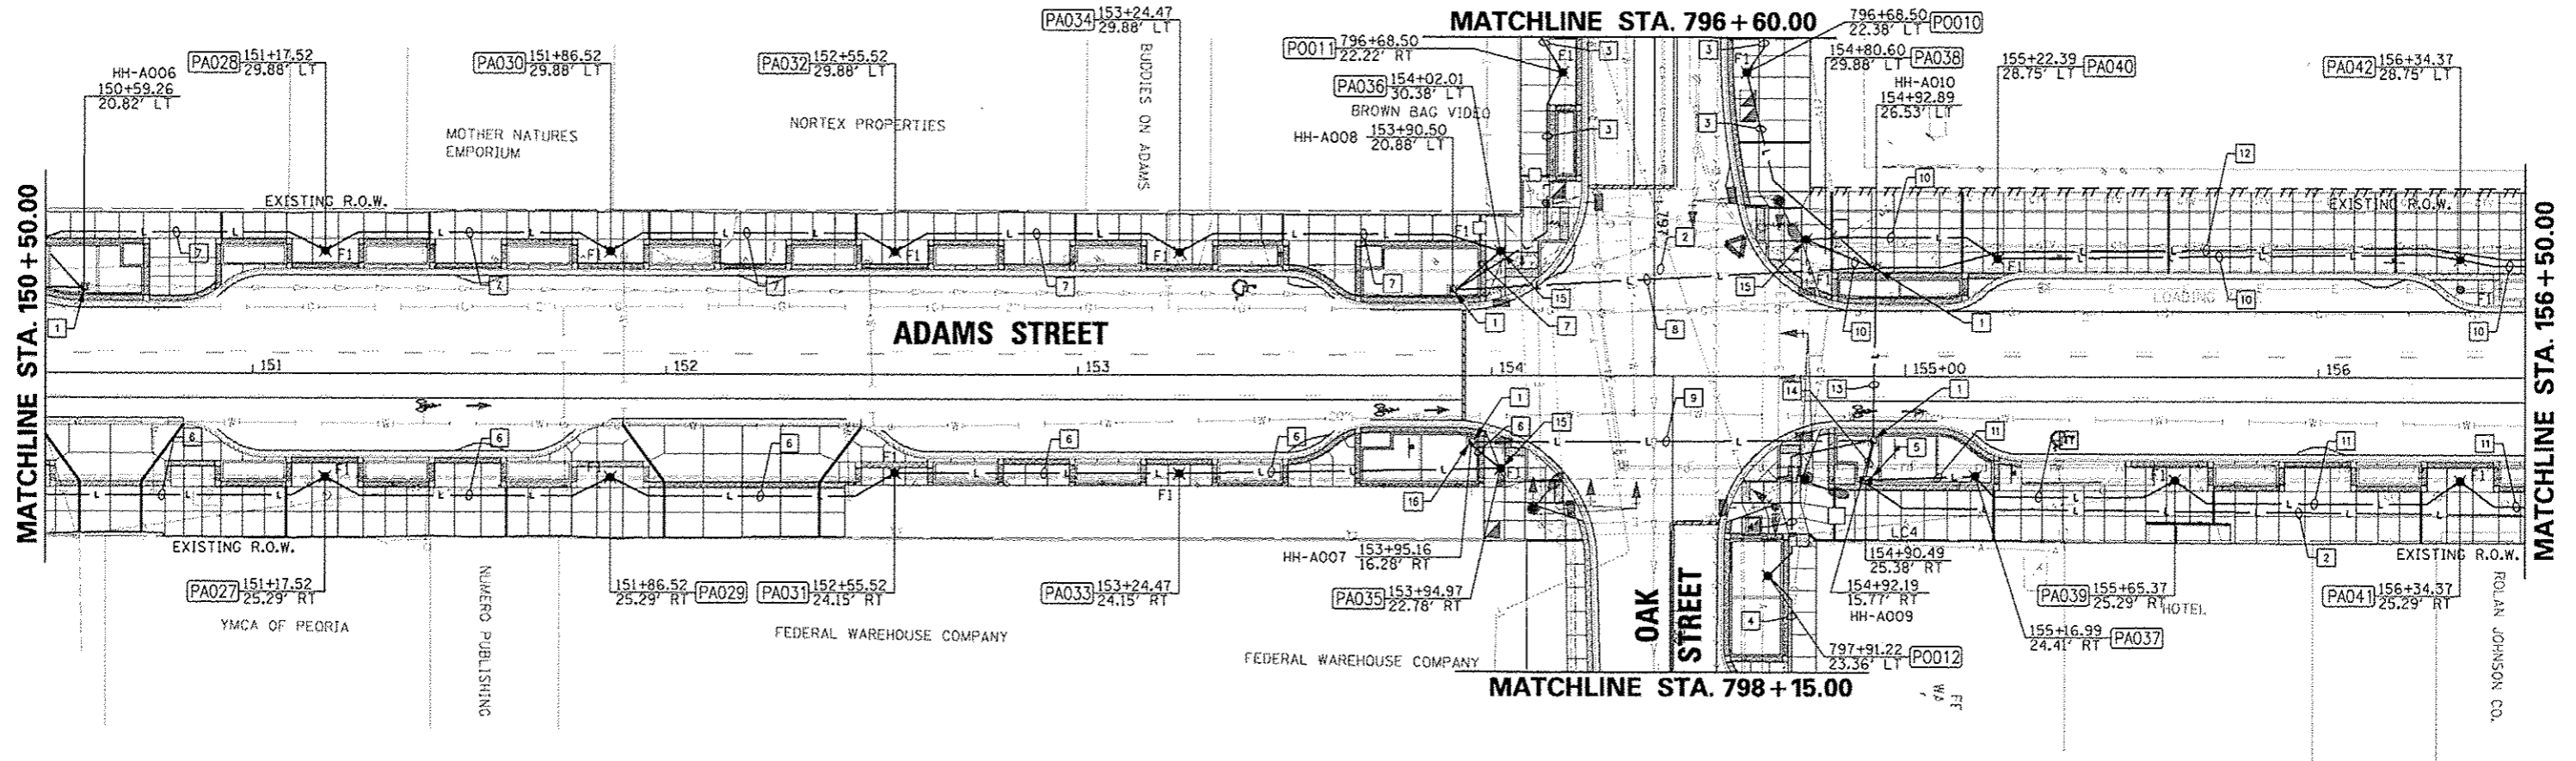

FILE NAME	USER NAME	DESIGNED	REVISED
c:\pwise_work\do_not_delete\des73310\041	mansak01390	JDE	-
	BL0155-shr-11ghv022.dgn	DRAWN	REVISED
		TMT	-
	PLOT SCALE = 3/8"=1'-0"	CHECKED	REVISED
		BMS	-
	PLOT DATE = 07/23/2012	DATE	REVISED
		7/18/12	-

**STATE OF ILLINOIS  
DEPARTMENT OF TRANSPORTATION**

**ADAMS STREET  
LIGHTING PLAN**

SCALE: 1"=20'      SHEET NO. OF SHEETS      STA. 150+50.00 TO STA. 156+50.00

F.A.U. RTE.	SECTION	COUNTY	TOTAL SHEETS	SHEET NO.
66	12-00356-01-PV	PEORIA	519	356
CONTRACT NO. 89626			ILLINOIS FED. AID PROJECT T16-5093150	

**Farnsworth GROUP**  
7707 N. KNOXVILLE AVE. SUITE 100  
PEORIA, ILLINOIS 61614  
(309) 699-0848 / (309) 699-9820 Fax  
www.fwg.com